


FOR CONTINUATION REFER TO
Dwg No. 1903/0/108

FOR CONTINUATION REFER TO
Dwg No. 1903/0/108

DO NOT SCALE

- NOTES:
1. THIS DRAWING SHOULD BE READ IN CONJUNCTION WITH ALL OTHER RELEVANT ENGINEERING DETAILS, DRAWINGS & SPECIFICATIONS.
 2. ALL DIMENSIONS ARE IN METRES UNLESS OTHERWISE STATED. DIMENSIONS ABOVE DIMENSION LINES ARE ALSO IN METRES.
 3. EXISTING LEVELS AND DIMENSIONS ARE TO BE CHECKED AND CONFIRMED BY THE CONTRACTOR PRIOR TO COMMENCEMENT OF WORK.
 4. ANY DISCREPANCIES SHOULD BE REPORTED TO THE CONTRACTOR IMMEDIATELY UPON DISCOVERY. THE CONTRACTOR CAN BE SOUGHT FROM TO THE COMMENCEMENT OF WORK.
 5. PRIOR TO COMMENCEMENT OF WORK, THE CONTRACTOR SHALL BE RESPONSIBLE FOR OBTAINING ALL NECESSARY PERMITS AND APPROVALS FROM THE LOCAL AUTHORITY AND OTHER RELEVANT AGENCIES.
 6. THE LOCATION OF ANY SERVICES SHOWN ON THIS DRAWING IS FOR INFORMATION ONLY. THE CONTRACTOR SHALL BE RESPONSIBLE FOR VERIFYING THE LOCATION OF ALL SERVICES WHICH WILL AFFECT THE WORKS PRIOR TO COMMENCEMENT OF WORK.
 7. ANY RELOCATION/REPAIRS WORKS REQUIRED ARE TO BE COMPLETED IN ADVANCE OF THE PROPOSED WORKS AND IN ACCORDANCE WITH THE RELEVANT STANDARDS AND SPECIFICATIONS.
 8. ALL HIGHWAY BRIDGES TO BE ADAPTED BY O.C. AND ROADS DOWN IN SENSIBLE FOR ADAPTATION LATER.
 9. ALL SERVICES TO BE LAD TO CLASS 5 BEDDING CLASSIFICATION UNLESS SPECIFIED OTHERWISE.

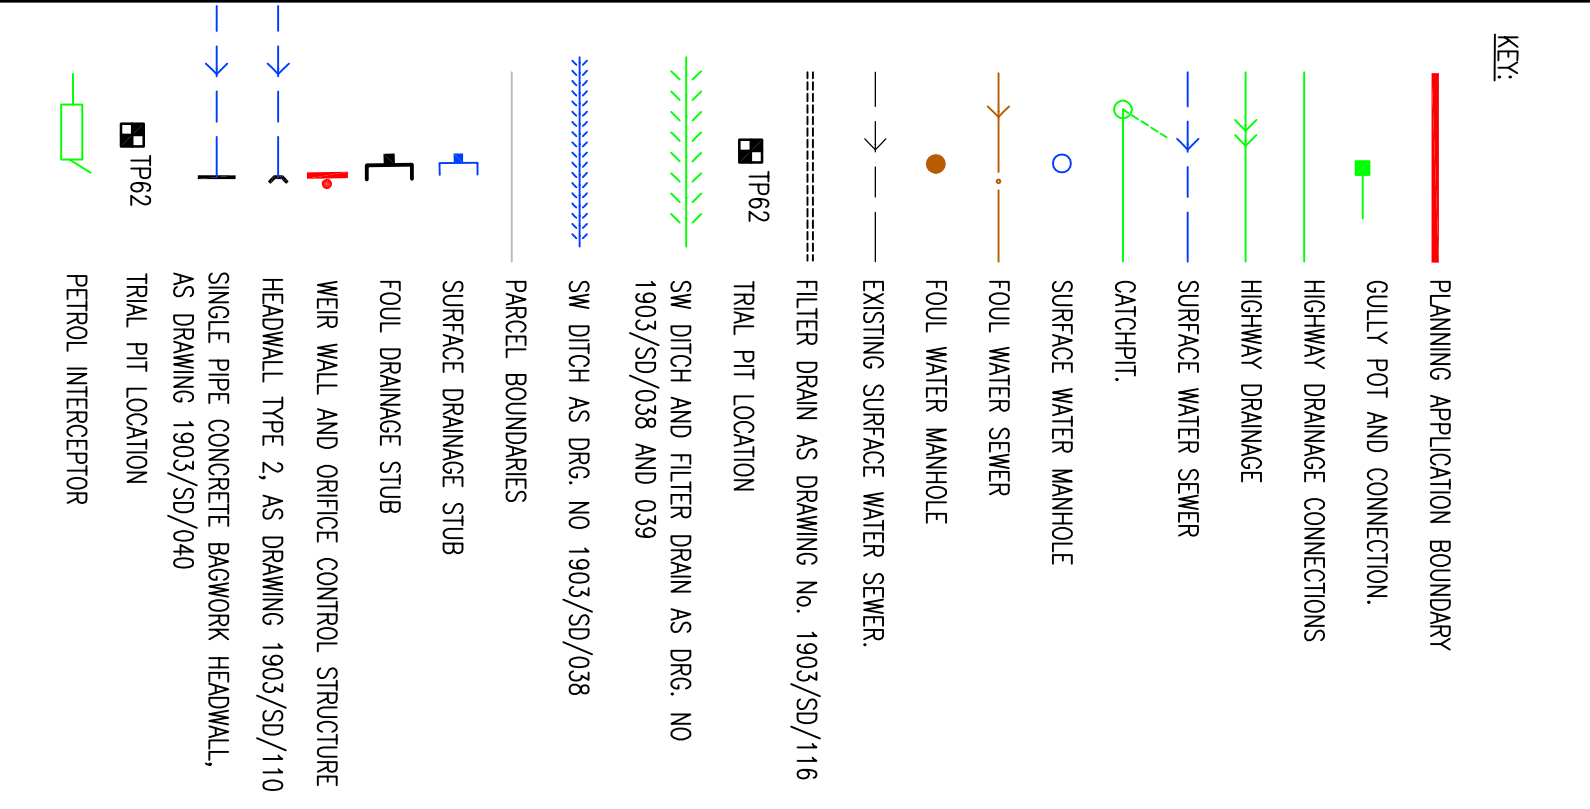

THE DIMENSIONS OF THE REGULATION SIZE AND SHOULD NOT BE FIELD UPON FOR CONSTRUCTION OR COST COMMITMENT PURPOSES

NO.	DATE	BY	DESCRIPTION	CHK	APP
1	12/08/09	SP	ISSUE FOR APPROVAL	SP	SP
2	12/08/09	DC	FINAL LINES ADDED	DC	SP
3	02/09/09	SP	PREP. FOR CONSTRUCTION	SP	SP

FOR TECHNICAL APPROVAL

WSP

Head Office: Bicester, Oxon
Tel: +44 (0)1295 318800 Fax: +44 (0)1295 318100
http://www.wspgroup.com

COUNTRYSIDE PROPERTIES

SOUTHWEST BICESTER
BICESTER, OXFORDSHIRE

PERIMETER ROAD
DRAINAGE LAYOUT

DATE:	19/08/09	BY:	JAM	CHKD:	GH
DATE:	19/08/09	BY:	SP	CHKD:	JAN 2008
PROJECT NO.:	11011903	DRAWING NO.:	1903/0/105	SCALE:	C

© WSP Group plc