

FOR CONTINUATION REFER TO Drg No. 1903/D/106


FOR CONTINUATION REFER TO Drg No. 1903/D/108

FOR CONTINUATION REFER TO Drg No. 1903/D/105

FOR CONTINUATION REFER TO Drg No. 1903/D/110

**DO NOT SCALE**

- NOTES:**
1. THIS DRAWING SHOULD BE READ IN CONJUNCTION WITH ALL OTHER RELEVANT ENGINEERING DETAILS, DRAWINGS & SPECIFICATIONS.
  2. ALL DIMENSIONS ARE IN METRES UNLESS OTHERWISE STATED. DIMENSIONS ABOVE DIMLINES ARE ALSO IN METRES.
  3. PRIOR TO THE COMMENCEMENT OF CONSTRUCTION WORKS, EXISTING LEVELS AND DIMENSIONS ARE TO BE CHECKED AND ANY DISCREPANCIES ARE TO BE REPORTED TO THE CLIENT AND APPROVED BY THE ENGINEER.
  4. ANY DISCREPANCIES SHOULD BE REPORTED TO THE ENGINEER IMMEDIATELY UPON DISCOVERY. THE LOCATION OF ALL DISCREPANCIES ARE TO BE CHECKED AND THE LOCATION CORRECTED.
  5. PRIOR TO CONSTRUCTION WORKS COMMENCING ON SITE, THE LOCATION OF ALL EXISTING SERVICES ARE TO BE CHECKED AND THEIR LOCATION CORRECTED.
  6. THE LOCATION OF ANY SERVICES SHOWN ON THIS DRAWING IS FOR INFORMATION ONLY AND DOES NOT IMPLY RESPONSIBILITY FOR THE LOCATION OF ANY SERVICES WHICH WILL AFFECT THE WORKS FROM THIS DRAWING. ANY DISCREPANCIES ARE TO BE REPORTED TO THE CLIENT IMMEDIATELY UPON DISCOVERY.
  7. ANY REVISIONS/AMENDMENTS REQUIRED ARE TO BE COMPLETED IN ADVANCE OF THE PROPOSED WORKS AND IN ACCORDANCE WITH THE RELEVANT CONTRACT DOCUMENTS AND REQUIREMENTS.
  8. ALL HIGHWAY BRIDGES TO BE ADAPTED BY OGC AND REQUIRE THAT ALL DRAINS BE CONSTRUCTED TO OCC STANDARDS UNLESS SPECIFIED OTHERWISE.
  9. ALL STERNS TO BE LAD TO CLASS 5 BEDDING CLASSIFICATION UNLESS SPECIFIED OTHERWISE.
  10. FOLL WATER SERVICES TO BE ADAPTED BY THAMES WATER UTILITIES UNDER SECTION 104 OF THE WATER INDUSTRY ACT.

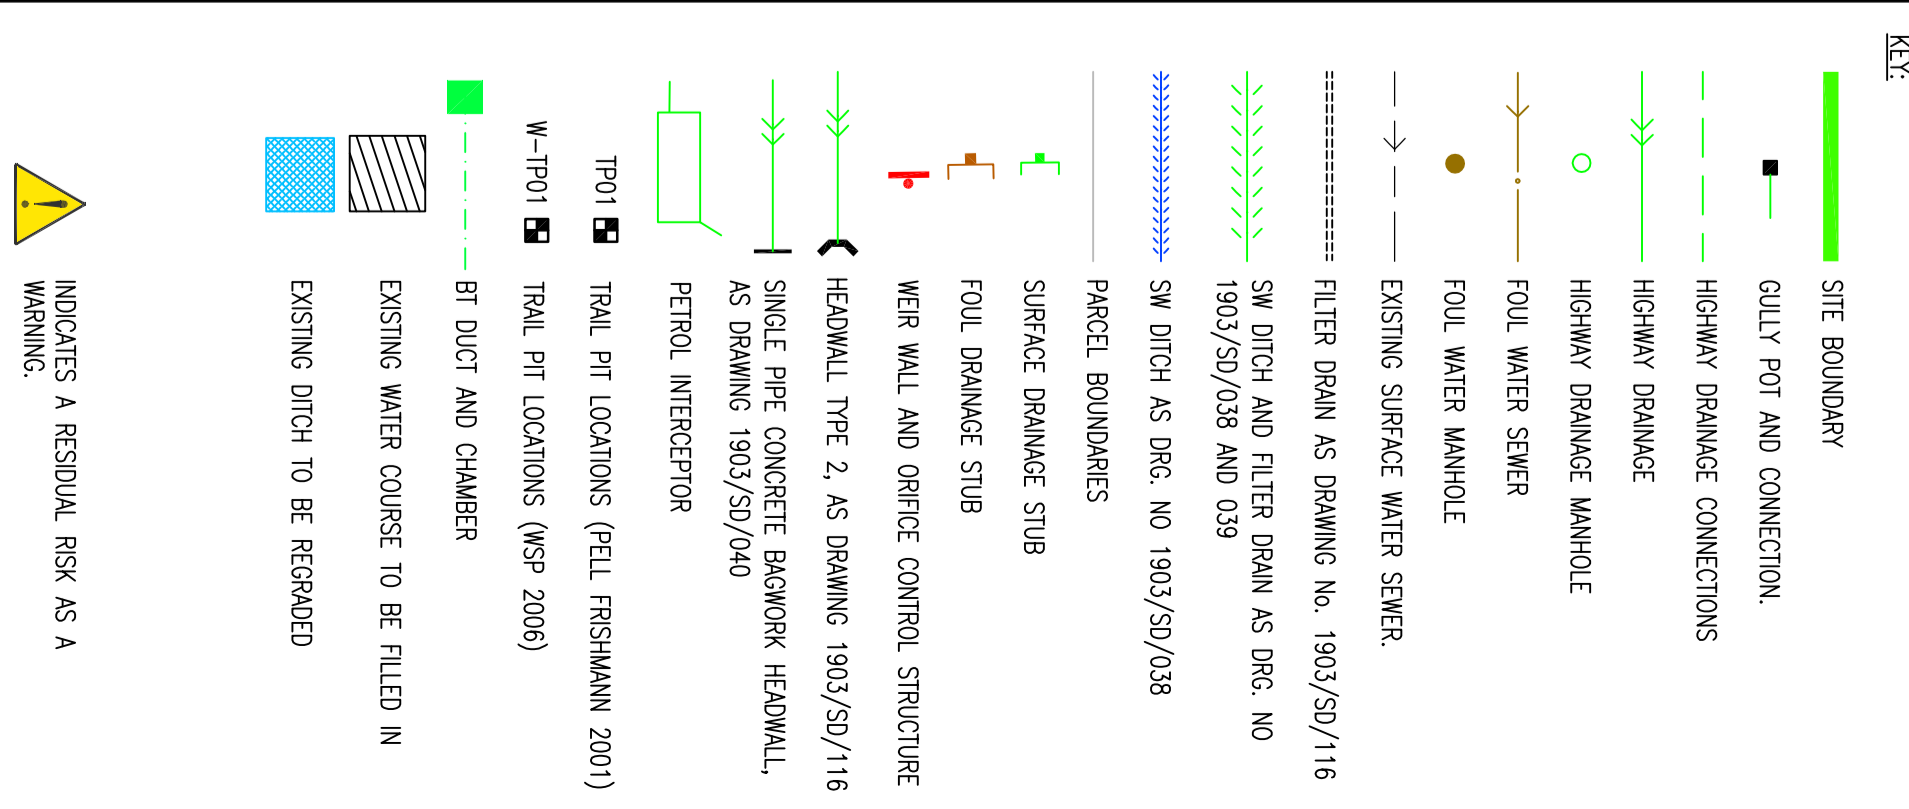

REVISIONS			
NO.	DATE	BY	DESCRIPTION
1	18/02/2010	SP	PREP Dwg
2	19/02/2010	SP	CONSTRUCTION

**FOR TECHNICAL APPROVAL**

Handwritten: (Name) (Title)

**WSP**

Handwritten: (Name) (Title)

Tel: +44 (0)1295 318800 Fax: +44 (0)1295 318100

http://www.wspgroup.com

**COUNTRYSIDE PROPERTIES**

**SOUTHWEST BICESTER**

**BICESTER, OXFORDSHIRE**

**DRAINAGE LAYOUT**

PROJECT NO.	1903-D/09	DATE	JAN 2008
PROJECT NAME	1903/D/09	SCALE	B

© WSP Group plc