

Shakespeare Drive

Scheme Ref: WILKINGTON STONEY ROUNDABOUT	
Sign Ref:	15-001
Sign Height:	6.0m
Letter Colour:	BLACK
Background Colour:	BLACK
Background Shape:	RECTANGLE
Material:	CLASS 2 (12899-1-2001)
Height:	4.0m
Width:	0.224m

Town Centre


Scheme Ref: WILKINGTON STONEY ROUNDABOUT	
Sign Ref:	15-002
Sign Height:	6.0m
Letter Colour:	BLACK
Background Colour:	BLACK
Background Shape:	RECTANGLE
Material:	CLASS 2 (12899-1-2001)
Height:	4.0m
Width:	0.224m

Kingsmere

Scheme Ref: WILKINGTON STONEY ROUNDABOUT	
Sign Ref:	15-003
Sign Height:	6.0m
Letter Colour:	BLACK
Background Colour:	BLACK
Background Shape:	RECTANGLE
Material:	CLASS 2 (12899-1-2001)
Height:	4.0m
Width:	0.224m

Middleton Stoney

Scheme Ref: WILKINGTON STONEY ROUNDABOUT	
Sign Ref:	15-004
Sign Height:	6.0m
Letter Colour:	BLACK
Background Colour:	BLACK
Background Shape:	RECTANGLE
Material:	CLASS 2 (12899-1-2001)
Height:	4.0m
Width:	0.224m

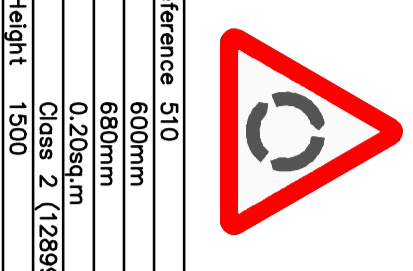


NEW ROUNDABOUT AHEAD

SIGN REFERENCE: 610	
Sign Ref:	15-001
Sign Height:	6.0m
Letter Colour:	BLACK
Background Colour:	BLACK
Background Shape:	RECTANGLE
Material:	CLASS 2 (12899-1-2001)
Height:	4.0m
Width:	0.224m

SIGN REFERENCE: 610	
Sign Ref:	15-002
Sign Height:	6.0m
Letter Colour:	BLACK
Background Colour:	BLACK
Background Shape:	RECTANGLE
Material:	CLASS 2 (12899-1-2001)
Height:	4.0m
Width:	0.224m

SIGN REFERENCE: 610	
Sign Ref:	15-003
Sign Height:	6.0m
Letter Colour:	BLACK
Background Colour:	BLACK
Background Shape:	RECTANGLE
Material:	CLASS 2 (12899-1-2001)
Height:	4.0m
Width:	0.224m

SIGN REFERENCE: 712	
Sign Ref:	15-004
Sign Height:	7.5m
Letter Colour:	BLACK
Background Colour:	BLACK
Background Shape:	RECTANGLE
Material:	CLASS 1 (12899-1-2001)
Height:	4.0m
Width:	0.18 m3

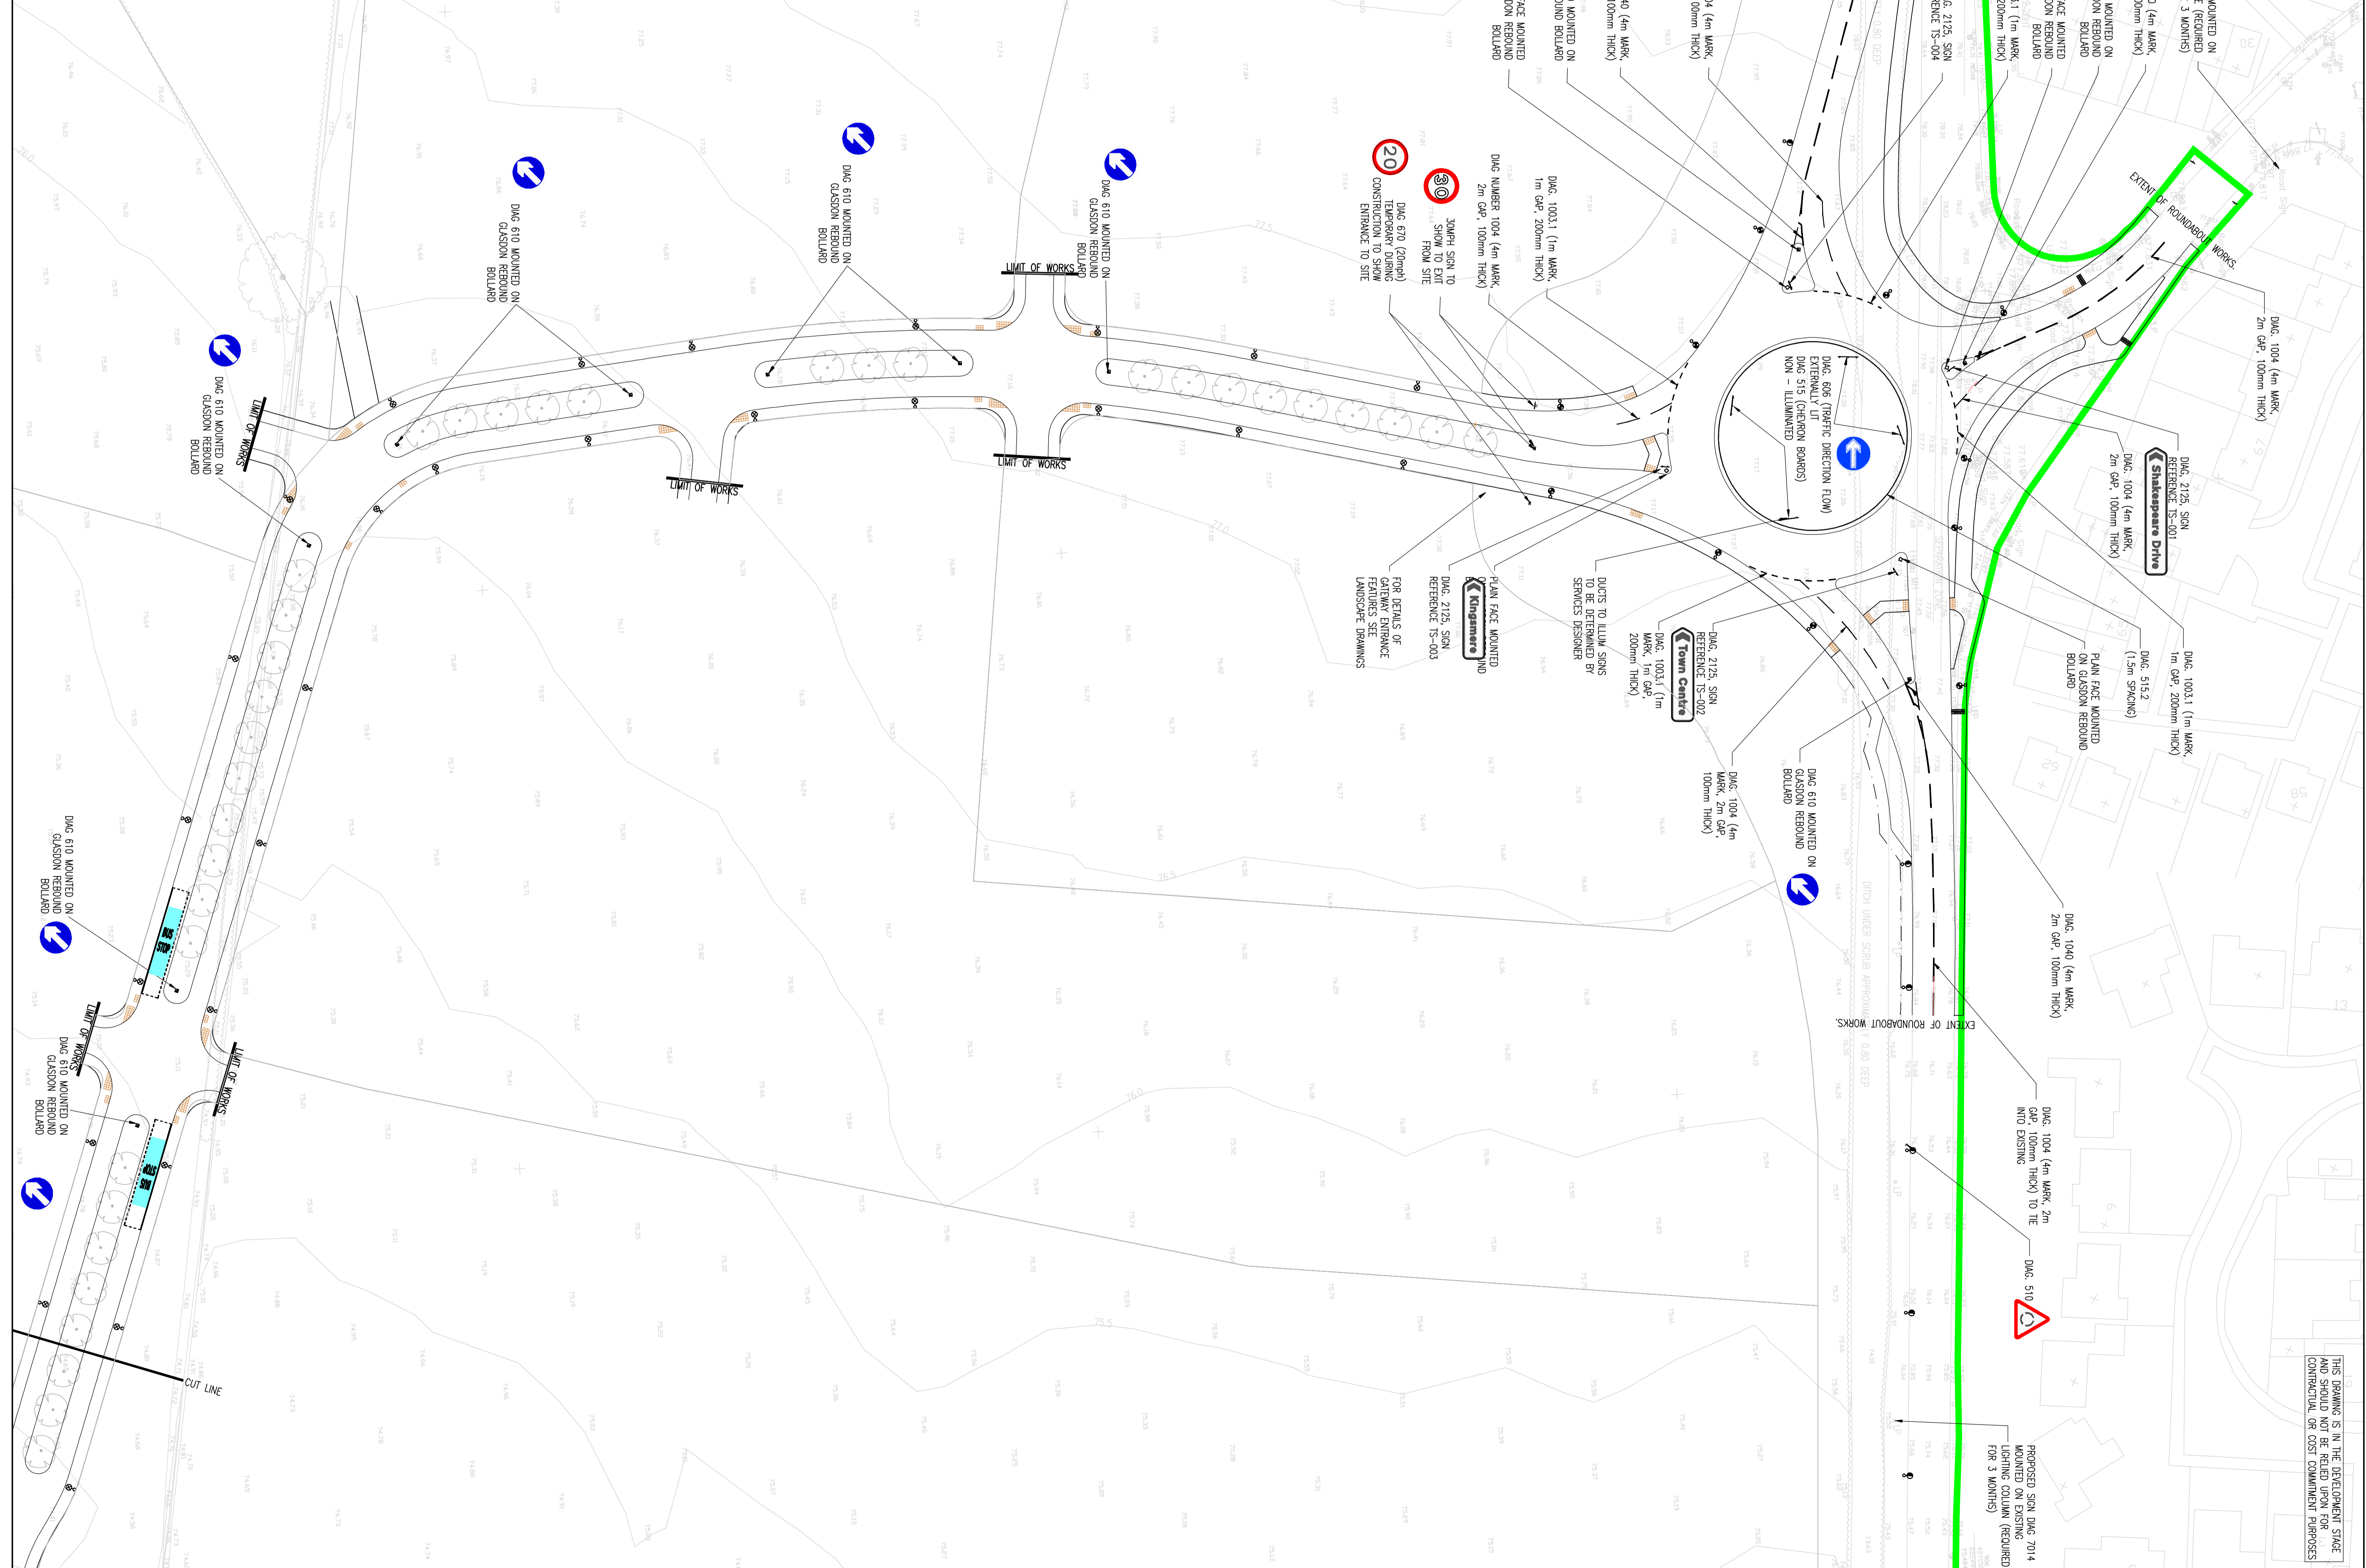

DO NOT SCALE

1. THIS DRAWING IS THE DEVELOPMENT STATE AND SHOULD NOT BE REPRODUCED FOR ANY OTHER RELEVANT UNDERGROUND DETAILS, DRAWINGS & SPECIFICATIONS.

2. ALL DIMENSIONS ARE IN METRES UNLESS OTHERWISE STATED. DIMENSIONS ABOVE DRAWMAN ARE ALSO IN METRES.

3. BEFORE THE COMMENCEMENT OF CONSTRUCTION WORKS, EXISTING LEVELS AND DIMENSIONS ARE TO BE CHECKED AND CORRECTED ON SITE.

4. ANY DIMENSIONS SHOULD BE REFERRED TO THE DRAWING ON WHICH THE DIMENSIONS ARE SHOWN. THE LOCATION OF ALL EXISTING SERVICES ARE TO BE CHECKED AND RECORDED BEFORE THE COMMENCEMENT OF WORKS.

5. BEFORE CONSTRUCTION WORKS COMMENCE ON SITE, THE LOCATION OF ALL EXISTING SERVICES ARE TO BE CHECKED AND RECORDED ON THE DRAWING.

6. THE LOCATION OF ANY SERVICES SHOWN ON THIS DRAWING ARE INDICATED BY DIMENSION LINES. THE RESPONSIBILITY OF THE ALL SERVICES WHICH WILL AFFECT THE WORKS SHOWN TO BE CHECKED AND RECORDED ON SITE.

7. ANY REVISIONS/ALTERATIONS TO THIS DRAWING ARE TO BE MADE BY A REGISTERED PROFESSIONAL ENGINEER.

8. DIMENSIONS TO BE REFERRED TO SERVICES DESIGNER.

9. STREET LIGHTING COLUMN TO BE LOCATED IN BLOCK 15 2m FROM VERGE.

10. REFER TO SIGN FACE (DWG No: 1902/1902) AND BOLLARD DWG No: 1902/21/19.

11. BARRIERS SIGN - CHANGING REFER TO TSD&D DRAWING REFERENCES.

12. STREET LIGHTING LAYOUT TO BE REFERRED TO WILKINGTON STONEY ROAD OUTSIDE OF WORKS WILL BE CARRIED OUT AT LATER DATE.

13. PROPOSED STREET LIGHT COLUMN HEIGHT 10m

14. PROPOSED STREET LIGHT COLUMN HEIGHT 10m

15. DMC 610 ROUNDABOUT (REFER TO DMC NO. 1903/21/19)

16. PLAN RECESSED ROUNDABOUT (REFER TO DMC NO. 1903/21/19)

17. BARRIERS SIGN - CHANGING REFER TO TSD&D DRAWING REFERENCES.

FOR TECHNICAL APPROVAL

DATE	NO	BY	CHK	APP
11/01/2023	1	JM	JM	
15/01/2023	2	JM	JM	
18/01/2023	3	JM	JM	
22/01/2023	4	JM	JM	
25/01/2023	5	JM	JM	
28/01/2023	6	JM	JM	
31/01/2023	7	JM	JM	
03/02/2023	8	JM	JM	
06/02/2023	9	JM	JM	
09/02/2023	10	JM	JM	
12/02/2023	11	JM	JM	
15/02/2023	12	JM	JM	
18/02/2023	13	JM	JM	
21/02/2023	14	JM	JM	
24/02/2023	15	JM	JM	
27/02/2023	16	JM	JM	
01/03/2023	17	JM	JM	
04/03/2023	18	JM	JM	
07/03/2023	19	JM	JM	
10/03/2023	20	JM	JM	
13/03/2023	21	JM	JM	
16/03/2023	22	JM	JM	
19/03/2023	23	JM	JM	
22/03/2023	24	JM	JM	
25/03/2023	25	JM	JM	
28/03/2023	26	JM	JM	
31/03/2023	27	JM	JM	
03/04/2023	28	JM	JM	
06/04/2023	29	JM	JM	
09/04/2023	30	JM	JM	
12/04/2023	31	JM	JM	
15/04/2023	32	JM	JM	
18/04/2023	33	JM	JM	
21/04/2023	34	JM	JM	
24/04/2023	35	JM	JM	
27/04/2023	36	JM	JM	
30/04/2023	37	JM	JM	
03/05/2023	38	JM	JM	
06/05/2023	39	JM	JM	
09/05/2023	40	JM	JM	
12/05/2023	41	JM	JM	
15/05/2023	42	JM	JM	
18/05/2023	43	JM	JM	
21/05/2023	44	JM	JM	
24/05/2023	45	JM	JM	
27/05/2023	46	JM	JM	
30/05/2023	47	JM	JM	
02/06/2023	48	JM	JM	
05/06/2023	49	JM	JM	
08/06/2023	50	JM	JM	
11/06/2023	51	JM	JM	
14/06/2023	52	JM	JM	
17/06/2023	53	JM	JM	
20/06/2023	54	JM	JM	
23/06/2023	55	JM	JM	
26/06/2023	56	JM	JM	
29/06/2023	57	JM	JM	
02/07/2023	58	JM	JM	
05/07/2023	59	JM	JM	
08/07/2023	60	JM	JM	
11/07/2023	61	JM	JM	
14/07/2023	62	JM	JM	
17/07/2023	63	JM	JM	
20/07/2023	64	JM	JM	
23/07/2023	65	JM	JM	
26/07/2023	66	JM	JM	
29/07/2023	67	JM	JM	
01/08/2023	68	JM	JM	
04/08/2023	69	JM	JM	
07/08/2023	70	JM	JM	
10/08/2023	71	JM	JM	
13/08/2023	72	JM	JM	
16/08/2023	73	JM	JM	
19/08/2023	74	JM	JM	
22/08/2023	75	JM	JM	
25/08/2023	76	JM	JM	
28/08/2023	77	JM	JM	
31/08/2023	78	JM	JM	
03/09/2023	79	JM	JM	
06/09/2023	80	JM	JM	
09/09/2023	81	JM	JM	
12/09/2023	82	JM	JM	
15/09/2023	83	JM	JM	
18/09/2023	84	JM	JM	
21/09/2023	85	JM	JM	
24/09/2023	86	JM	JM	
27/09/2023	87	JM	JM	
30/09/2023	88	JM	JM	
03/10/2023	89	JM	JM	
06/10/2023	90	JM	JM	
09/10/2023	91	JM	JM	
12/10/2023	92	JM	JM	
15/10/2023	93	JM	JM	
18/10/2023	94	JM	JM	
21/10/2023	95	JM	JM	
24/10/2023	96	JM	JM	
27/10/2023	97	JM	JM	
30/10/2023	98	JM	JM	
02/11/2023	99	JM	JM	
05/11/2023	100	JM	JM	

FOR TECHNICAL APPROVAL

11011603 1800782022 F

© WSP Group plc