


- NOTES:**
- The drawing does not necessarily show all the information needed to interpret the design intent or the construction details.
 - The drawing contains information from more than one source and must be read in conjunction with all relevant specifications.
 - Any apparent drafting errors and differences between other drawings and specifications shall be brought to our attention.

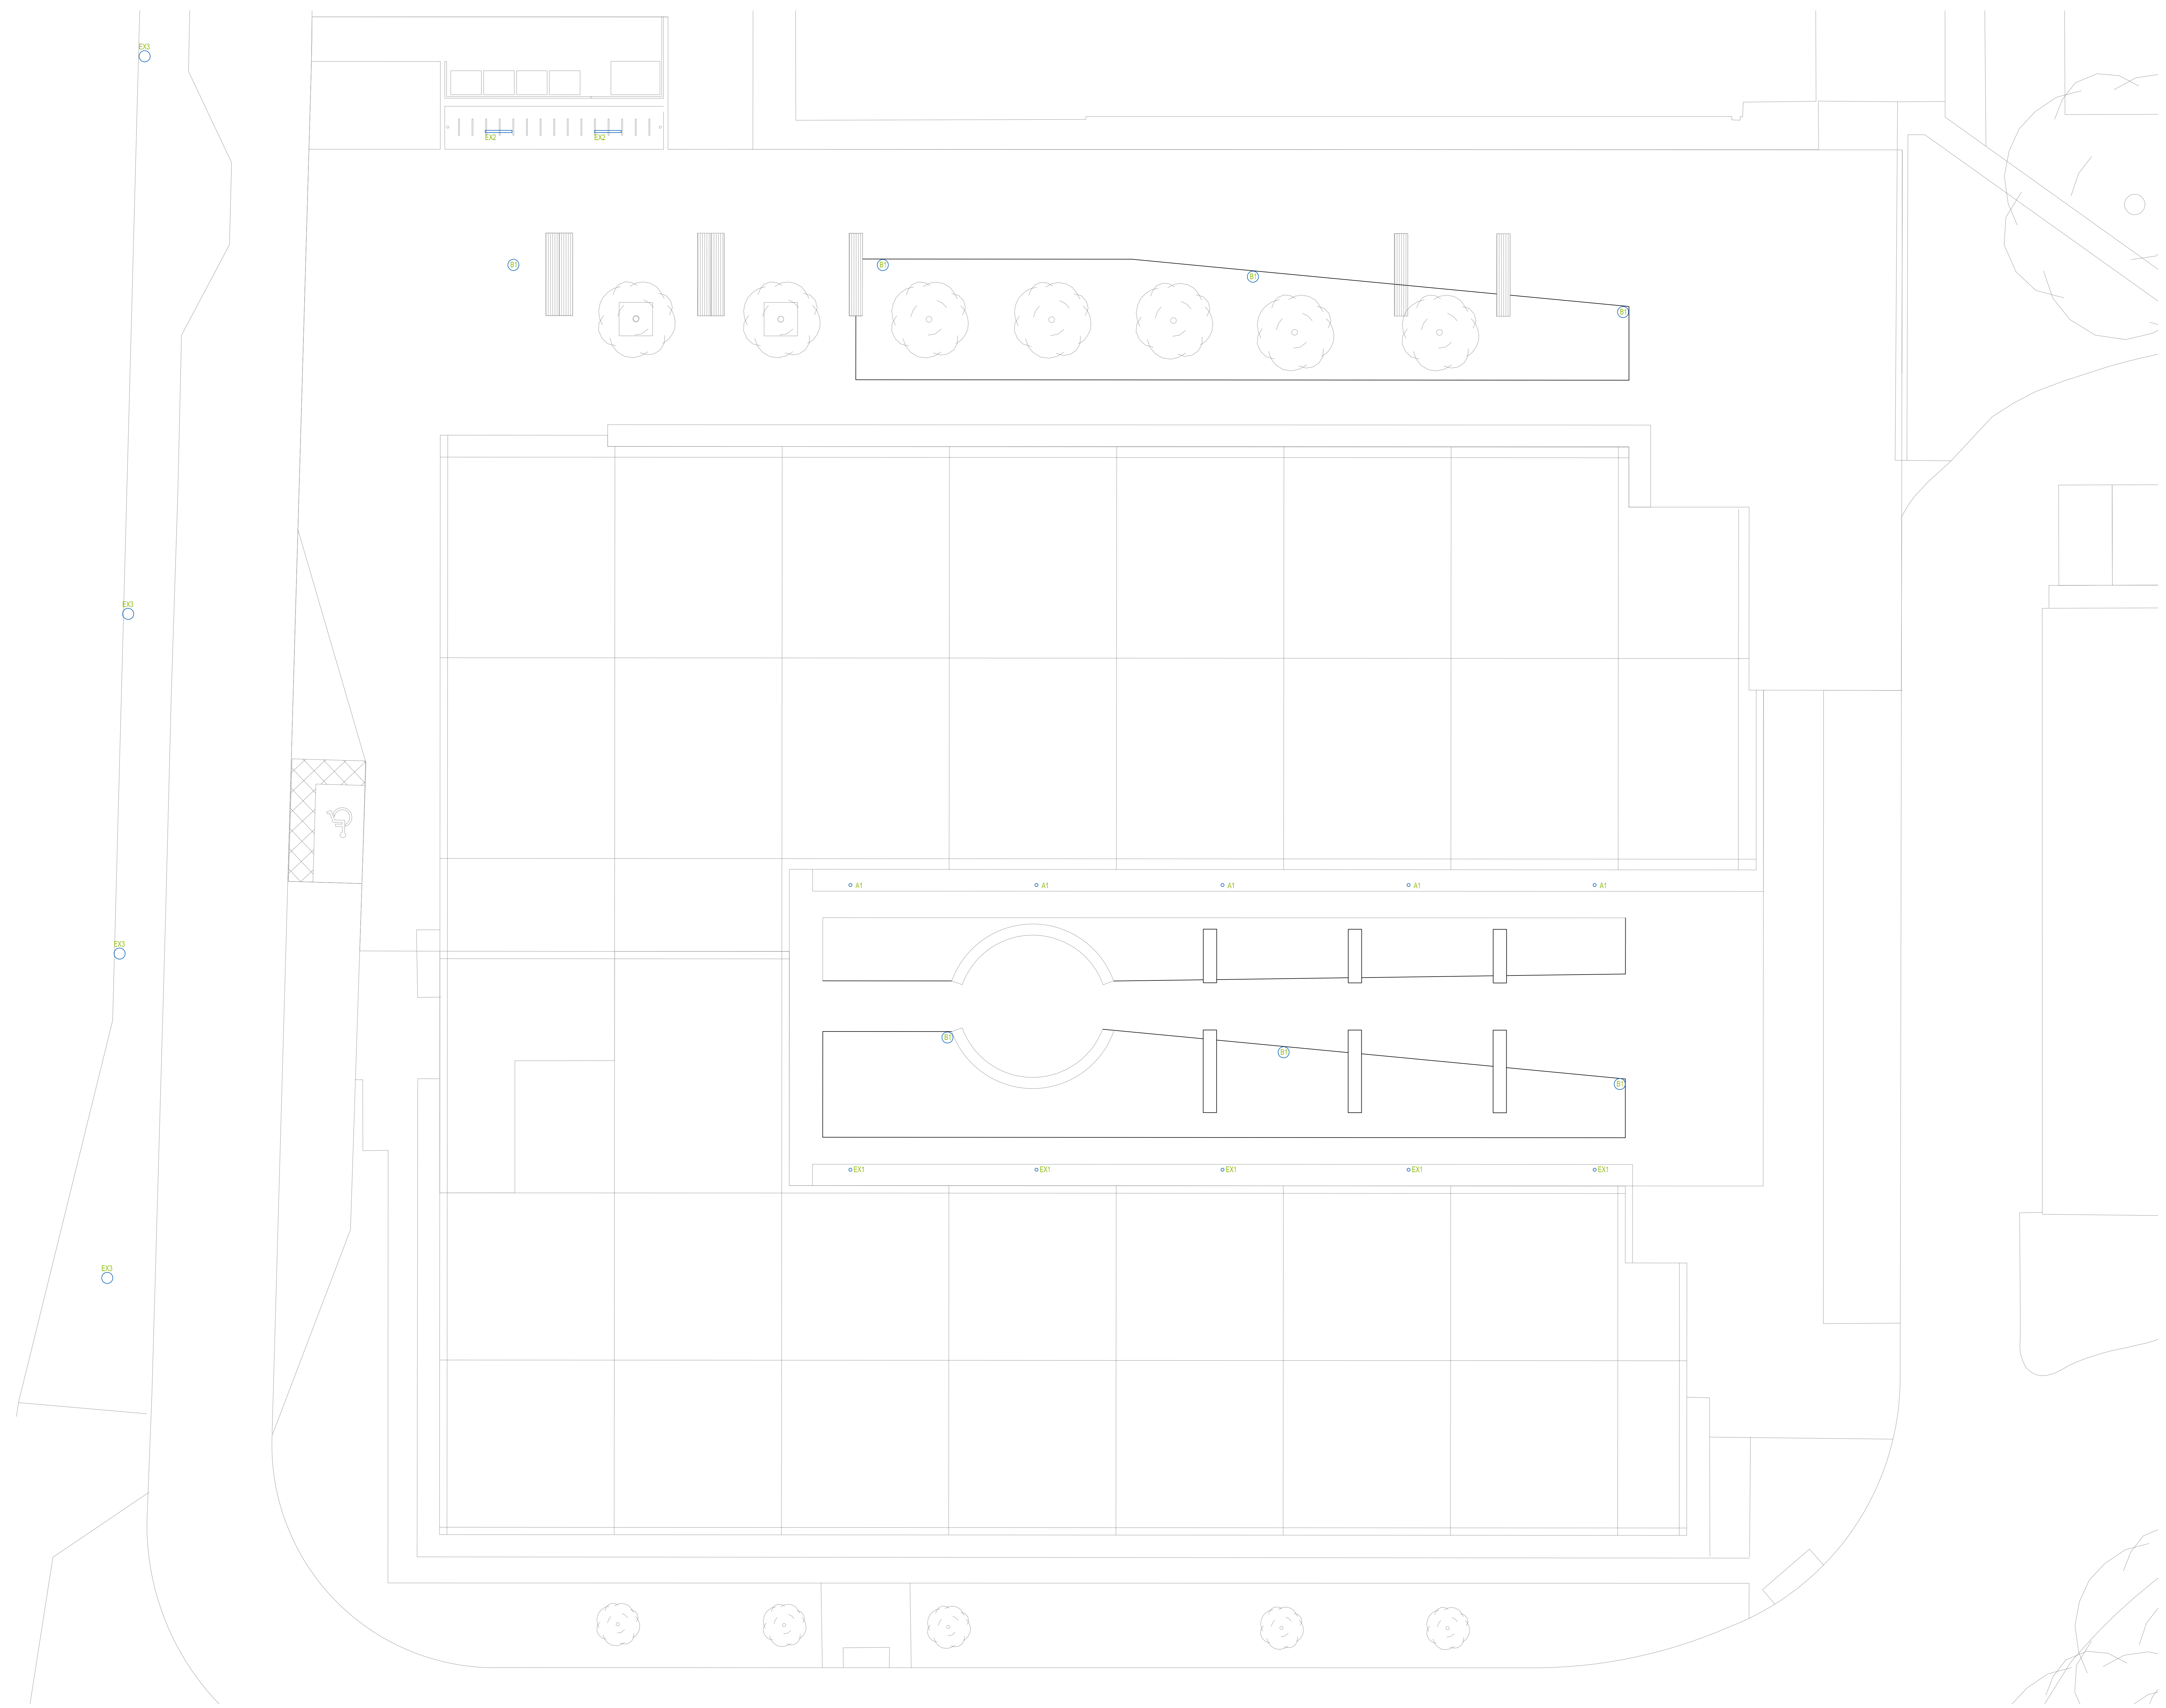

Rev	Description	Drawn by	Checked by	Date
P2	Addition of 1No. B1 column light	BA	SD	06/15

Revisions

Architect
SRA Architects

Client

PRELIMINARY ISSUE

HOARE LEA

BRISTOL
CARDIFF
ISLE of MAN
LEEDS
LONDON
MANCHESTER
OXFORD
PLYMOUTH
POOLE

www.hoarelea.com

Project Title
BEBBROKE CIE EXTENSION

Drawing Title
**ELECTRICAL SERVICES
LIGHTING LAYOUT
EXTERIOR**

Project No	Drawn & Checked by	Reviewed by						
1520483	BA	SD						
Date	Scale	Issuing Office						
JUN 2015	1:100 @ A0	Oxford						
DRAWING NUMBER								
Project Code	Site	Zone	Level	Type	File	Class.	Number	Rev.
1520483	HL	XX	XX	GA	E	630	1001	P2