


Plot date: 18 October 2013

Created By: AD

Date Created: 24 January 2012

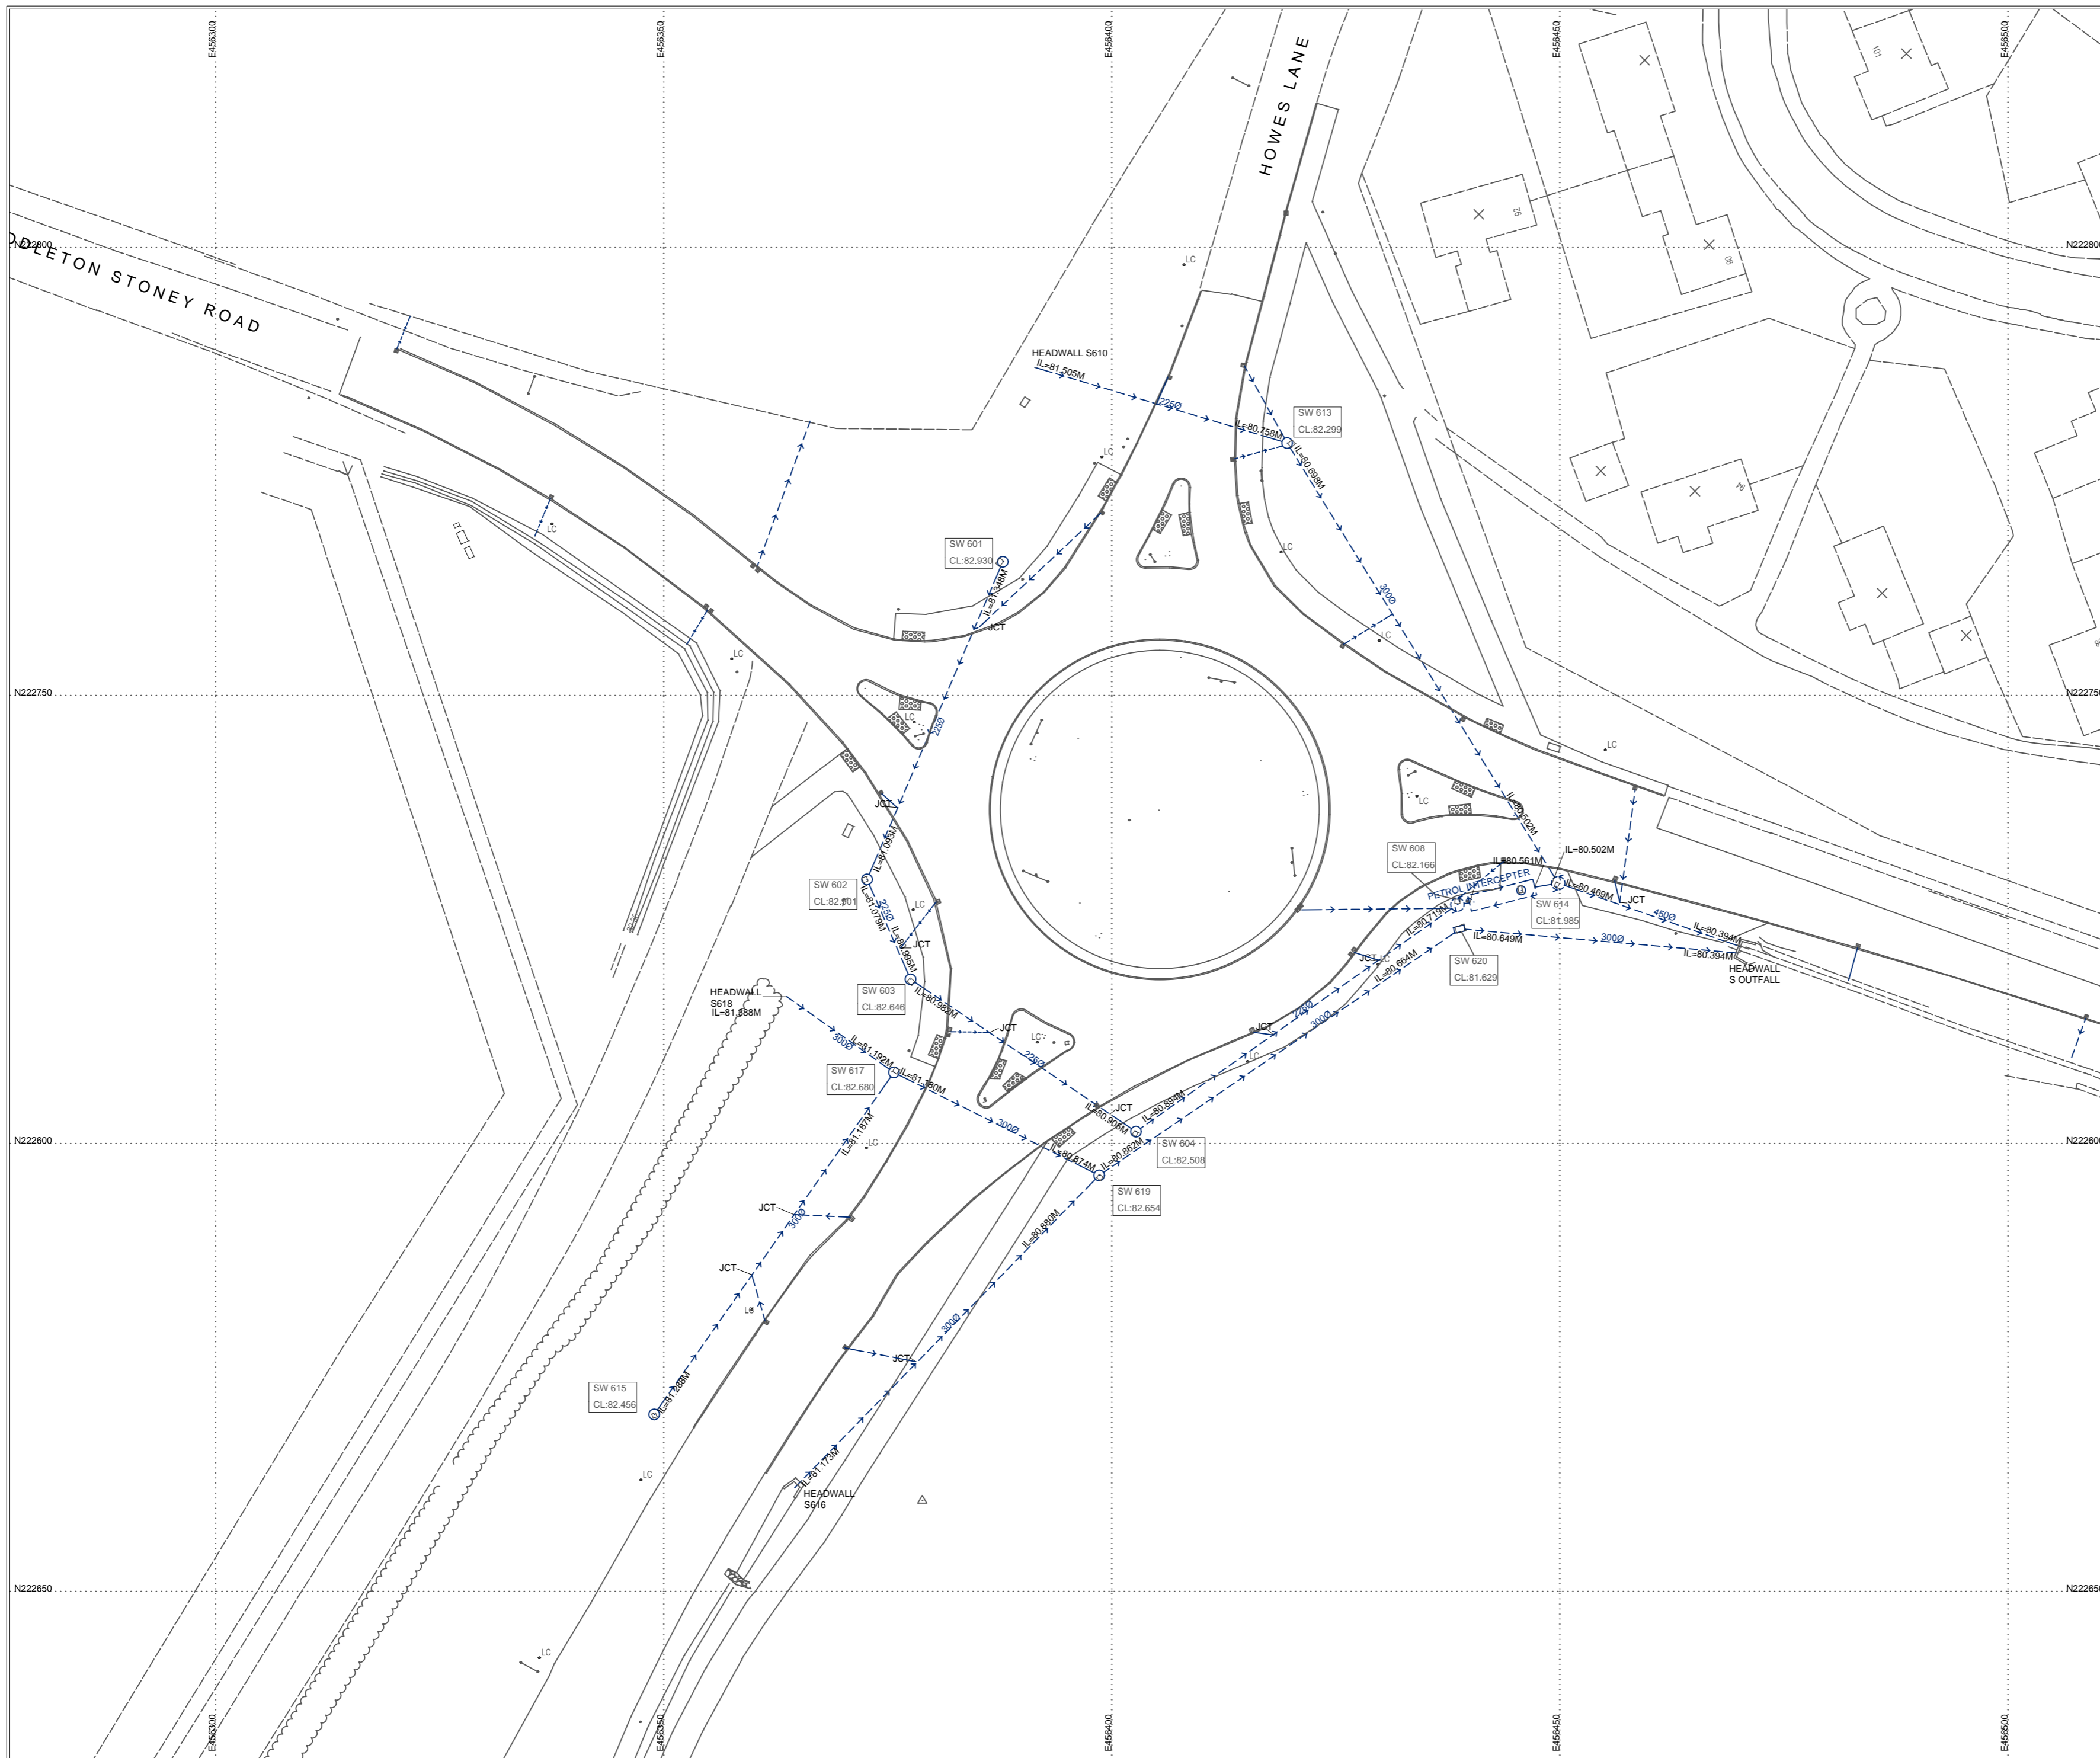

- ### Notes:
- Do not scale from this drawing.
 - All dimensions are in meters unless noted otherwise.
 - All Gully connections 150mm diameter

Key

GENERAL ABBREVIATIONS

AIR VALVE	AV	SURVEY STATION	
BOLLARD	BO	FOOTPATH	
BT INSPECTION CHAMBER	BT	FENCE	
CABLE TV COVER	CATV	GATE	
ELECTRICITY CONTROL BOX	ECB	KERB CHANNEL	
ELECTRIC POLE	EP	SEWERS FOUL	
EARTH ROD	ER	SEWERS STORM	
FIRE HYDRANT	FH		
GAS VALVE	GV		
GATE POST	GP		
GULLY	GY		
INSPECTION COVER	IC	BUILDING	
INVERT LEVEL	IL		
LIGHTING COLUMN	LC	CONTOUR	
MANHOLE	MH	SPOT LEVEL	
MARKER POST	MP		
OS BENCH MARK	OSBM		
RODDING EYE	RE		
ROAD SIGN	RS		
RAIN WATER PIPE	RWP		
RETAINING WALL	RW		
SOIL VENT PIPE	SVP		
STAY CABLES	ST		
STOP VALVE	SV		
TRAFFIC LIGHT	TL		
TELEGRAPH POLE	TP		
VENT PIPE	VP		
WATER LEVEL	WL		
WATER METER	WM		
WASH OUT	WO		

SERVICE LEGEND

CATV	
ELECTRICITY (HV)	
ELECTRICITY (LV)	
GAS	
ST	
TELECOM	
WATER	
WM	
STREETLIGHT	

COORDINATE TABLE

STATION	EASTING	NORTHING	LEVEL

AS BUILT

Rev	By	Chkd	Apprvd	Date	Description

Client
Countryside Properties

J. Breheny Contractors Ltd.
Flordon Road, Cretingham St. Mary,
Needham Market, Suffolk, IP6 8NH
Tel: 01449 720282 Fax: 01449 721593
Email: enquiry@breheny.co.uk
www.breheny.co.uk



Job Title:
Whitelands Farm
South West Bicester
Oxford

Drawing
**Howes Lane Roundabout
Drainage Layout**

Drawn by: AD	Date: 24/01/12
Checked by: SB	Date: 26/01/12
Approved by: KMP	Date: 26/01/12
Drawing No. JBC/4300/AB/26	Revision -

Drawing Scale: 1:500 at A2