


NOTE:
 PROPOSED CLASS 1 INTERIOR WITH
 NOMINAL SIZE OF 4 L/5 IN
 ACCORDANCE WITH EN88-12002
 BY BILTON MANUFACTURING SERVICES
 LTD. OR SIMILAR APPROVED

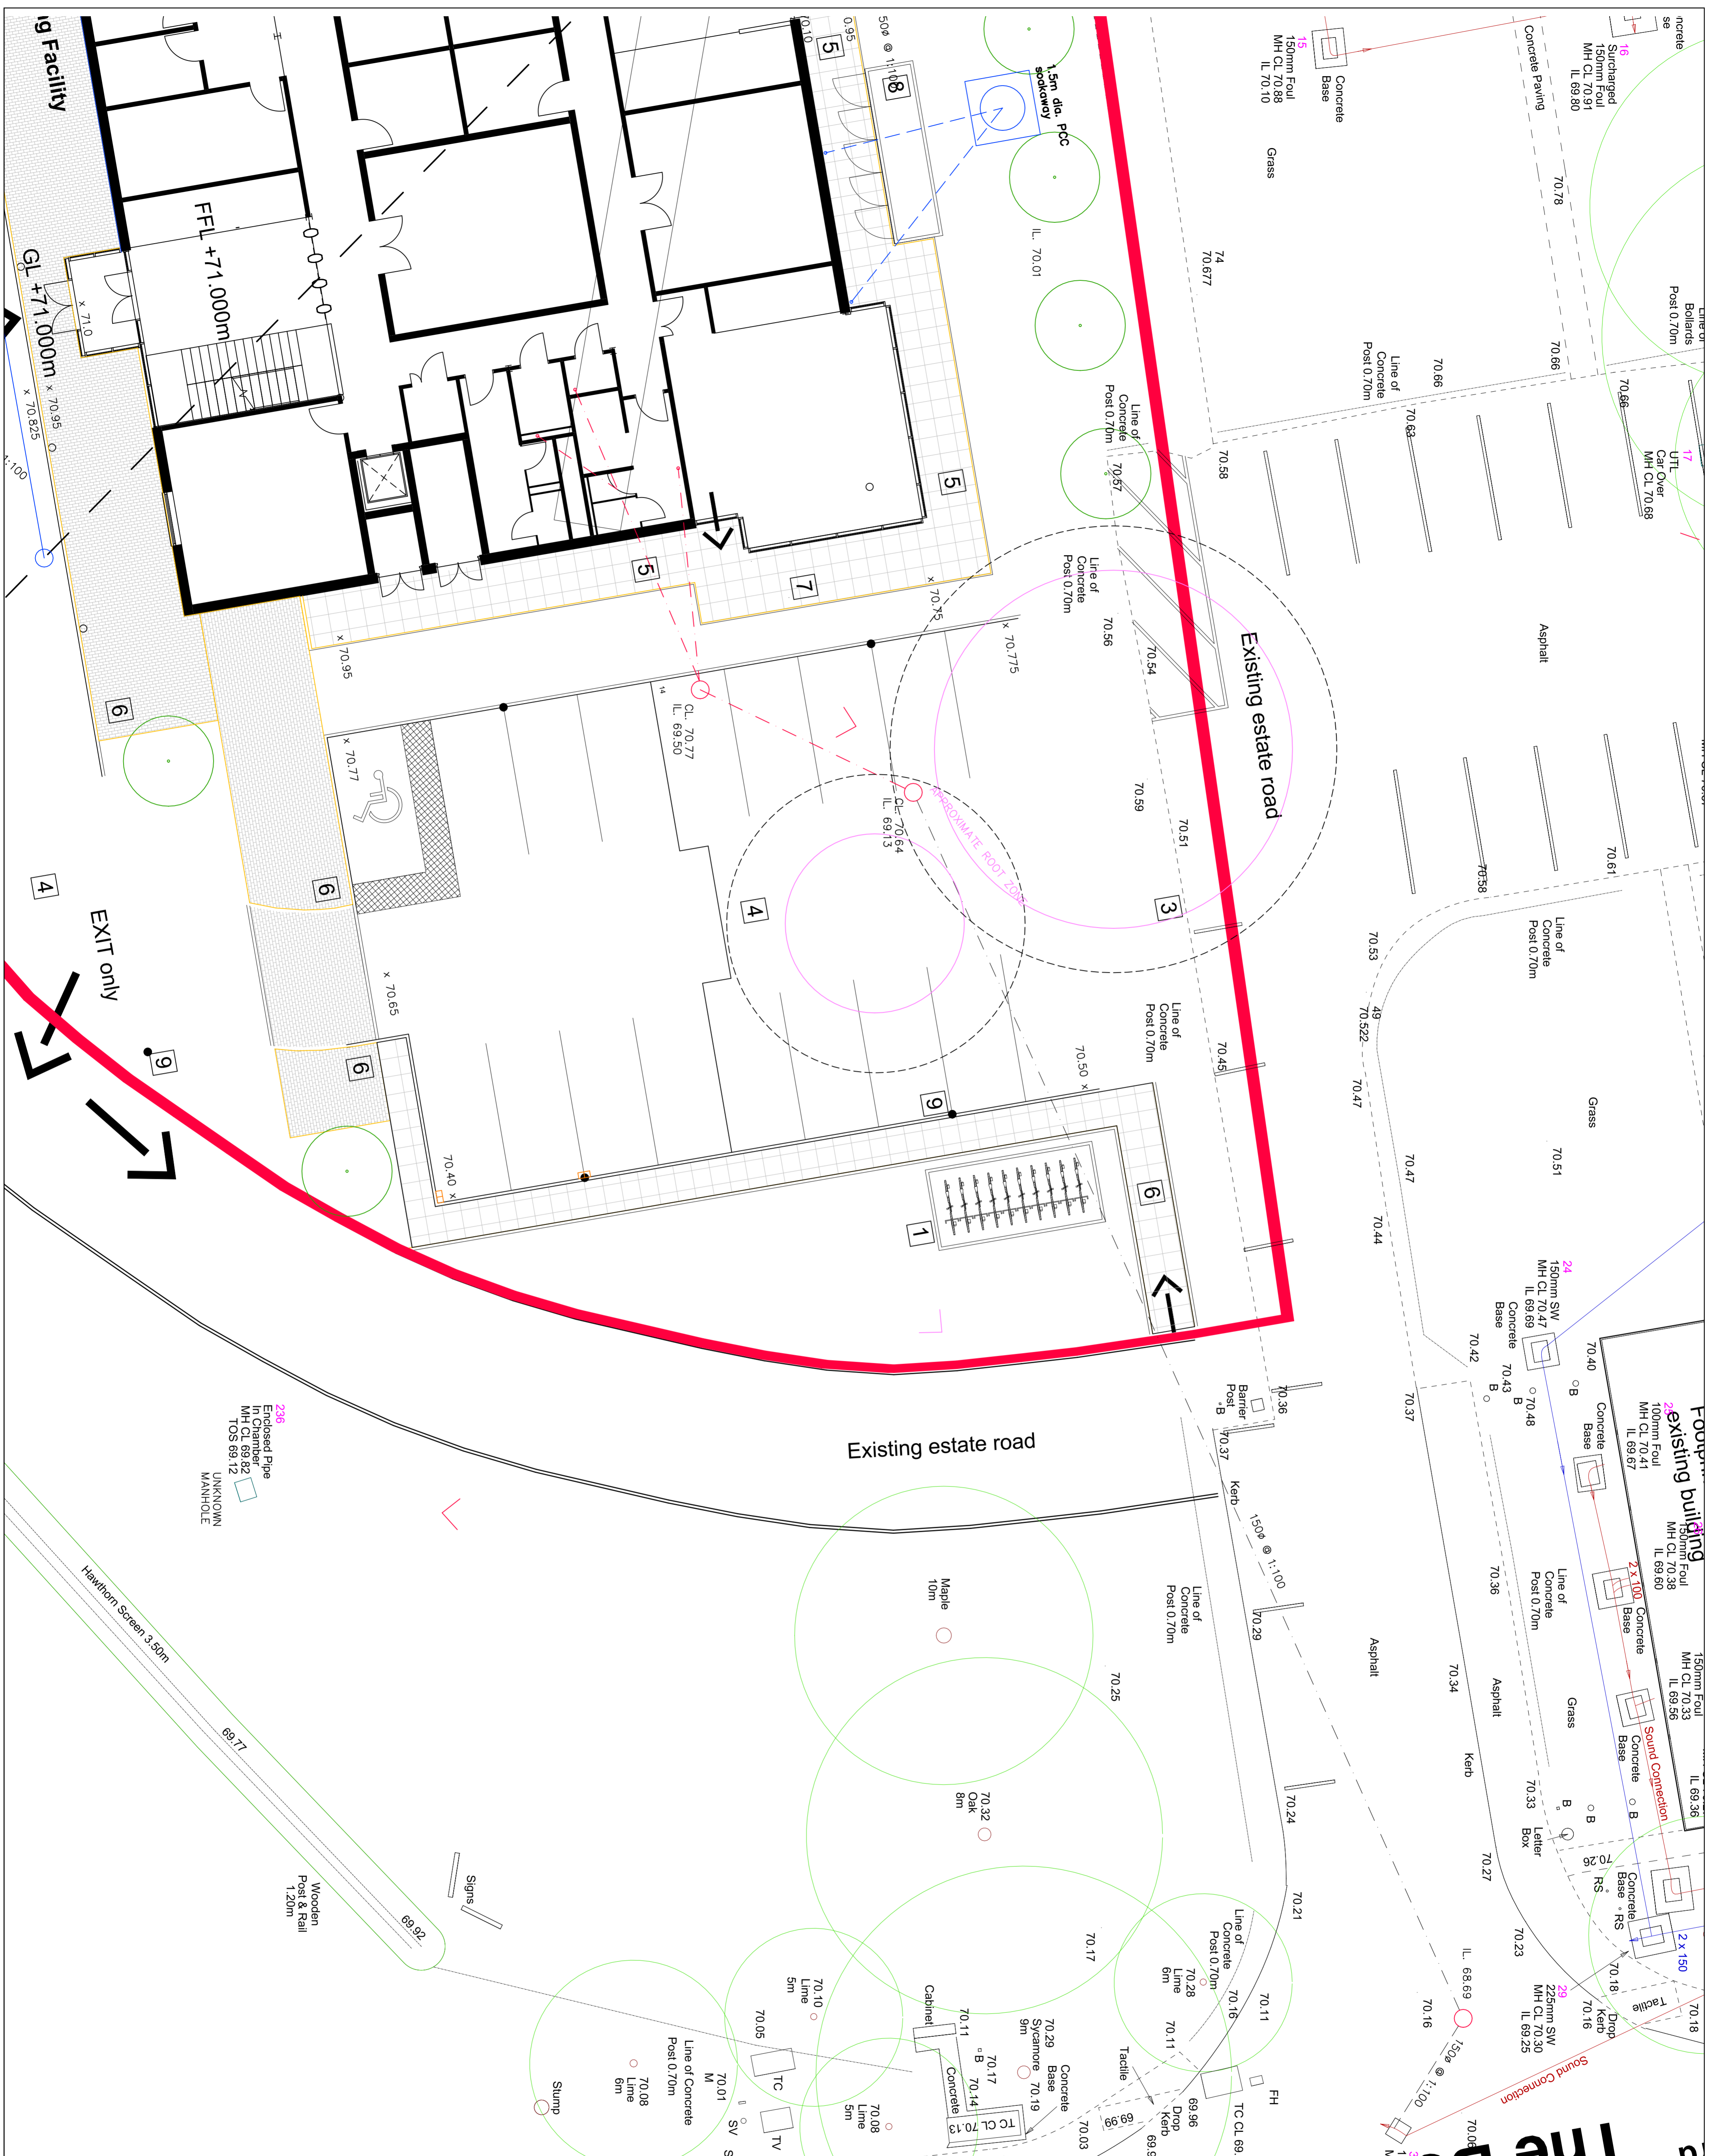

WILCOX COOPER ASSOCIATES CONSULTING STRUCTURAL ENGINEERS BRISTOL OFFICE E: reception@wca.co.uk ☎ 01282 201281 E: wco@wca.co.uk ☎ 01173 298494		BOURNEMOUTH OFFICE E: reception@wca.co.uk ☎ 01202 201281 E: wco@wca.co.uk ☎ 01173 298494	
CLIENT: MILDREN CONSTRUCTION LIMITED PROJECT TITLE: FLIGHT TRAINING FACILITY OXFORD AIRPORT LANGFORD LANE KIDLINGTON OXFORDSHIRE			
DRAWING TITLE: DRAINAGE LAYOUT SHEET 2 OF 2			
DRAWING NO: 10772 DATE: 03 OCT 2017 SCALE: 1:100	PROJECT NO: 03 PROJECT ENGINEER: BT CHECKED:	DRAWING NO: P2 DATE:	PROJECT NO:

NOTE: THIS DRAWING IS CONFIDENTIAL AND IS THE PROPERTY OF WILCOX COOPER ASSOCIATES. IT MAY NOT BE USED OR COPIED WITHOUT WRITTEN CONSENT OF W.C.A.