



This drawing shall not be scaled.
Work from the dimensions shown in the drawing or given in relevant specifications.

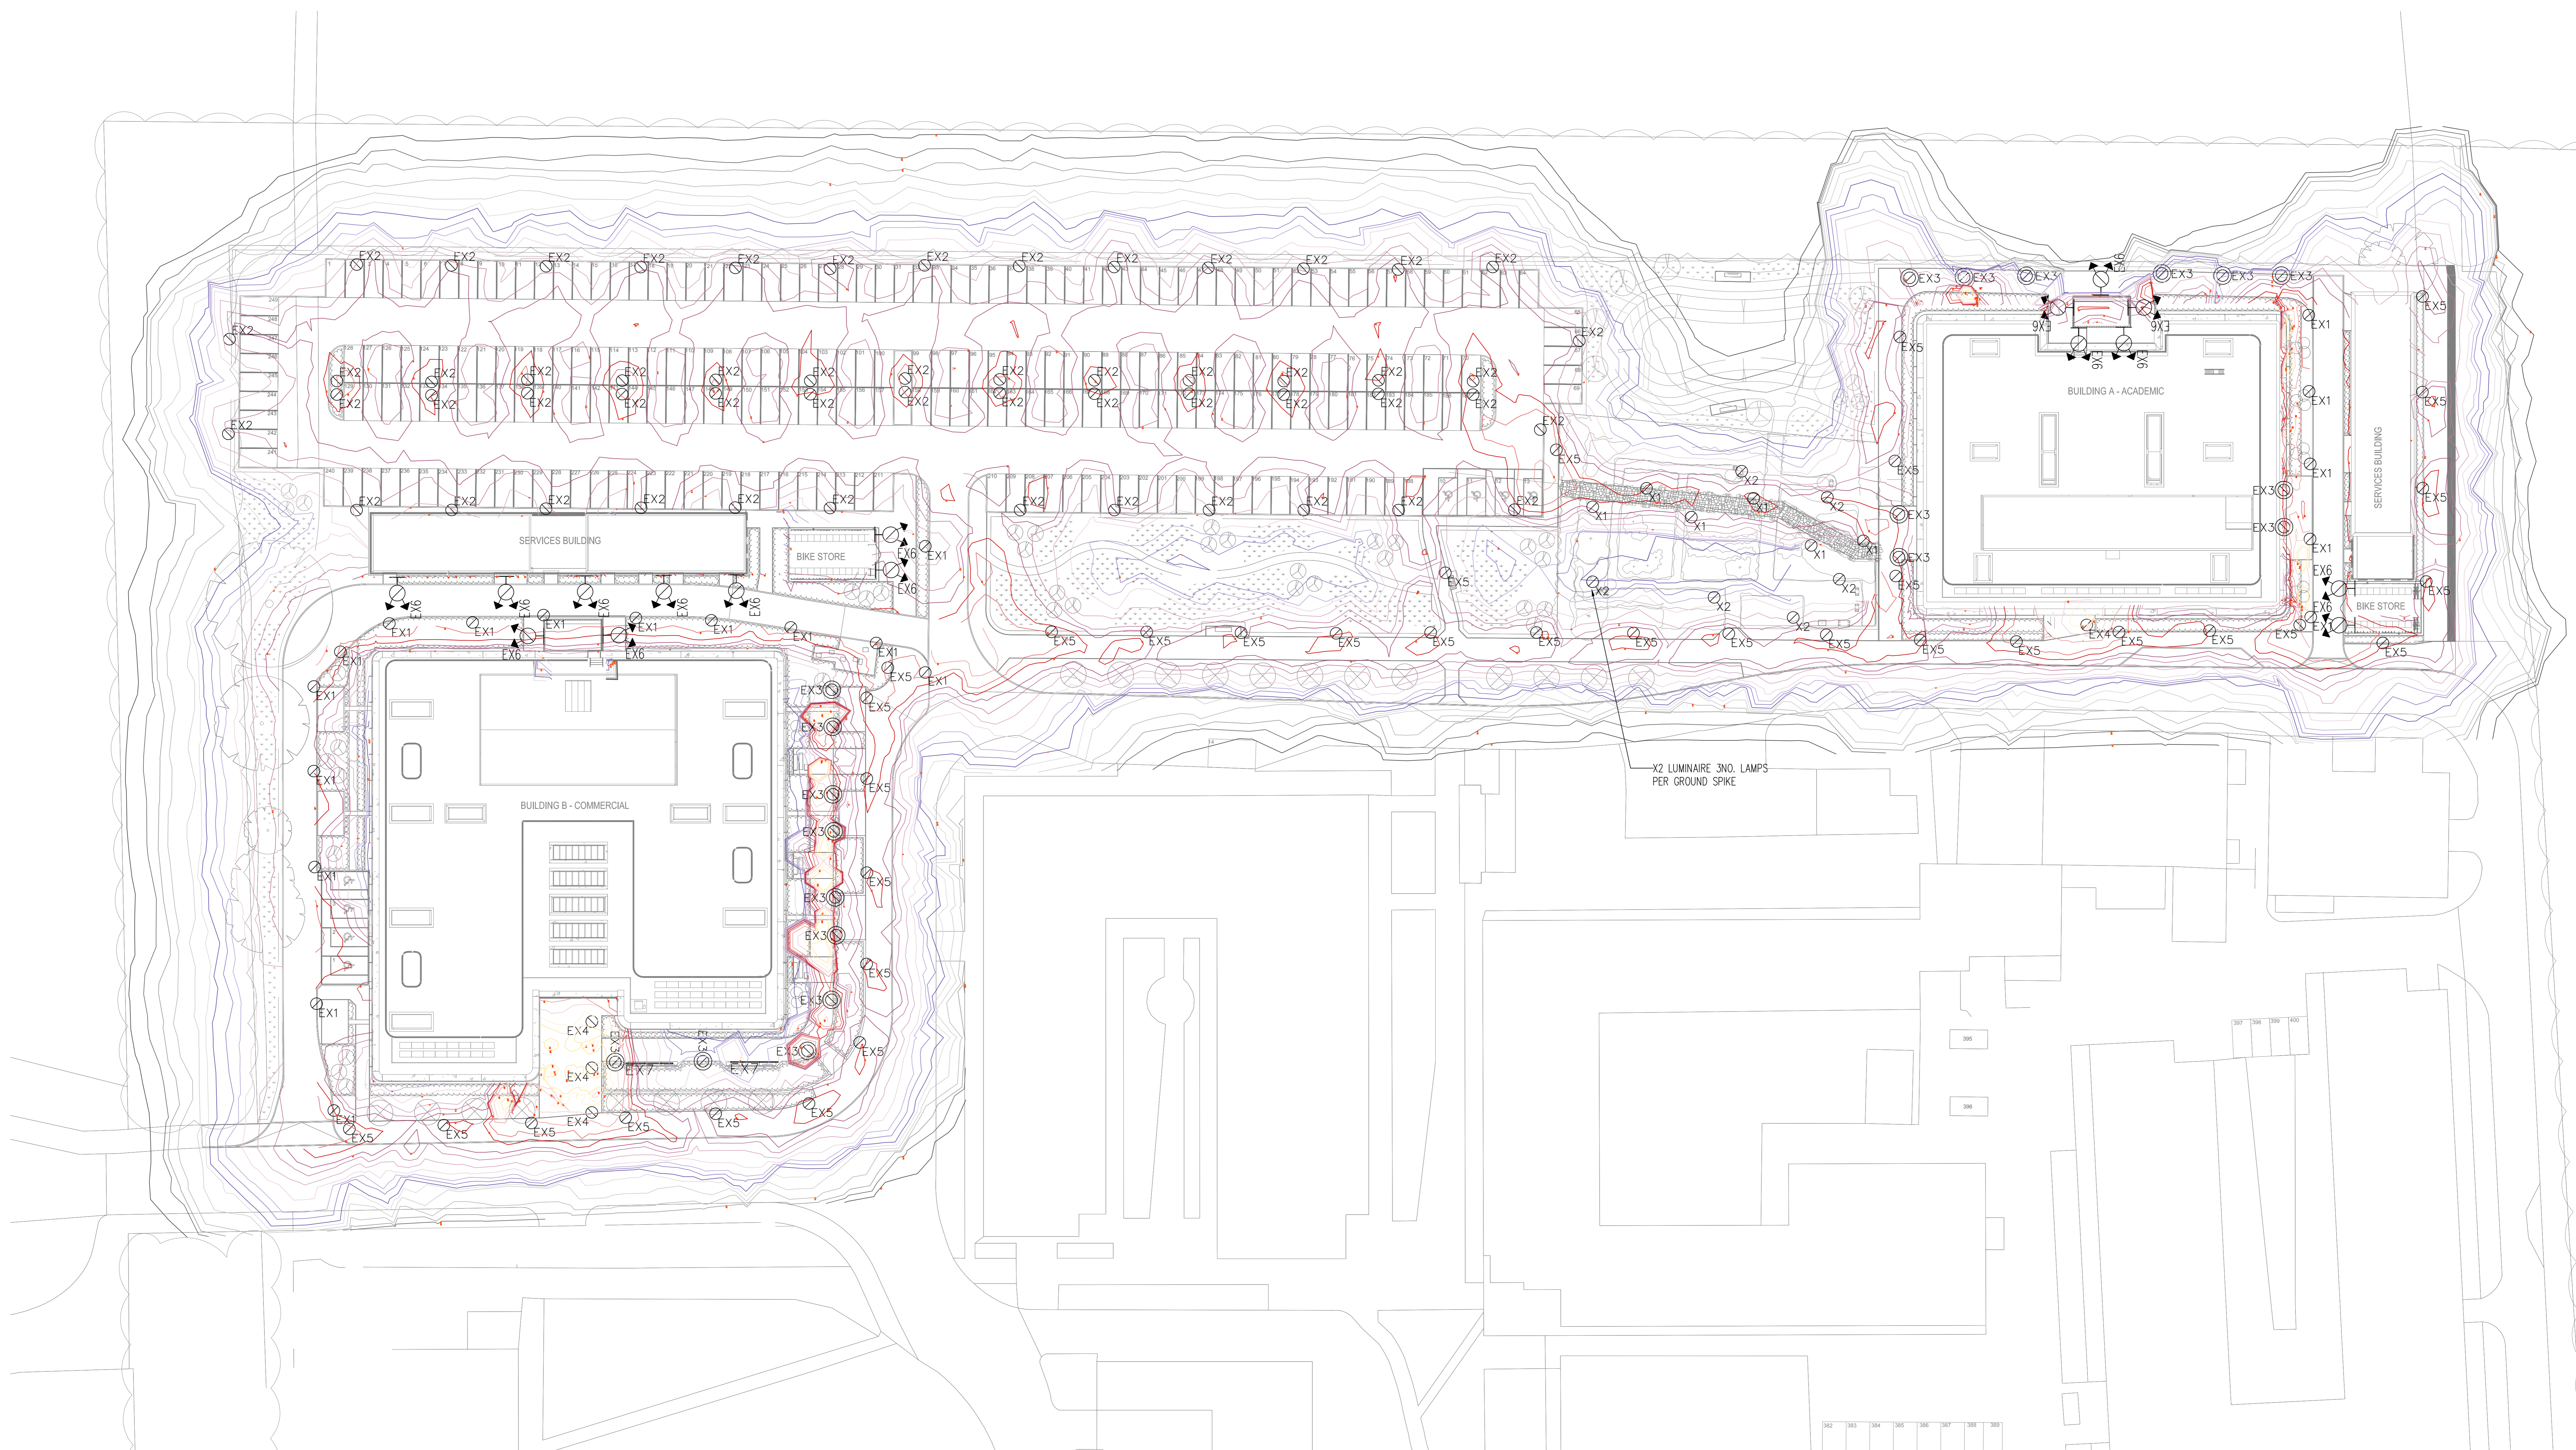

X2 LUMINAIRE 3NO. LAMPS
PER GROUND SPIKE

REV	DESCRIPTION	DATE	DESIGNED	CHECKED	AUTHORIZED
P03	Stage 4 Updates	04/22	JK	LS	MSJ
P02	1st Stage Tender	01/21	JK	LS	MSJ
P01	Stage 3 Issue	09/21	JK	LS	MSJ

 - CDM Regulations:**
In addition to any information included in this drawing on the model from which it is derived, refer also to the project CDM Risk Register for information on residual risks.
- General Notes:**
- The drawing does not necessarily show all the information needed to interpret the design intent or the construction details.
 - The drawing contains information from more than one source and must be read in conjunction with all relevant specifications.
 - Any apparent drafting errors and differences between other drawings and specifications shall be brought to our attention.
- Project Notes:**
- Final quantities and locations to be confirmed with architect, landscape architect and client, and coordinated with final building and landscaping layout.
 - This drawing is to be read in conjunction with Hoare Lea luminaire schedule.
 - All external lighting served from DB/EXT/01.
 - All external lighting to be controlled and grouped as outlined in the External Lighting Report.



Symbol	Description
EX1	Column mounted luminaire
EX2	Column mounted luminaire
EX3	Pole mounted luminaire
EX4	Pole mounted luminaire
EX5	Wall mounted luminaire
EX6	Linear LED strip
EX7	Photocell, street mounted

ARCHITECT:
NBBJ

CLIENT:
Oxford University Developments

PROJECT TITLE:
Begbroke Science Park

DRAWING TITLE:
Electrical Engineering Systems
External Lighting Layout

HOARE LEA (H.L.)

Stage 4 Updates

PERSON RESPONSIBLE FOR:

Drawn: JK	Reviewed: LS	Authoring hour: MSJ
Project No: 3103719	Date: August 2021	Scale: @ A3: 1:7500
DRAWING NUMBER: BBSP-HLEA-XX-XX-DR-E-708-001		Revision:

© Hoare Lea LLP