





# Q6157A A1 TEMPORARY LIGHTING


- 2No. CYCLE SHELTERS
- 1No. SMOKING SHELTER
- EXISTING TREE TO BE RETAINED
- 1No. VAPING SHELTER
- HERAS FENCE PANELS (TREE PROTECTION)

- = SINGLE FLOODLIGHT (ON CABINS)
- = 6m COLUMN WITH 4 X FLOODLIGHT
- = 6m COLUMN WITH 3 X FLOODLIGHT
- = 6m COLUMN WITH 4 X FLOODLIGHT (OPTIONAL)
- = LED BULKHEAD LIGHTS
- = LED BULKHEAD LIGHTS (OPTIONAL)
- = DUCT/TRENCH


**IMPORTANT** = All perimeter lighting to be angled away from perimeter hedgerows/retained trees to reduce external light spill.

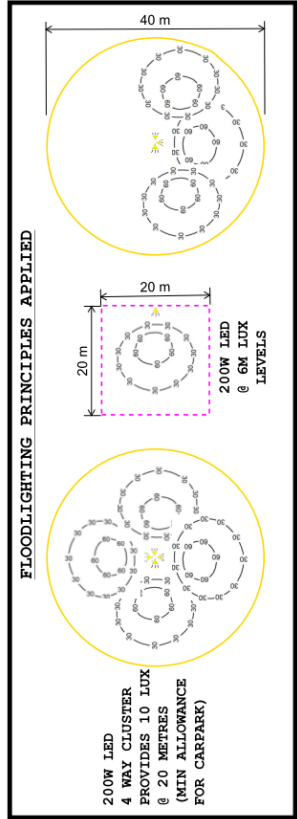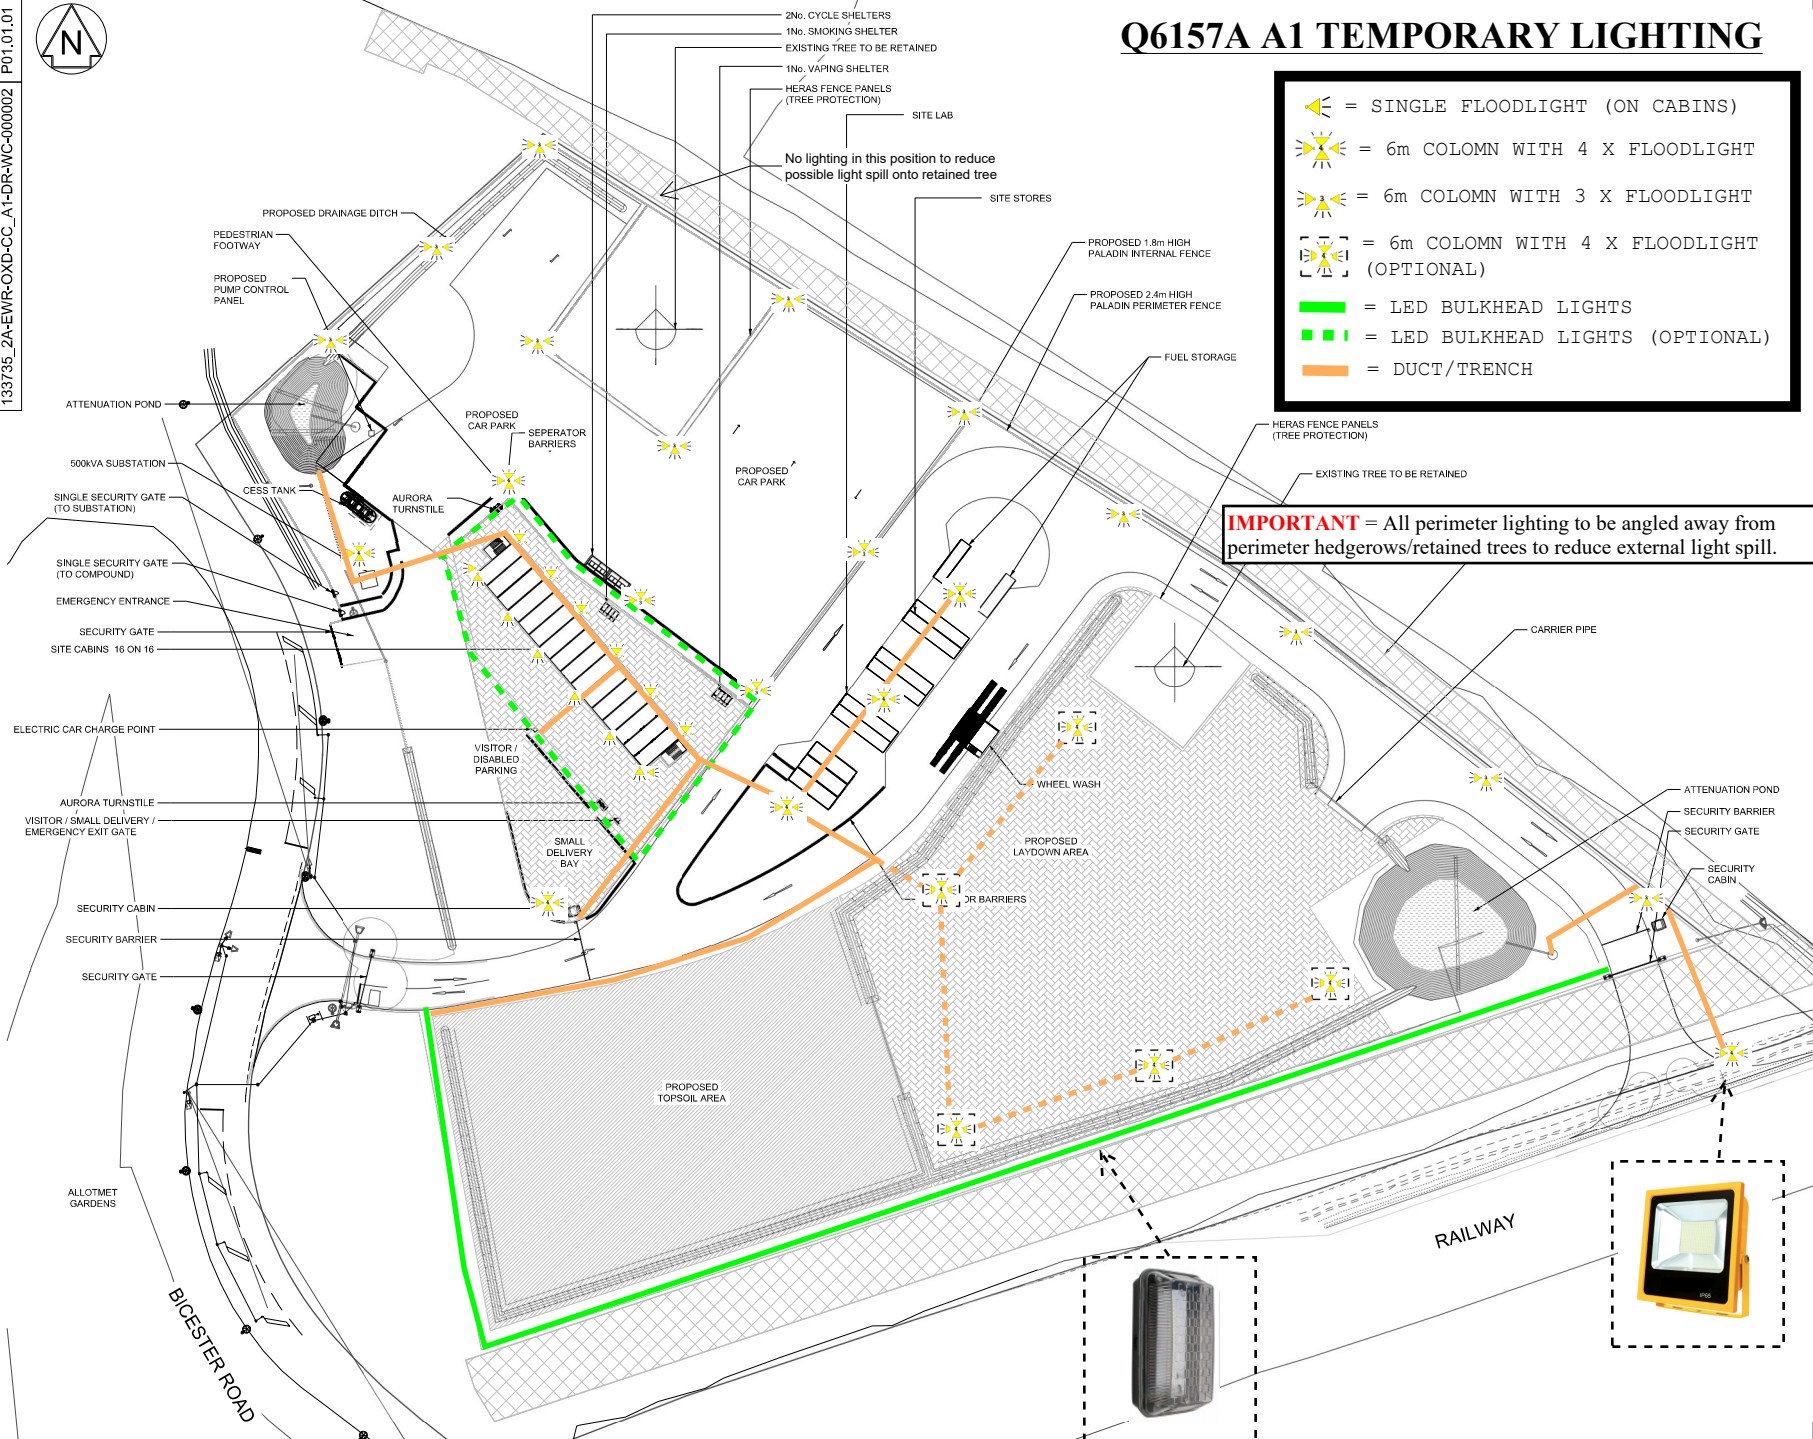

 Timer on all lights to be set to season (Summer: 06:00am - 07:00am / 18:00pm - 19:00pm and Winter: 06:00am - 08:00am / 16:00pm - 19:00pm) lights around cabins at a minimum to provide safe lighting out of hours for security team.



NO	NO/11/19	Date	Description of Revisions	Drawn	Check	Appr	Status
							S0

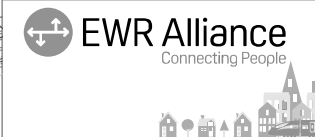

Project: East West Rail (Western Section) Phase 2  
 Drawing Title: Compound A1 Site Plan

Designed	Signed	Date
Drawn	Signed	Date
Checked	Signed	Date
Approved	Signed	Date

Scale: EWR & Project Change  
 OXD - SEDIT#PW\_PROJECT\_CHAINAG  
 Design Package Risk Classification: Normal  
 Alternative Reference: P01