


LUMINAIRE SCHEDULE

Symbol	Label	Qty	Catalog Number	Description	Lamp	Watts
	D22C	3	2 x DSX1.2.LA224.FW on 8m Column	D-Series 1 Luminaire	LED C.22000LM-4000K	416
	D36C	6	1 x DSX2.2.LA364.FW. C7 on 8m Column	D-Series 2 Luminaire C7	LED C.36000LM-4000K	330
	D36W	6	DSX2.2.LA364.FW. C9 on 5 degree tilt Wall Bracket at 10m AFFL.	D-Series 2 Luminaire C9	LED C.36000LM-4000K	330
	W01	3	DEW.LA014.NR.C GL.C9 at 3m AFFL	Denver Elite Wall C9	LED C.1000LM - 4000K	12
	D22W	6	DSX1.2.LA224.FW. C9 on 5 degree tilt Wall Bracket at 4m AFFL.	D-Series 1 Luminaire C9	LED C.22000LM-4000K	208
	D22W	4	DSX1.2.LA224.FW. C9 on 5 degree tilt Wall Bracket at 10m AFFL.	D-Series 1 Luminaire C4	LED C.22000LM-4000K	208

STATISTICS

Description	Symbol	Avg	Max	Min	Min/Avg
Path	+	26 lux	42 lux	7 lux	0.27
SPILL	+	3 lux	37 lux	0 lux	0.00
Unit 1B - Access Road	+	19 lux	44 lux	14 lux	0.74
Unit 1B - Car Park	+	28 lux	60 lux	7 lux	0.25
Unit 1B - Dock Doors	+	153 lux	199 lux	115 lux	0.75
Unit 1B - Service Yard	+	61 lux	197 lux	19 lux	0.31

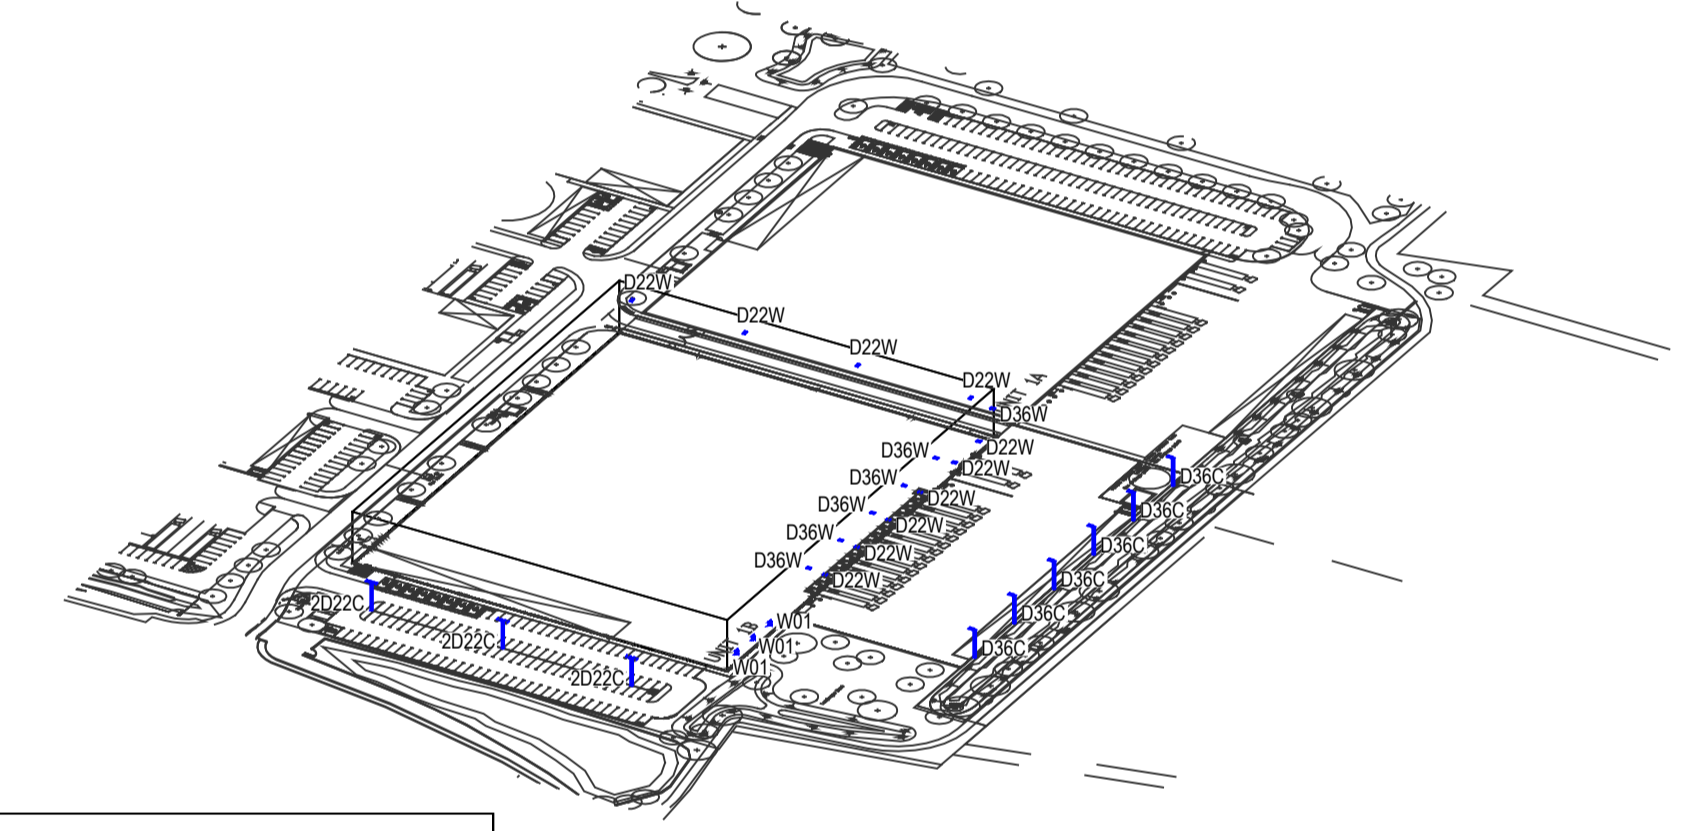

LUMINAIRE LOCATIONS

No.	Label	MH	Tilt
1	D22W	10.0	5.0
2	D22W	10.0	5.0
3	D22W	10.0	5.0
4	D22W	10.0	5.0
5	D22W	4.0	5.0
6	W01	3.0	0.0
7	W01	3.0	0.0
8	W01	3.0	0.0
9	D22C	8.0	0.0
10	D22C	8.0	0.0
11	D22C	8.0	0.0
12	D36C	8.0	0.0
13	D36W	10.0	0.0
14	D36W	10.0	0.0
15	D36W	10.0	0.0
16	D22W	4.0	5.0
17	D36W	10.0	0.0
18	D22W	4.0	5.0
19	D36W	10.0	0.0
20	D22W	4.0	5.0
21	D36W	10.0	0.0
22	D22W	4.0	5.0
23	D22W	4.0	5.0
24	D36C	8.0	0.0
25	D36C	8.0	0.0
26	D36C	8.0	0.0
27	D36C	8.0	0.0
28	D36C	8.0	0.0

© Engineering Services Consultancy Limited.
 This drawing is copyright and must not be reproduced in part or whole without written consent.
 Contractors must verify all dimensions on site before commencing works.
 All works shall be coordinated with all other trades.
 REGISTERED FIRM
 ISO 9001

RESIDUAL RISK REGISTER

NO.	DESCRIPTION OF HAZARD	CONTROL MEASURES	ACTION BY
1	UNKNOWN BURIED SERVICES AND SERVICES IDENTIFIED IN WRONG LOCATION.	IDENTIFICATION OF EXISTING UNDERGROUND SERVICES USING UTILITY RECORD DRAWINGS AND CAT SCANNING OF GROUND. CAREFUL EXCAVATION USING SLOT TRENCHES AND CAT SCANNING OF GROUND.	CONTRACTOR

Rev.	Date	Details	Initials
P1	15.07.19	Issued for planning	CP

Engineering Services Consultancy Ltd
 19 Ludgate Hill
 Birmingham
 B3 1DW
 T: 0121 214 8998
 F: 0121 214 8999
 W: www.escuk.com



Project
Plot 1B Link 9 Skimmingdish

Drawing Title
External Lighting Layout

PURPOSE: PLANNING

Drawn	Engineer	Approved
DM	CP	CP
Project No. 1500	Date Jul 2019	Scale @ A1 1:500
Drawing No. 1500-ESC-00-ZZ-DR-E-2100	Revision P1	