


DO NOT SCALE


This drawing is the property of Digi Design Co Architecture Ltd. Copyright is reserved by them and the drawing is issued on the condition that it is not used, copied, reproduced, retained or disclosed either wholly or in part, by or to any unauthorised persons, without previous consent in writing of Digi Design Co Architecture Ltd.

PLEASE CHECK ALL DIMENSIONS ON SITE PRIOR TO COMMENCING PROJECT


NOTES

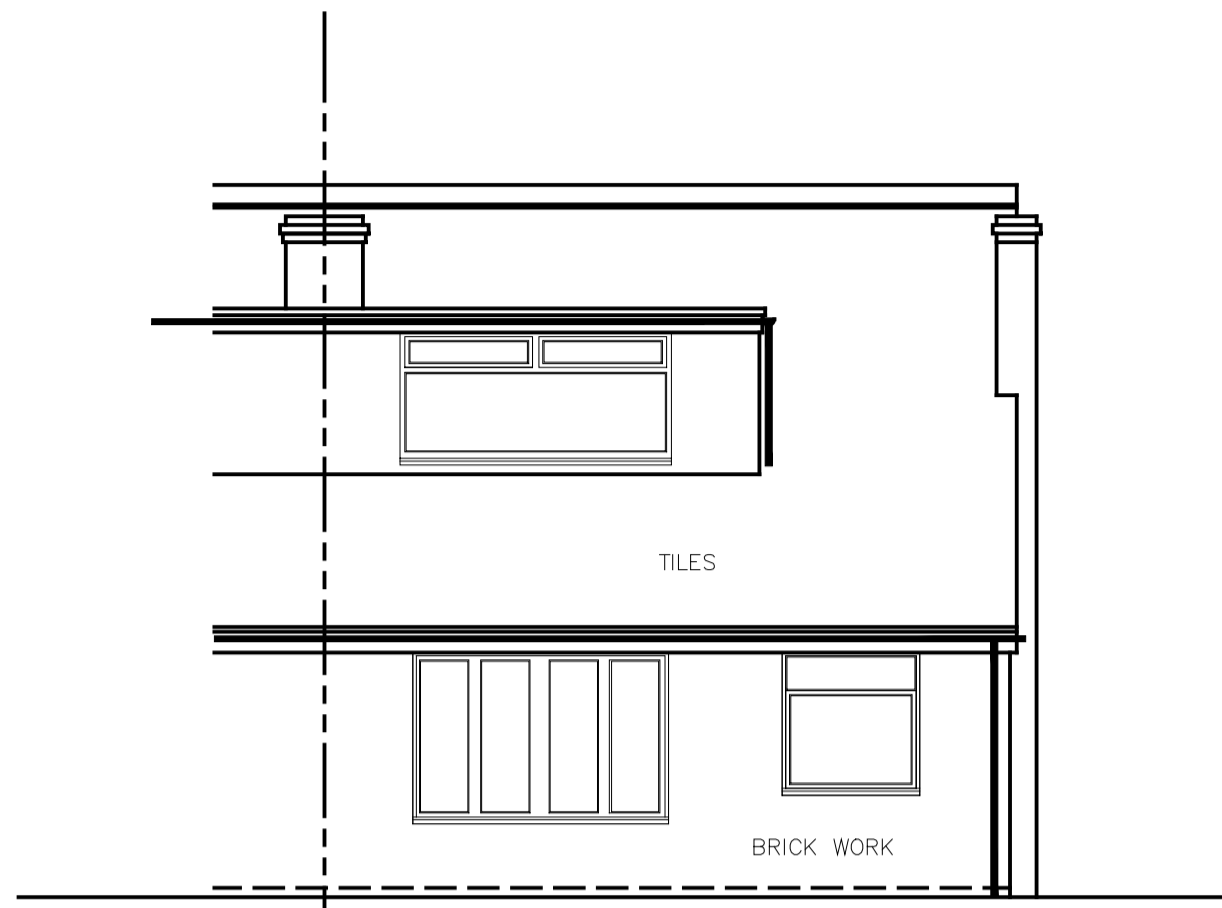


South Elevation Scale 1:100
0.0m 1.0m 2.0m 3.0m 4.0m 5.0m

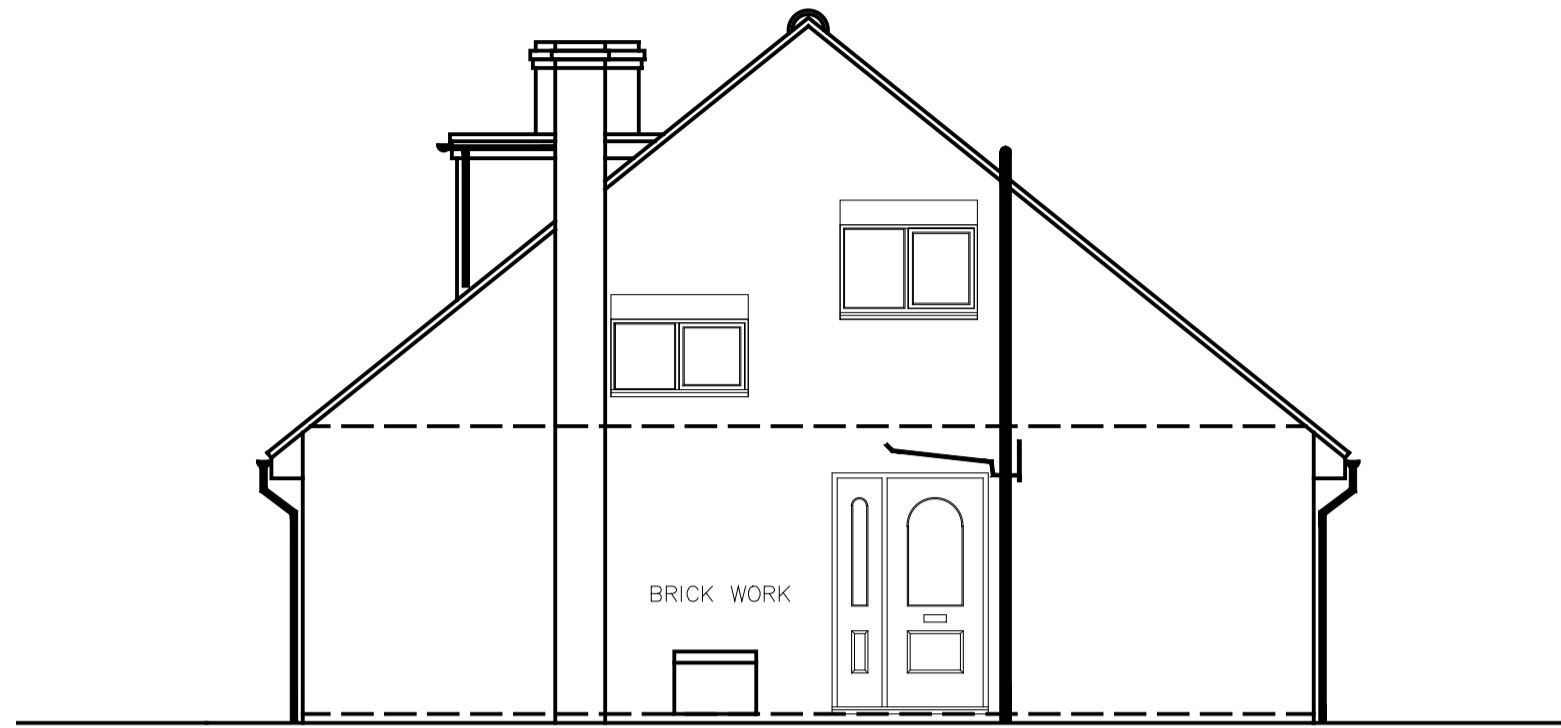


East Elevation Scale 1:100
0.0m 1.0m 2.0m 3.0m 4.0m 5.0m

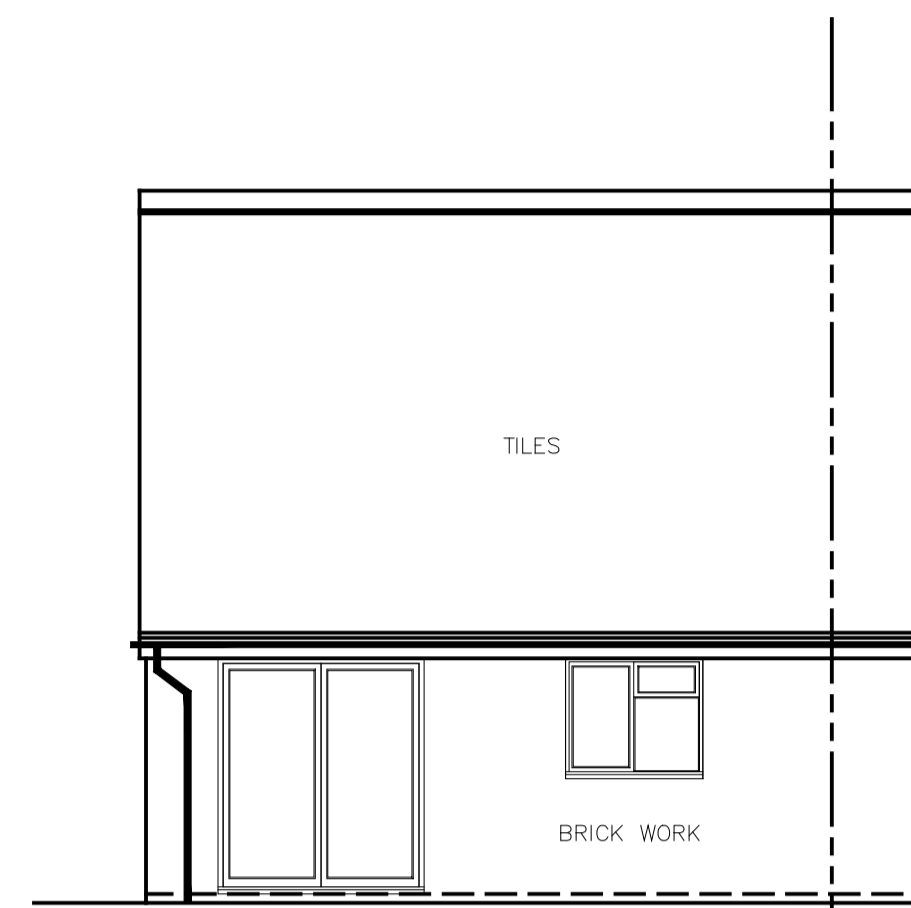


North Elevation Scale 1:100
0.0m 1.0m 2.0m 3.0m 4.0m 5.0m

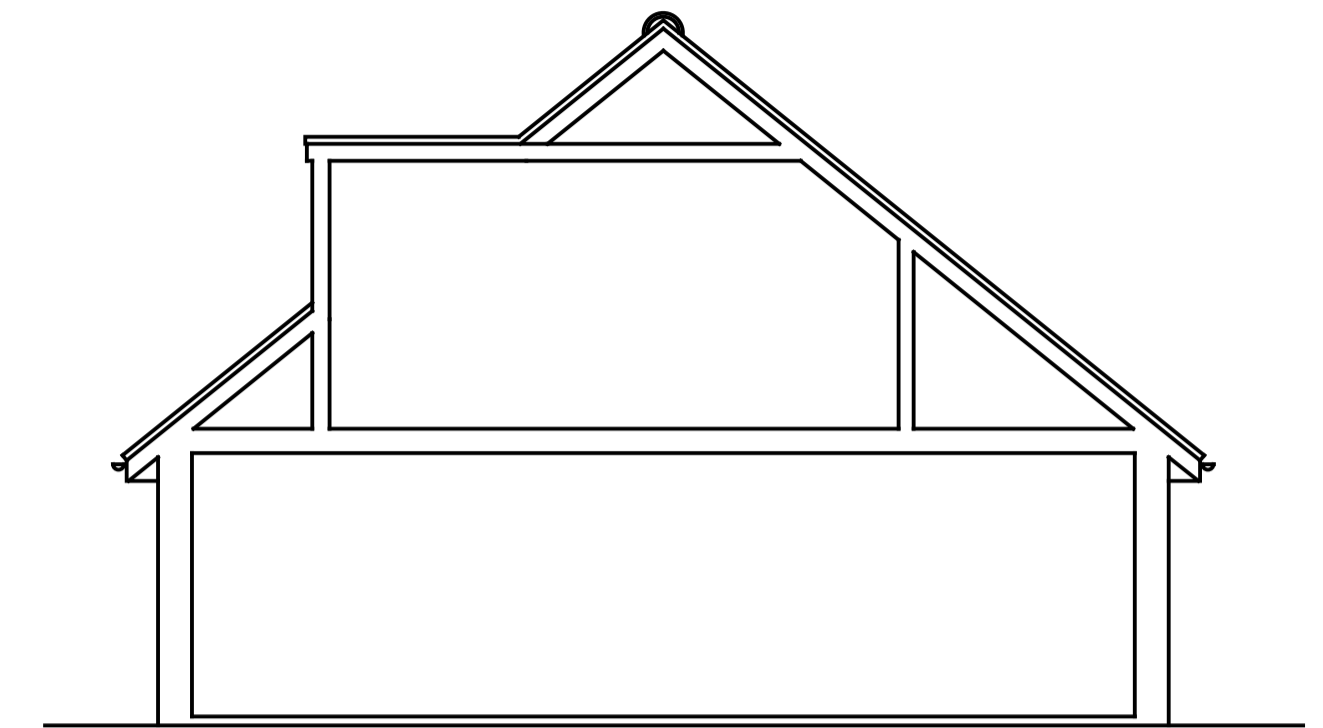

Internal Elevation Scale 1:100
0.0m 1.0m 2.0m 3.0m 4.0m 5.0m

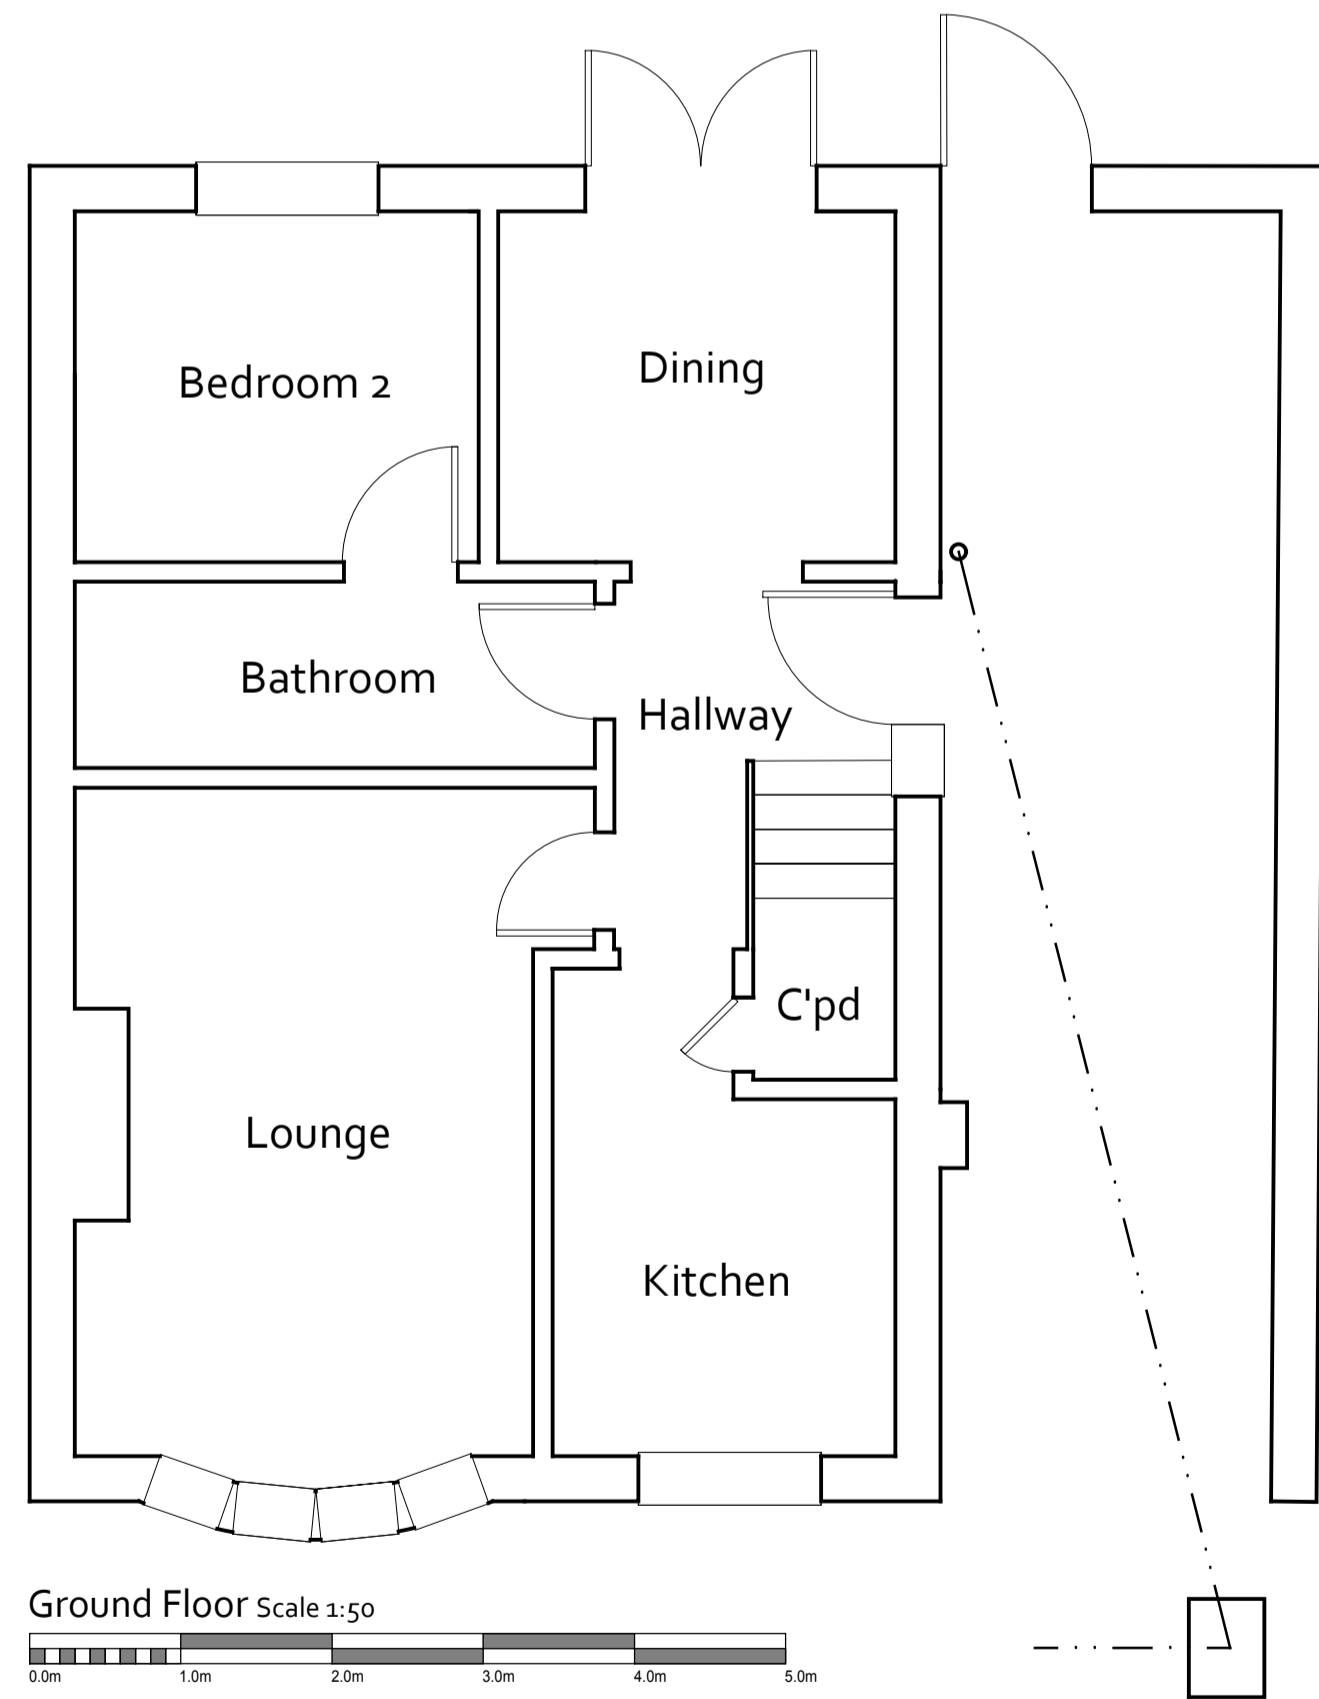


Ground Floor Scale 1:50
0.0m 1.0m 2.0m 3.0m 4.0m 5.0m

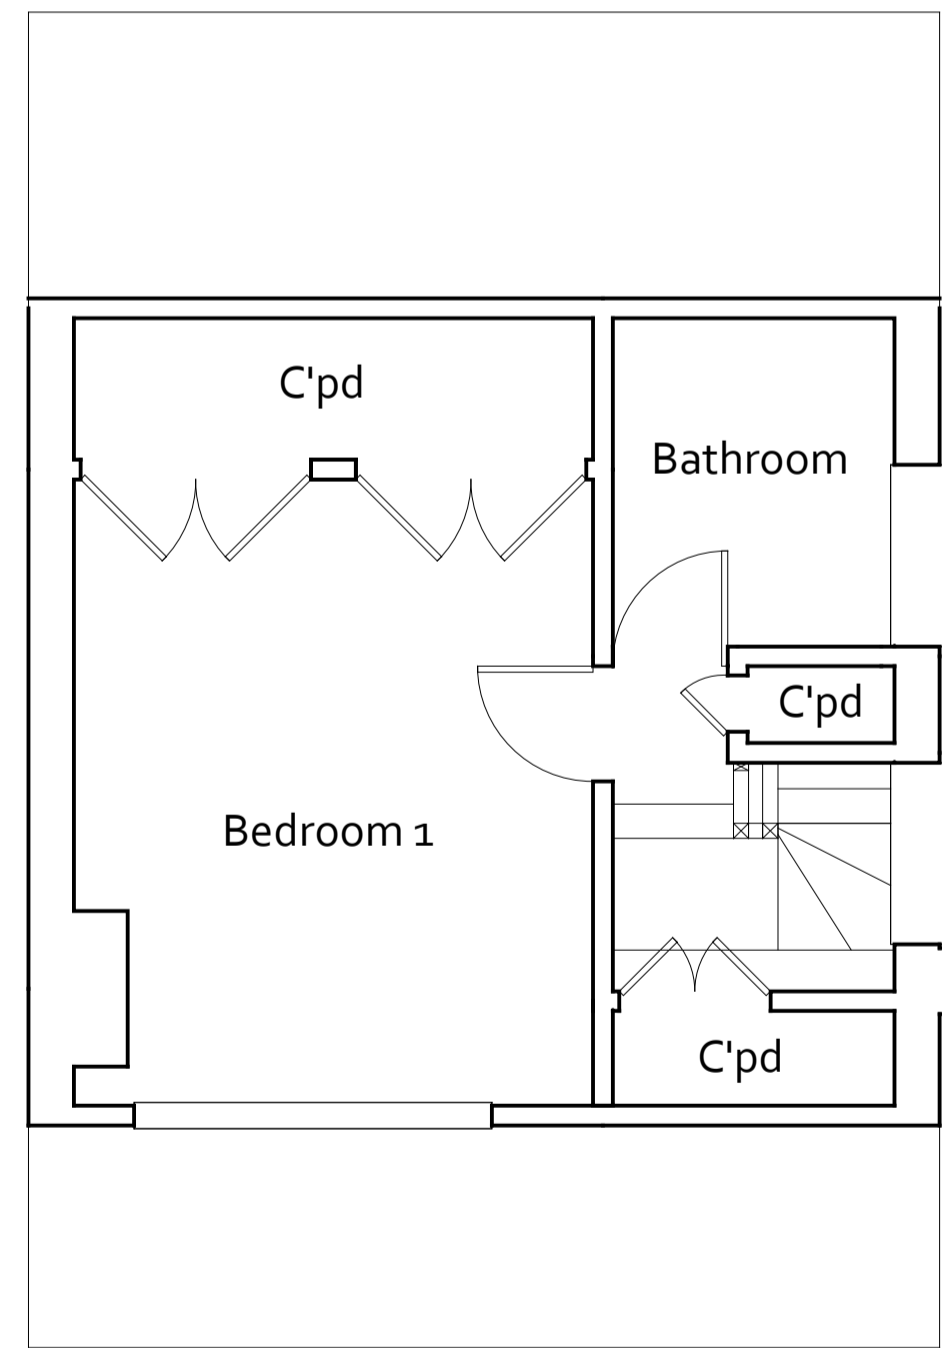

First Floor Scale 1:50
0.0m 1.0m 2.0m 3.0m 4.0m 5.0m



Location Plan Scale 1:1250
0.0m 10.0m 20.0m 30.0m 40.0m 50.0m

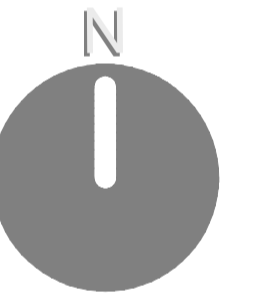

Revisions			
Client			
John Bonas			
Project			
11 Sefton Place			
Bodicote			
Banbury			
Oxon OX15 4AT			
Drawing			
Survey			
Plans, Elevations and Section			
Project Ref	Date	Drawing Number	Revision
DDC-026-John Bonas	August 2019		
Scale	Sheet Size	001 -	
A5 SHOWN	A1		
Drawn	Checked		
JRF	AIL		

DIGI·DESIGN·CO
Architecture Ltd
 Cherwell Business Village F161,
 Southam Road, Banbury, Oxon. OX16 2SP.
 T: +44 (0)1295 267617 M: +44 (0)7748 402723
<http://www.digidesignco.com>

