
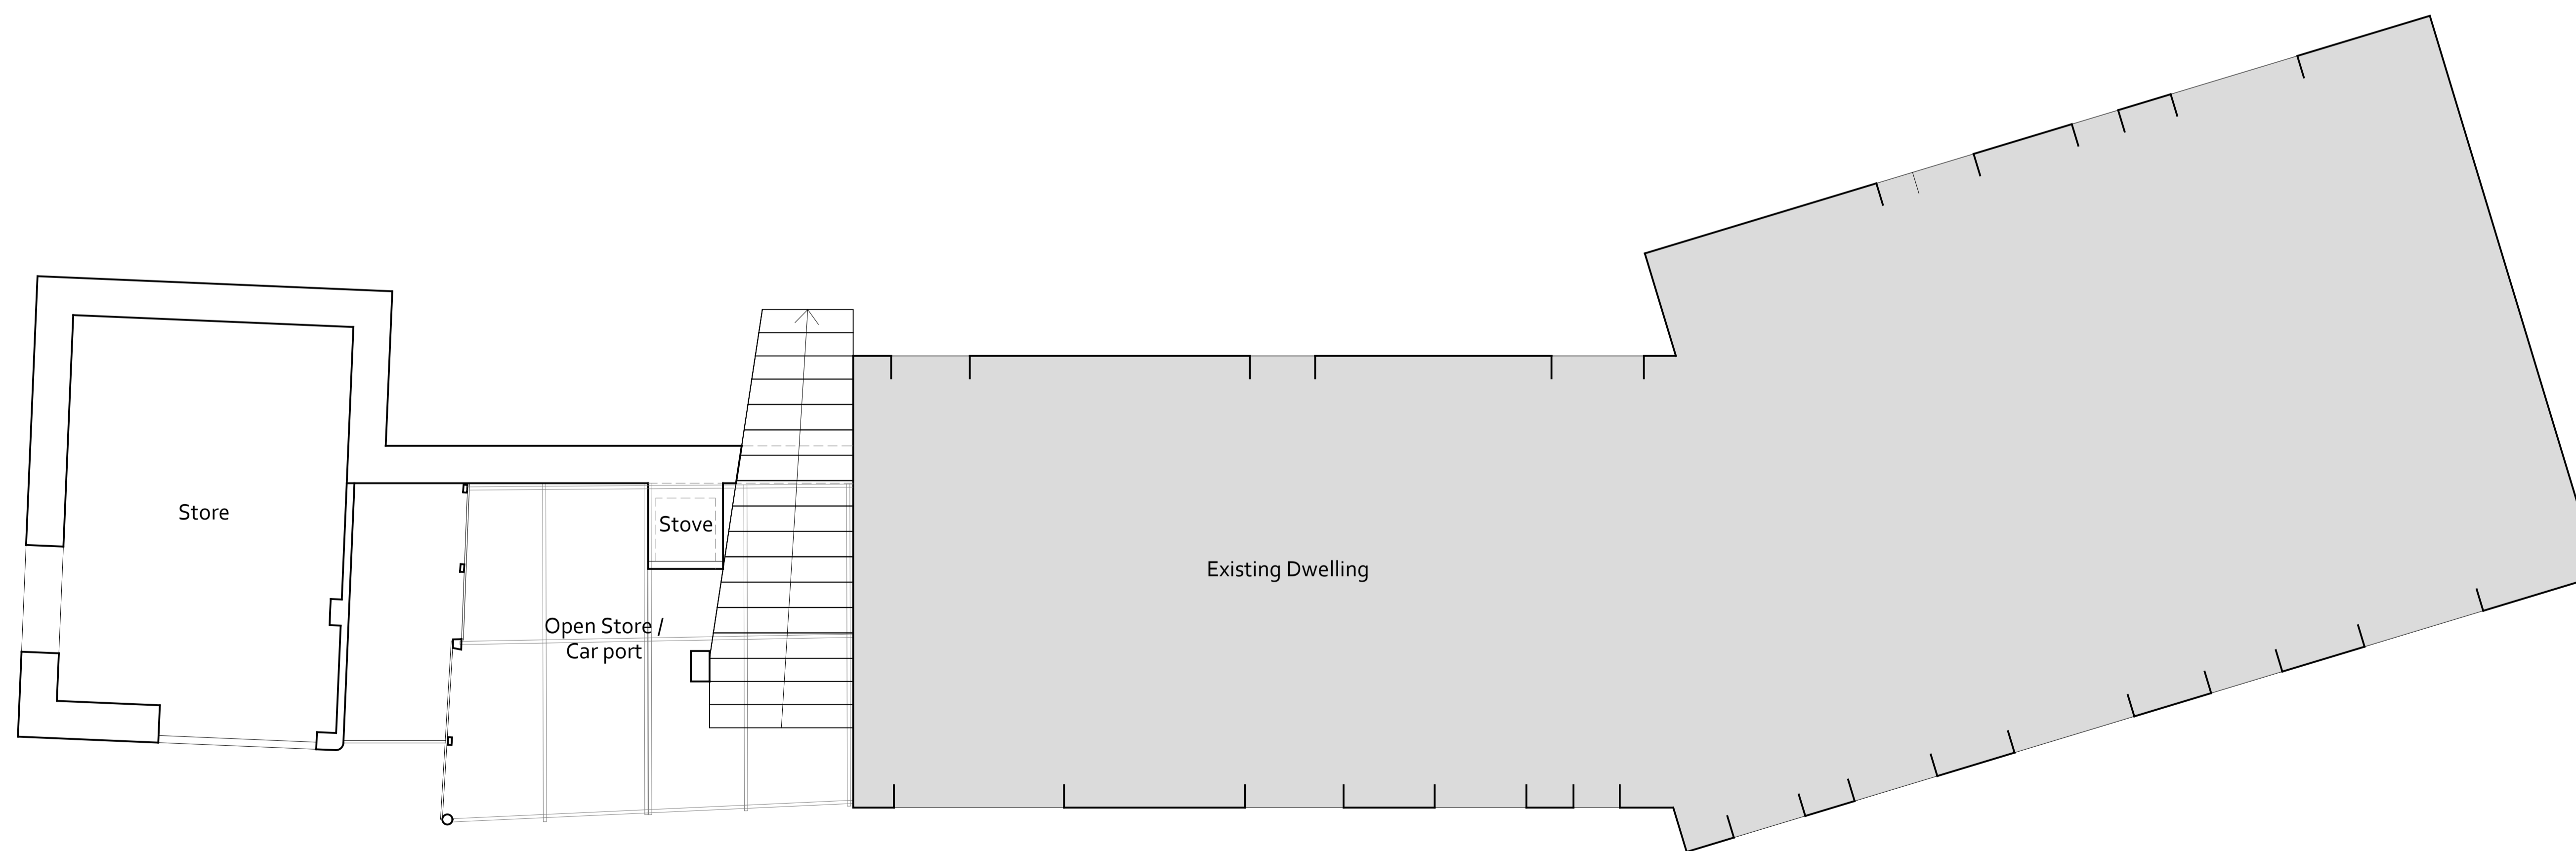
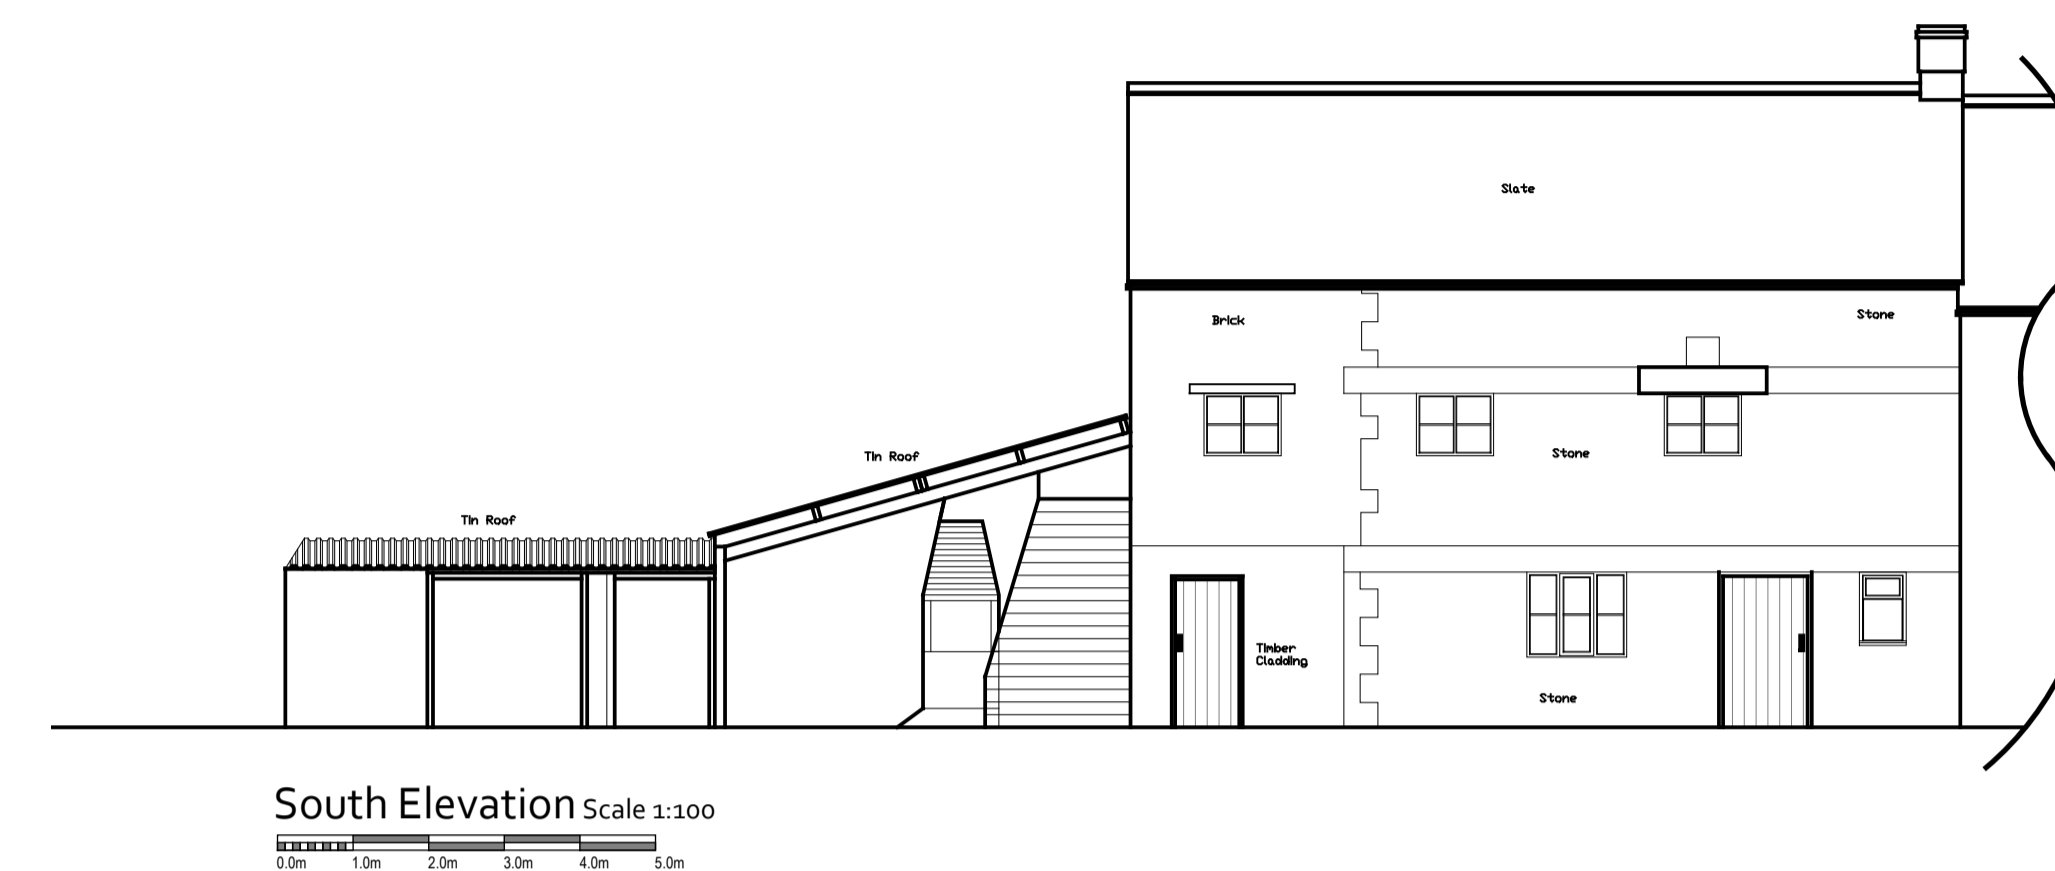
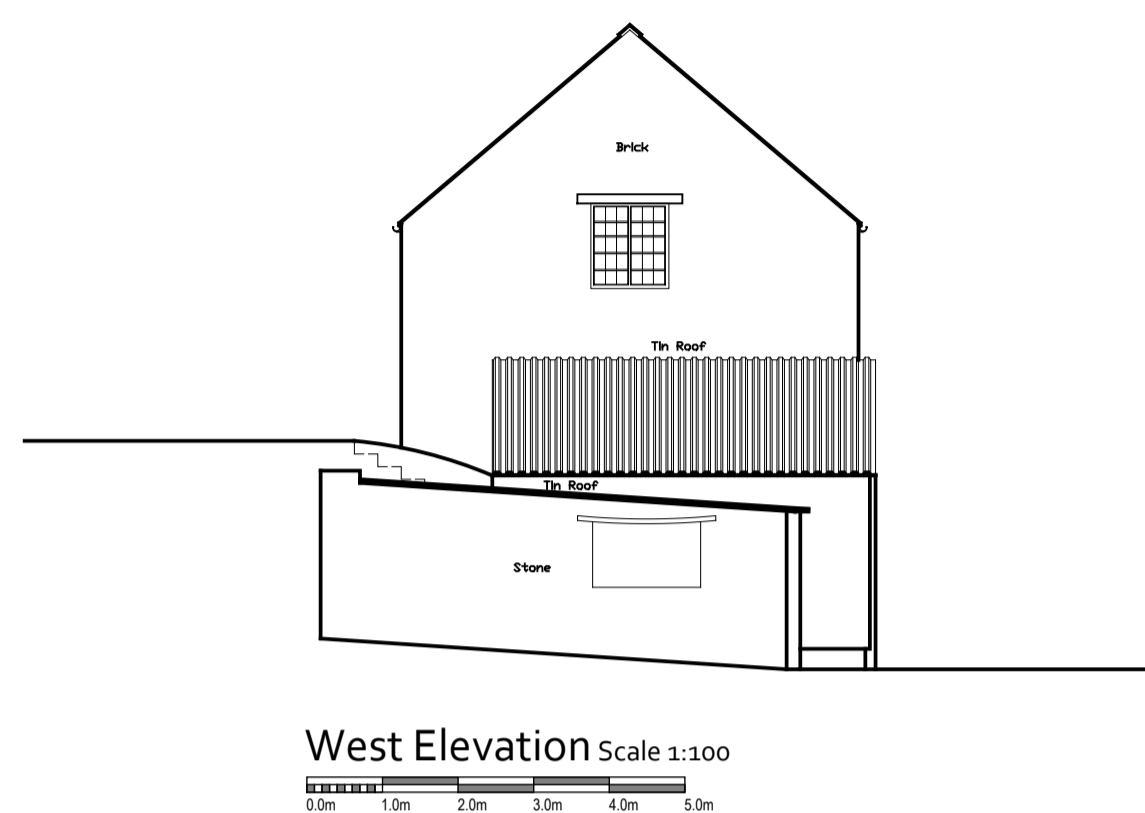


DO NOT SCALE

This drawing is the property of Digi Design Co Architecture Ltd. Copyright is reserved by them and the drawing is issued on the condition that it is not used, copied, reproduced, retained or disclosed either wholly or in part, by or to any unauthorised persons, without previous consent in writing of Digi Design Co Architecture Ltd.

PLEASE CHECK ALL DIMENSIONS ON SITE PRIOR TO COMMENCING PROJECT

NOTES

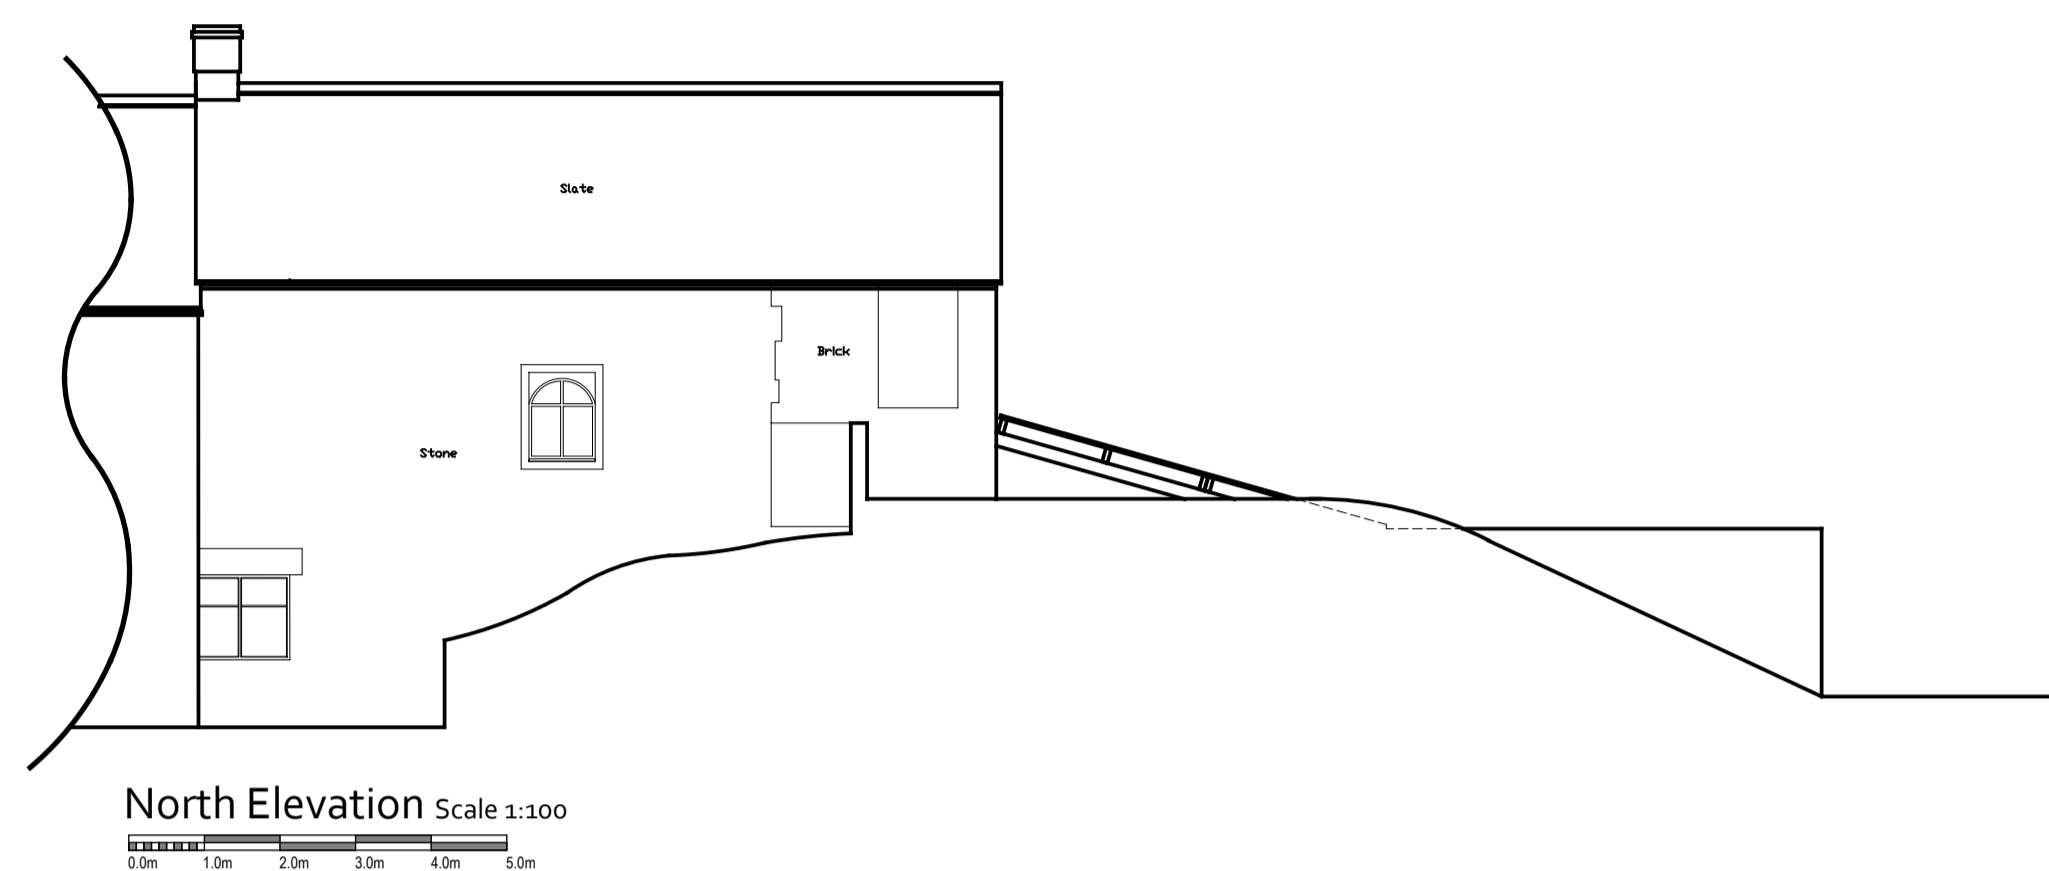

Revisions			
Client			
Mr W Sabin			
Project			
Temple Mill, Sibford Ferris, Banbury, Oxon. OX15 5DA.			
Drawing			
Survey Plan and Elevations			
Project Ref	Date	Drawing Number	Revision
DDC-2018-498	January 2018		
Scale	Sheet Size	001	-
AS SHOWN	A4		



Cherwell Business Village F161,  
Southam Road, Banbury, Oxon. OX16 2SP.  
T: +44 (0)1295 267637 M: +44 (0)7748 402723

<http://www.digidesignco.com>

