




Antenna Aperture ID	Proposed 4G/5G Bearing	Operator: Shared/ EE/H3G
A1	60°	H3G
A2	60°	EE/H3G
B1	180°	H3G
B2	180°	EE/H3G
C1	300°	H3G
C2	300°	EE/H3G

NOTES:

- ALL DIMENSIONS IN MM UNLESS OTHERWISE NOTED.

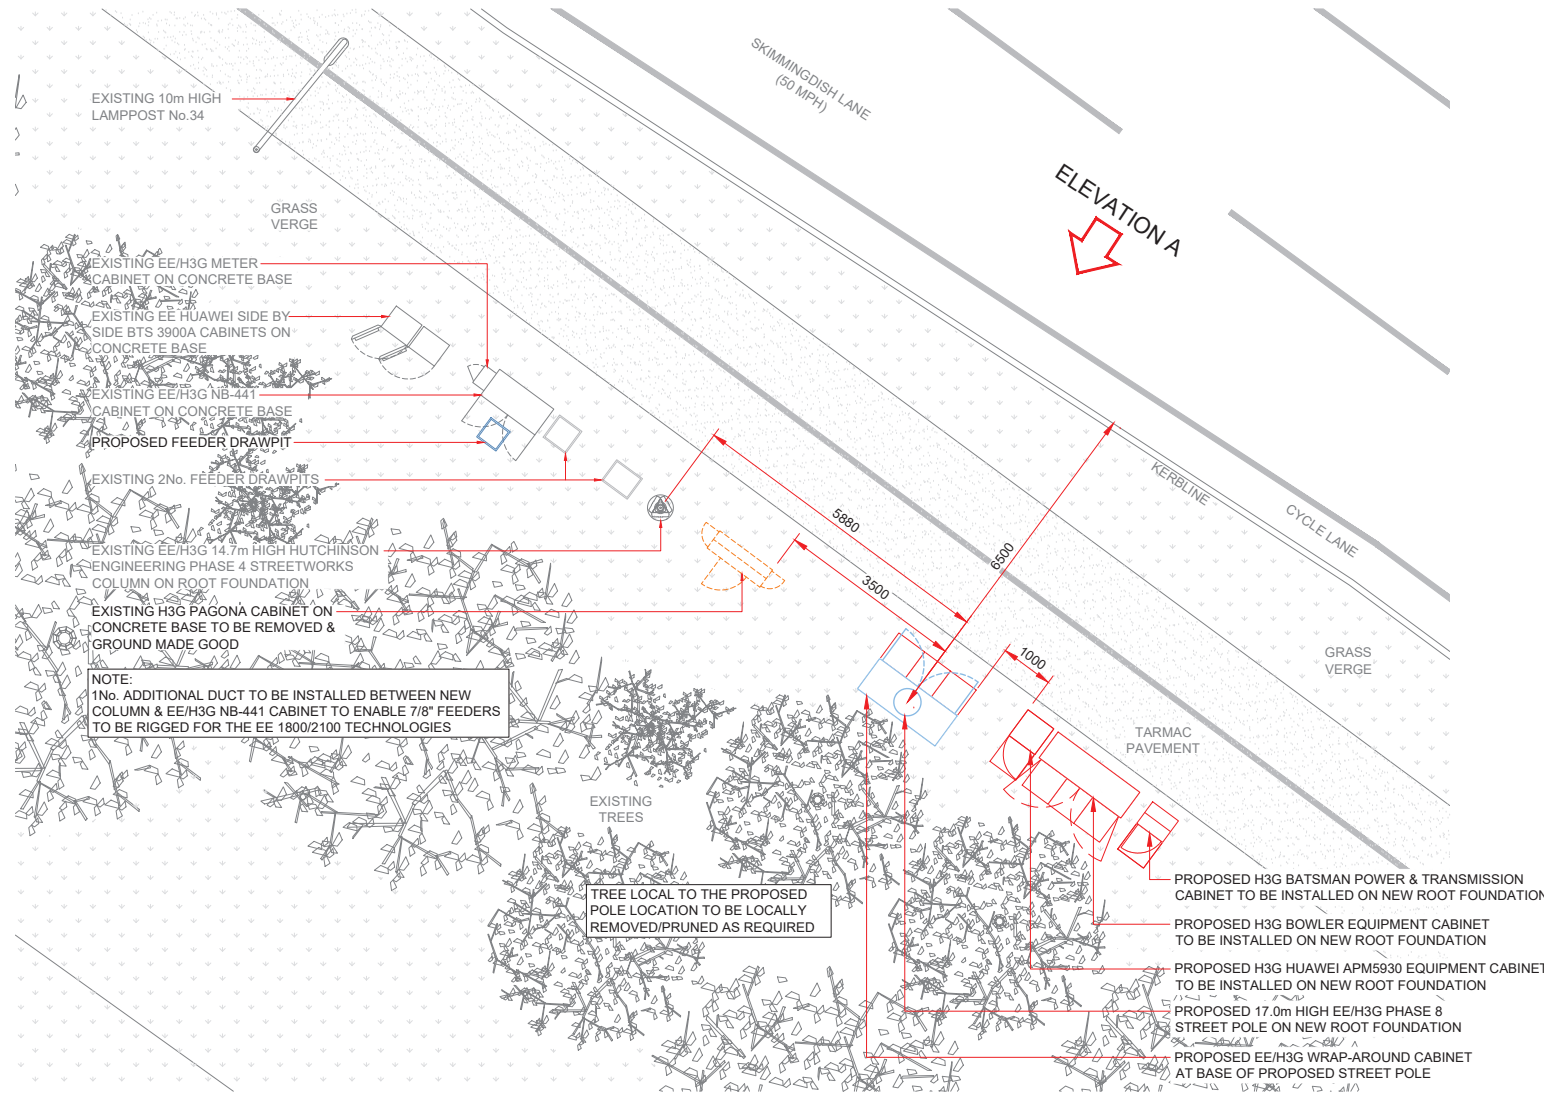

NOTE:
1No. ADDITIONAL DUCT TO BE INSTALLED BETWEEN NEW COLUMN & EE/H3G NB-441 CABINET TO ENABLE 7/8" FEEDERS TO BE RIGGED FOR THE EE 1800/2100 TECHNOLOGIES

TREE LOCAL TO THE PROPOSED POLE LOCATION TO BE LOCALLY REMOVED/PRUNED AS REQUIRED

- PROPOSED H3G BATSMAN POWER & TRANSMISSION CABINET TO BE INSTALLED ON NEW ROOT FOUNDATION
- PROPOSED H3G BOWLER EQUIPMENT CABINET TO BE INSTALLED ON NEW ROOT FOUNDATION
- PROPOSED H3G HUAWEI APM5930 EQUIPMENT CABINET TO BE INSTALLED ON NEW ROOT FOUNDATION
- PROPOSED 17.0m HIGH EE/H3G PHASE 8 STREET POLE ON NEW ROOT FOUNDATION
- PROPOSED EE/H3G WRAP-AROUND CABINET AT BASE OF PROPOSED STREET POLE

PROPOSED SITE PLAN



Master	MBNL / EE / H3G	Project	Purpose of Issue	Issue
M001	MBNL	H3G UNILATERAL SW	Planning	B

Date:	28/04/2020	Revision / Upgrade Description:	Column & Cabinet specification and layout amended	
Drawn:	TH	Checked:	JTP	
Approved:	K.Winsland			

Master	MBNL / EE / H3G	Project	Purpose of Issue	Issue
M001	MBNL	H3G UNILATERAL SW	Planning	A

Date:	01/04/2020	Revision / Upgrade Description:	First Issue
Drawn:	TH	Checked:	JTP
Approved:	K.Winsland		



Hutchison 3G UK Limited
Sixth Floor, Thames Tower
Manchester, M6 8 5TH
Tel: 01628 705 000
Fax: 01628 705 001
H3G Base Station Information line: 045 6043001
Available from Monday to Friday

Hatfield Business Park
Hatfield
Hertfordshire
AL10 9BW
Tel: 01707 315000
Fax: 01707 319001

MBNL Mobile Broadband Network Limited
Sixth Floor, Thames Tower, Station Road, Reading, RG1 1LX

Design Consultant & Principal Contractor:

mono Mono Consultants Limited
Cutzean House,
36 Renfield Street, Glasgow,
G2 1LU
t. 44 (0) 141 566 6660
f. 44 (0) 141 566 6661
www.monoconsultants.com

Site Name: SKIMMINGDISH LANE - S/W

Site ID: 1107137

Address: SKIMMINGDISH LANE, BICESTER, OXFORD, OX26 4FU

Title: 215 PROPOSED SITE PLAN

Project: H3G UNILATERAL SW

Purpose of Issue: PLANNING

EE Cell ID:	25181	MBNL Cell ID:	CWL045	3UK Cell ID:	OX0056
-------------	-------	---------------	--------	--------------	--------

Master Drawing No:	1107137_CWL045_25181_OX0056_M001	Issue:	B
--------------------	----------------------------------	--------	---