
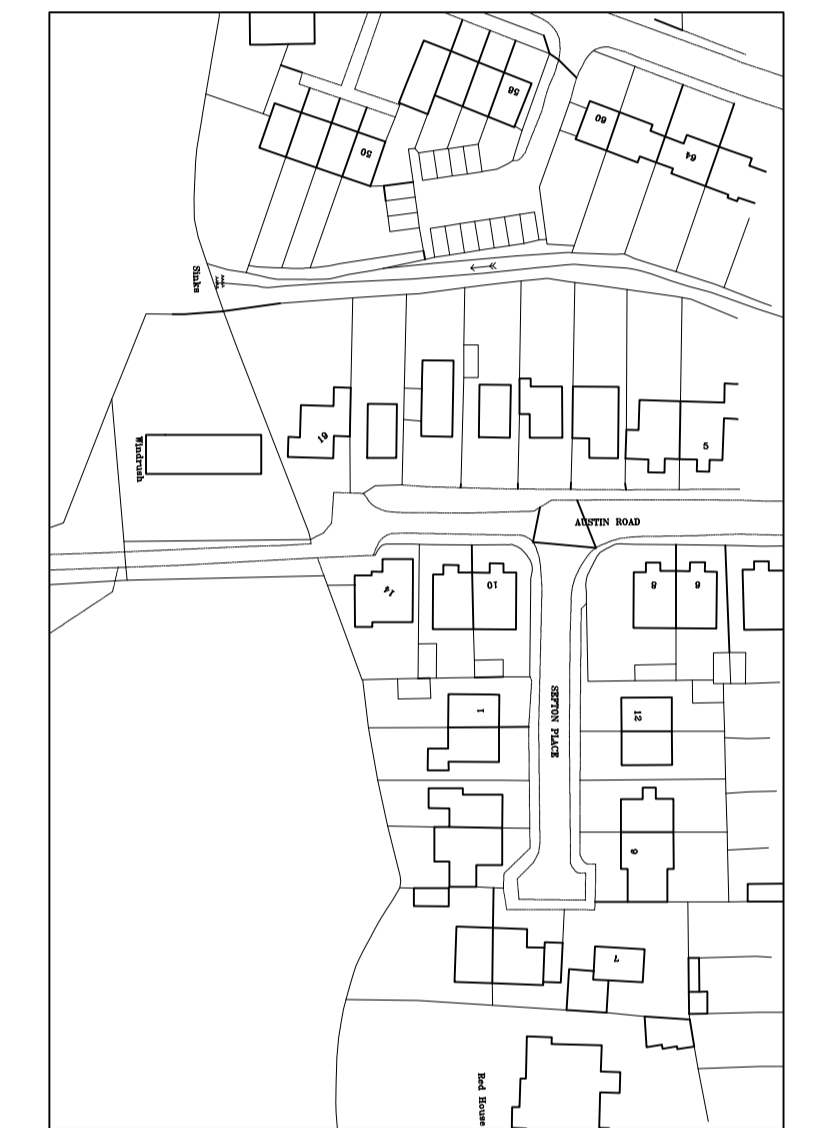
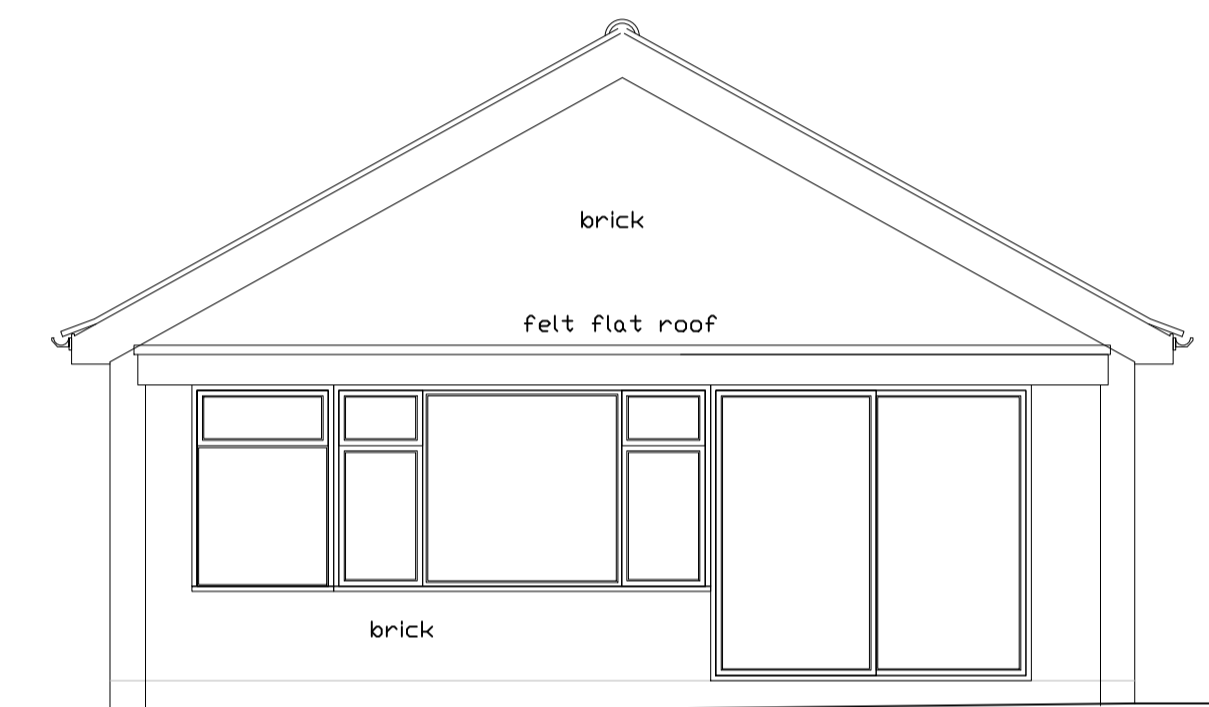
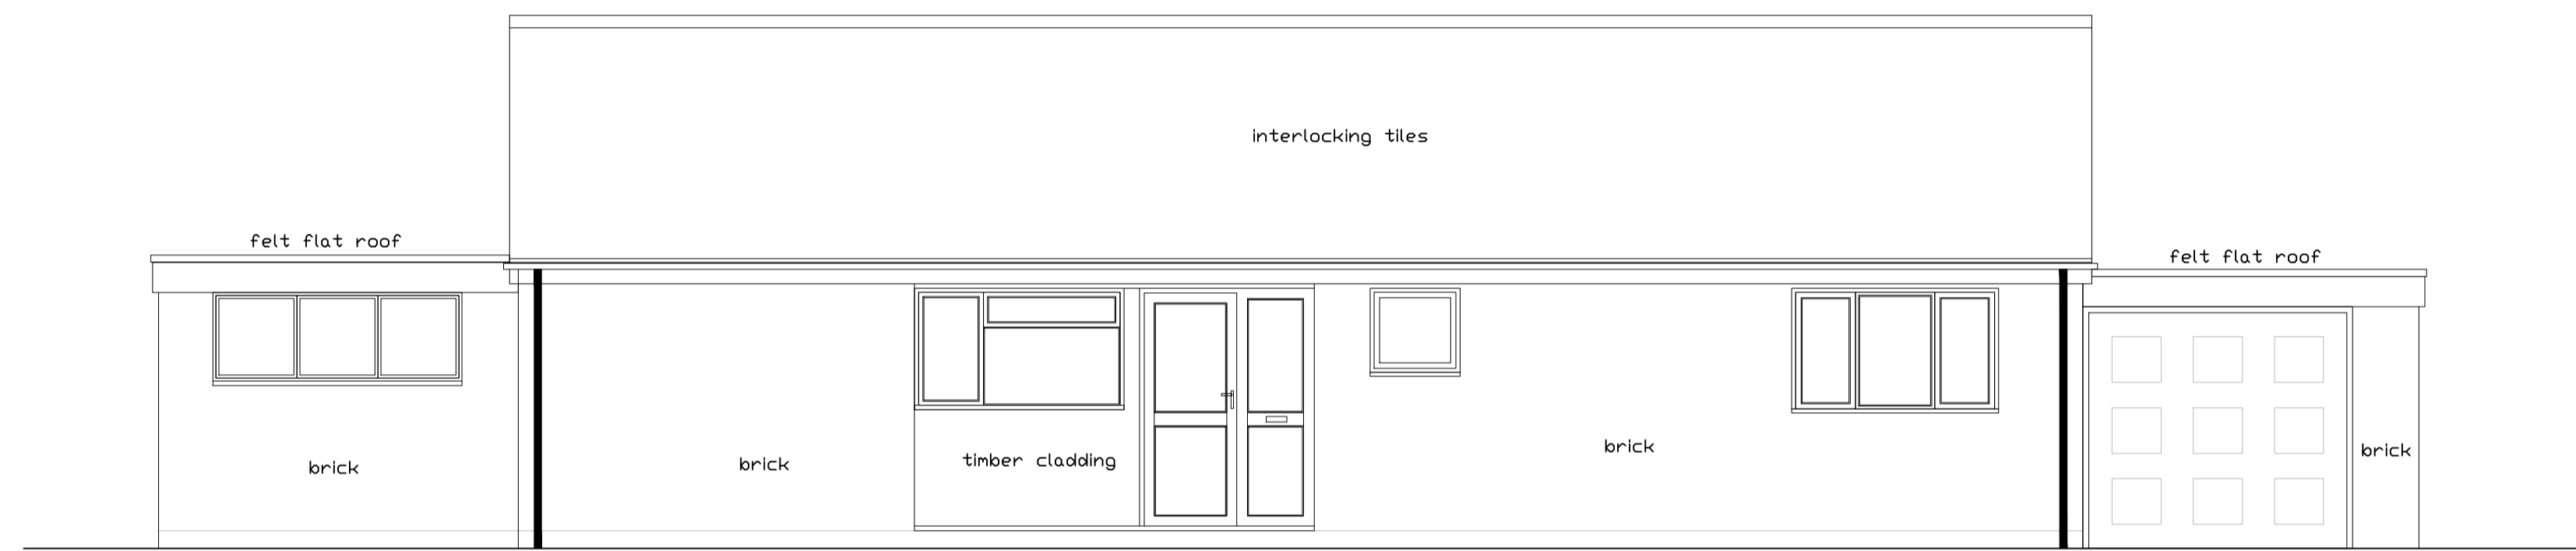
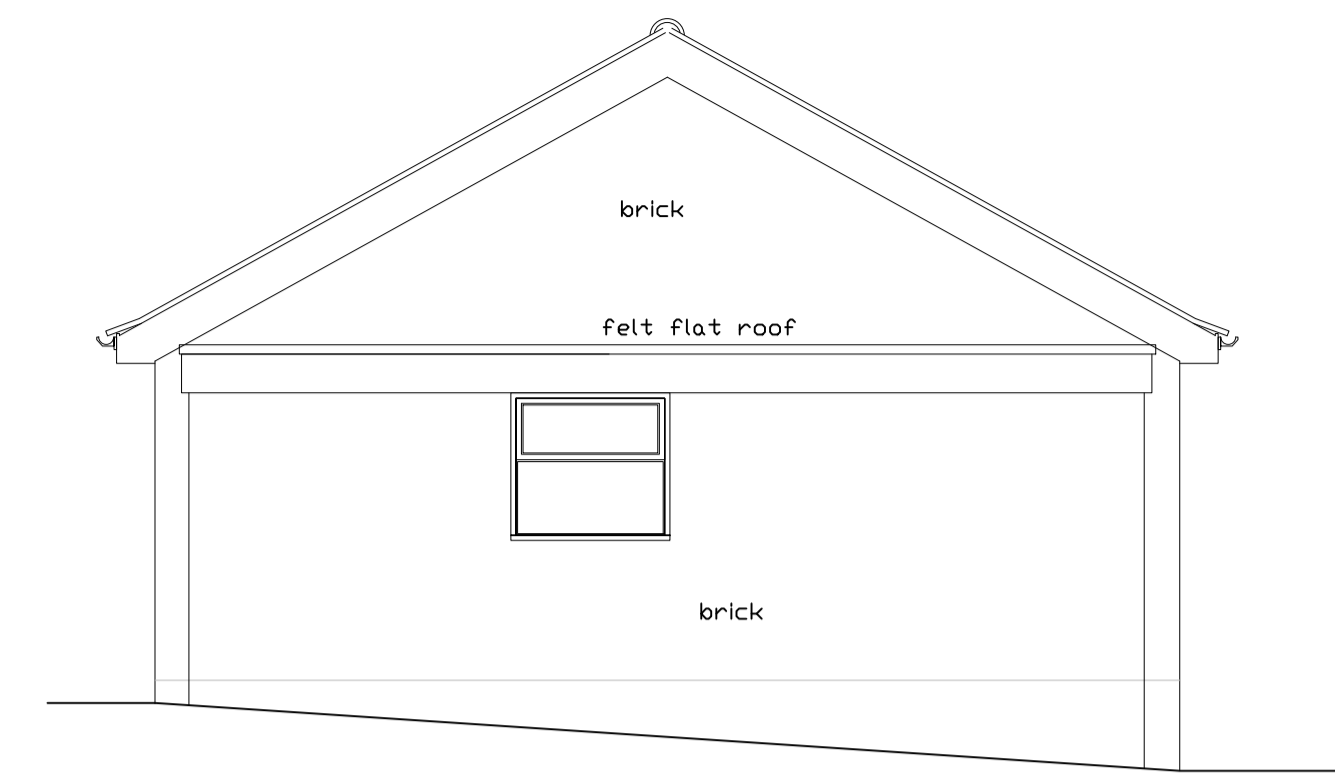


**DO NOT SCALE**


This drawing is the property of Digi Design Co Architecture Ltd. Copyright is reserved by them and the drawing is issued on the condition that it is not used, copied, reproduced, retained or disclosed either wholly or in part, by or to any unauthorised persons, without previous consent in writing of Digi Design Co Architecture Ltd.

PLEASE CHECK ALL DIMENSIONS ON SITE PRIOR TO COMMENCING PROJECT


**NOTES**

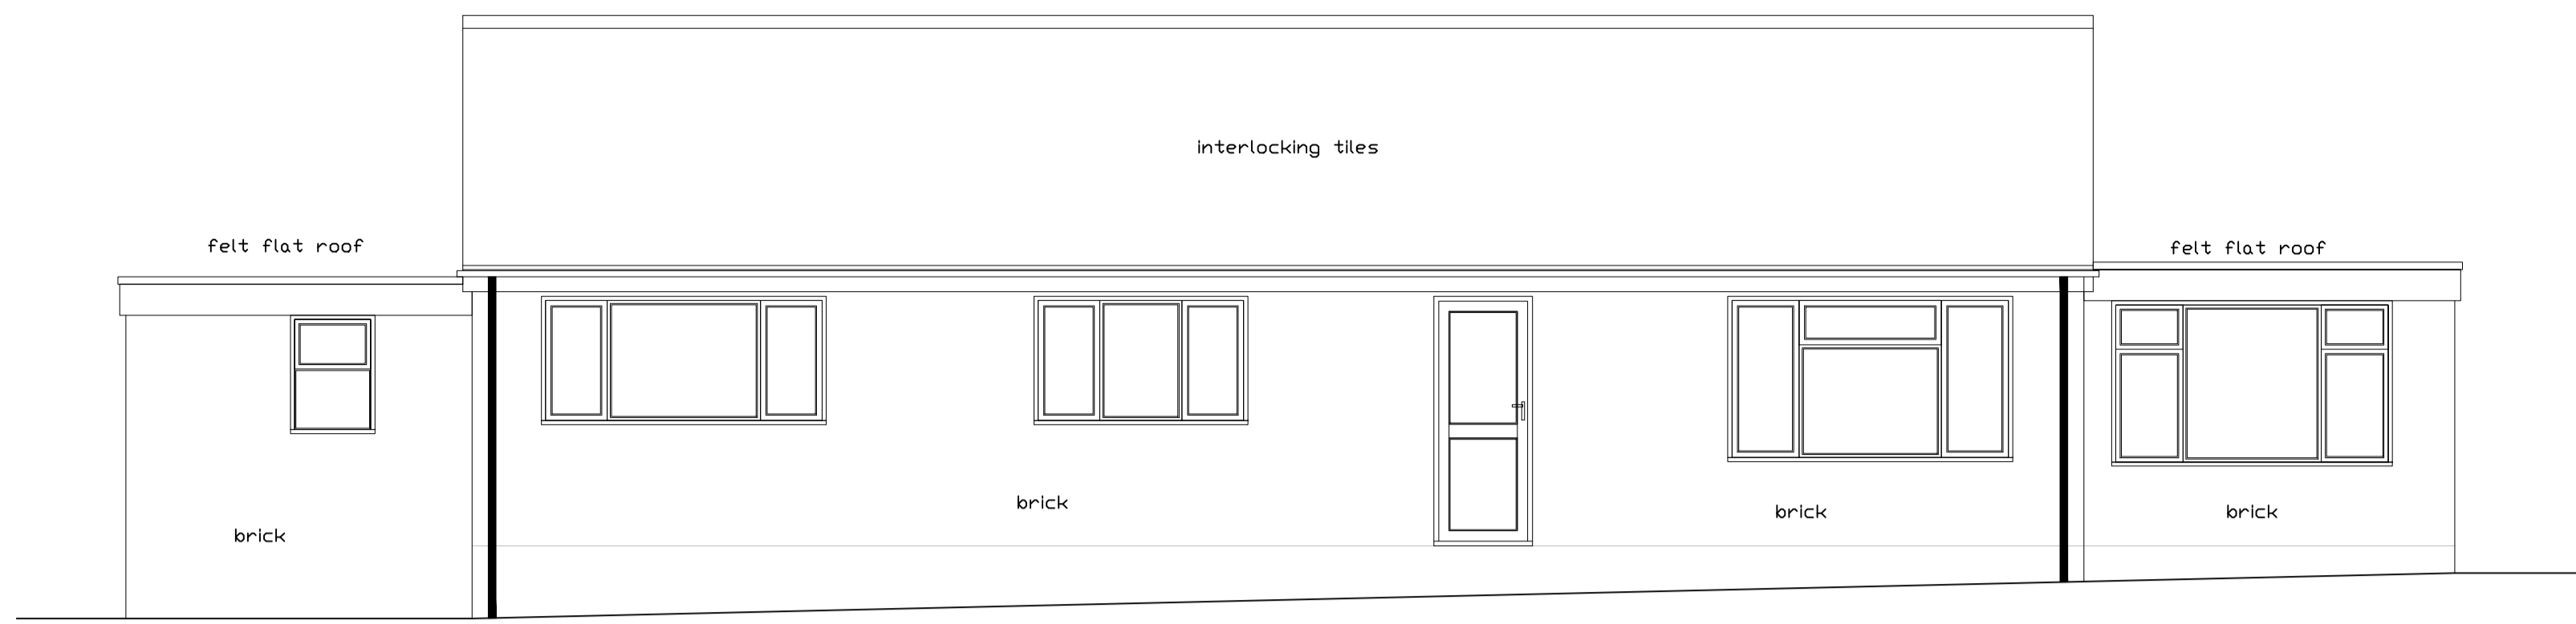


**Location Plan** Scale 1:1250  
0.0m 1.0m 2.0m 3.0m 4.0m 5.0m

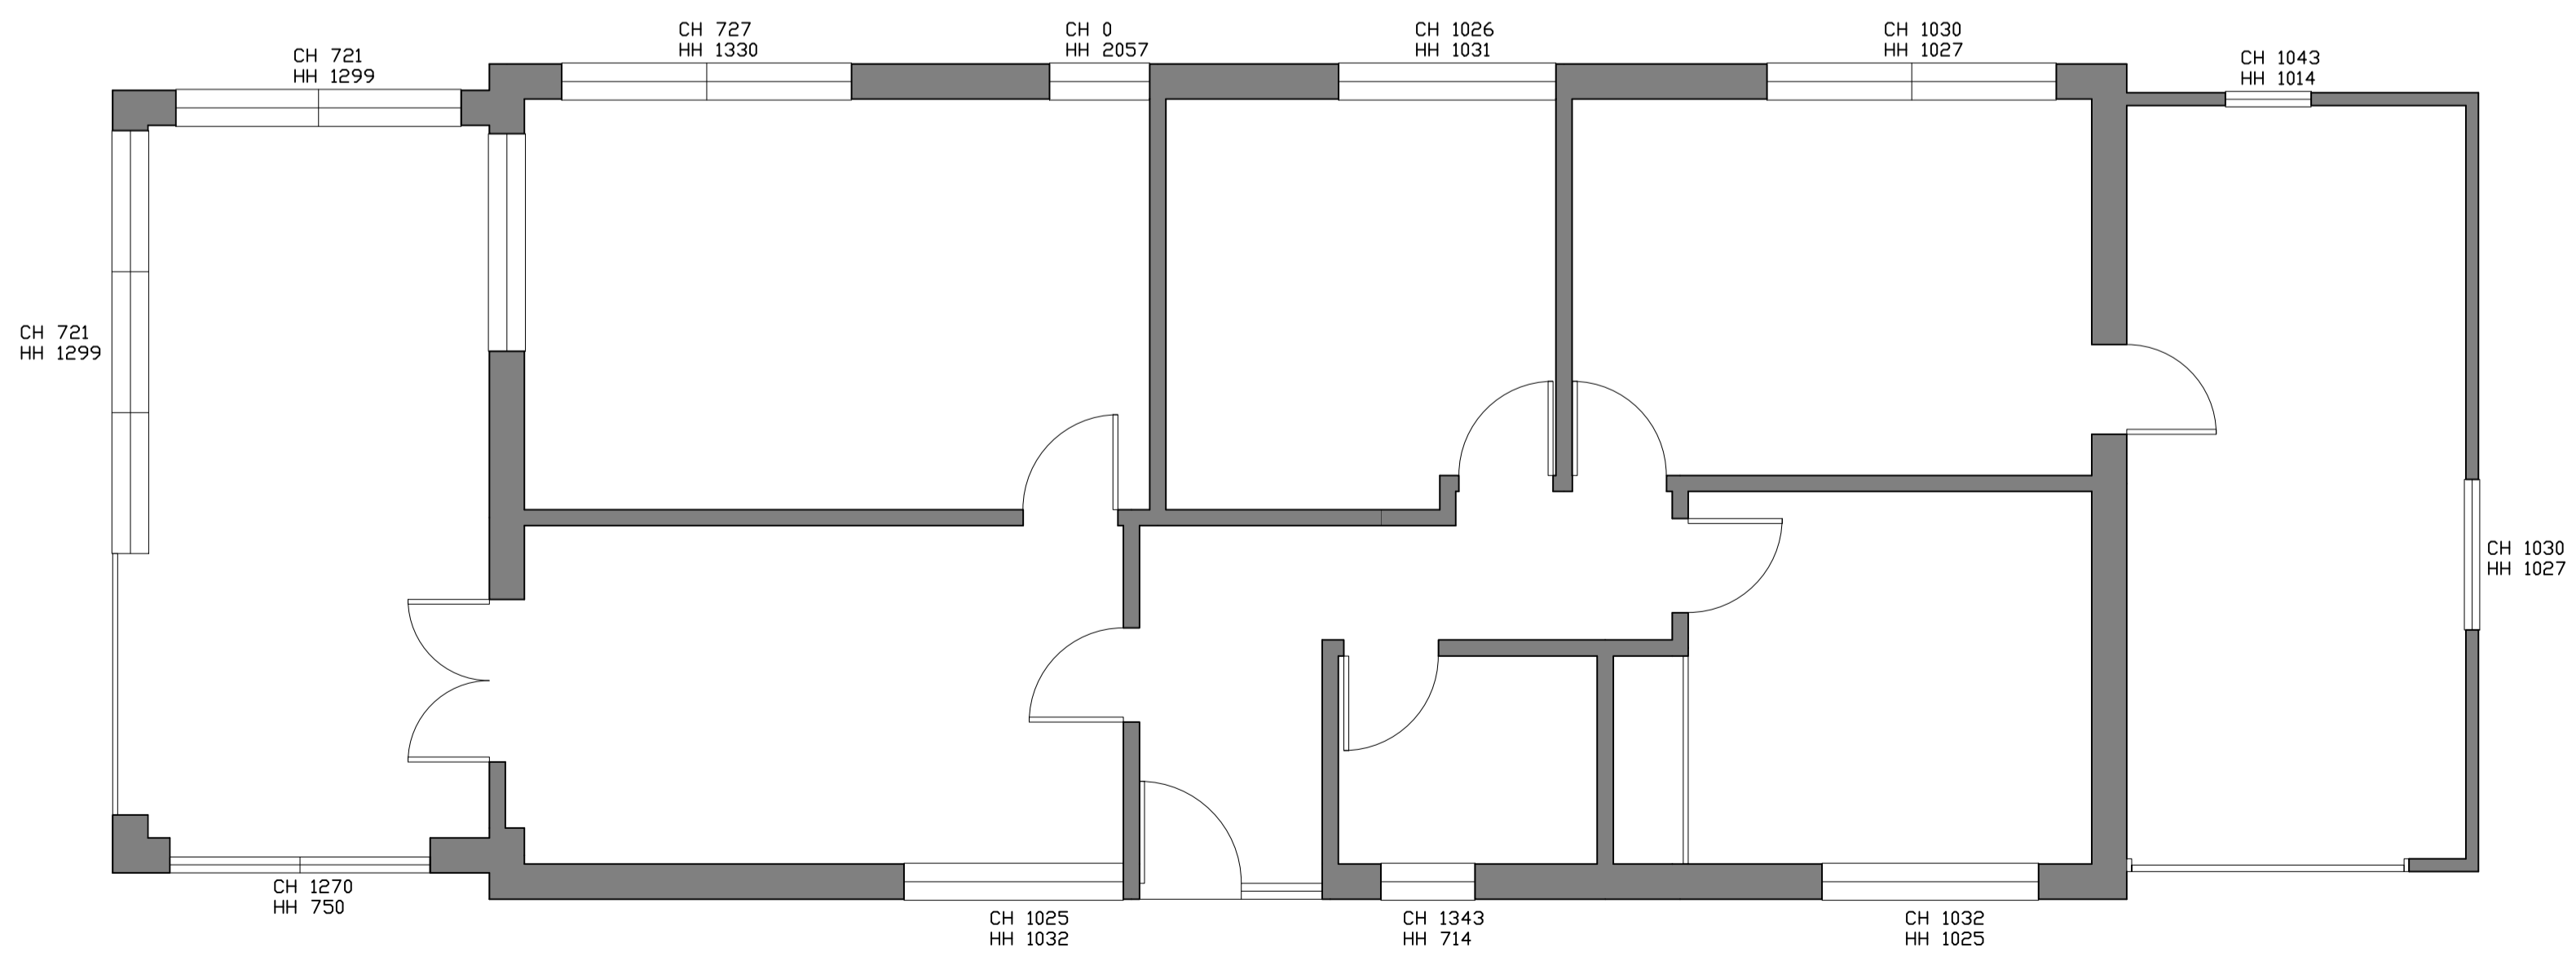

**Ground Floor Plan** Scale 1:50  
0.0m 1.0m 2.0m 3.0m 4.0m 5.0m

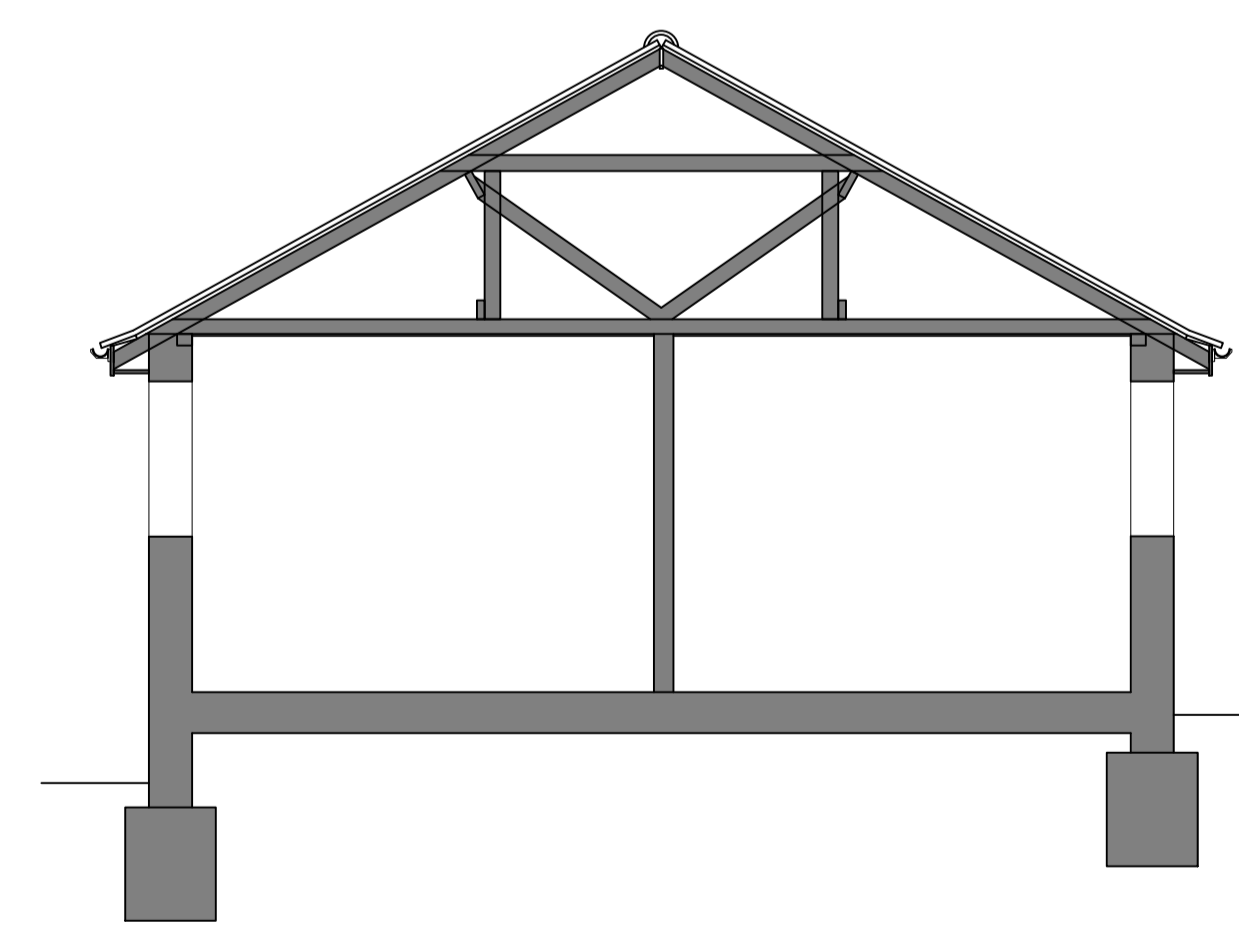

**Typical Section** Scale 1:50  
0.0m 1.0m 2.0m 3.0m 4.0m 5.0m  
Roof Make Up  
47x97mm ceiling joists  
50x100mm rafters  
50x125mm binders  
50x180mm purlins  
50x105 collars & struts

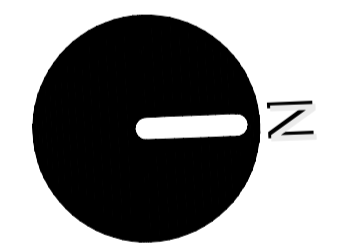

Revisions



**DIGI DESIGN CO**  
Architecture Ltd  
Cherwell Business Village F161,  
Southam Road, Banbury, Oxon. OX16 2SP.  
T: +44 (0)1295 267617 M: +44 (0)7748 402723  
<http://www.digidesignco.com>

Client  
**Mr T Robbins**  
Project  
**Windrush**  
**Austin Drive**  
**Bodicote**  
**Banbury Oxon OX15 4AS**

Drawing  
**Survey**  
**Plans, Elevations & Section**

Project Ref	Date	Drawing Number	Revision
DDC-2020-611	May 2020		
Scale	Sheet Size	<b>001</b> -	
AS SHOWN	A1		
Drawn	Checked		
All	All		

