


DO NOT SCALE


This drawing is the property of Dig Design Co Architecture Ltd. Copyright is reserved by them and the drawing is issued on the condition that it is not used, copied, reproduced, retained or disclosed either wholly or in part, by or to any unauthorised persons, without previous consent in writing of Dig Design Co Architecture Ltd.

PLEASE CHECK ALL DIMENSIONS ON SITE PRIOR TO COMMENCING PROJECT


NOTES

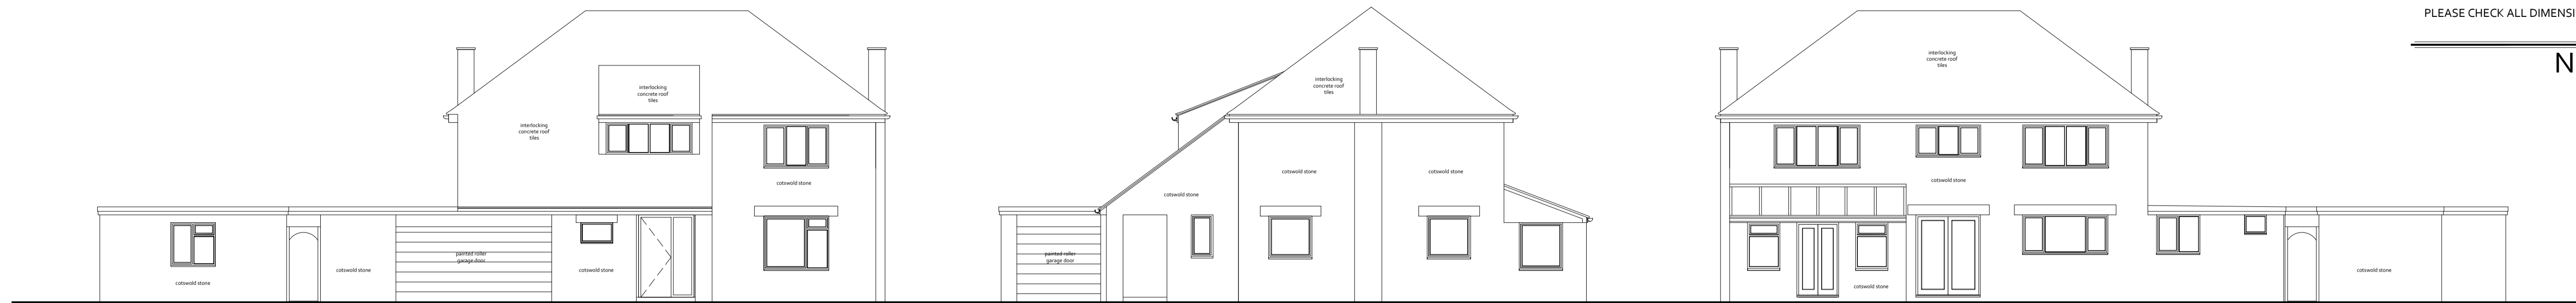


 
South Elevation Scale 1:100




East Elevation Scale 1:100

 



North Elevation Scale 1:100

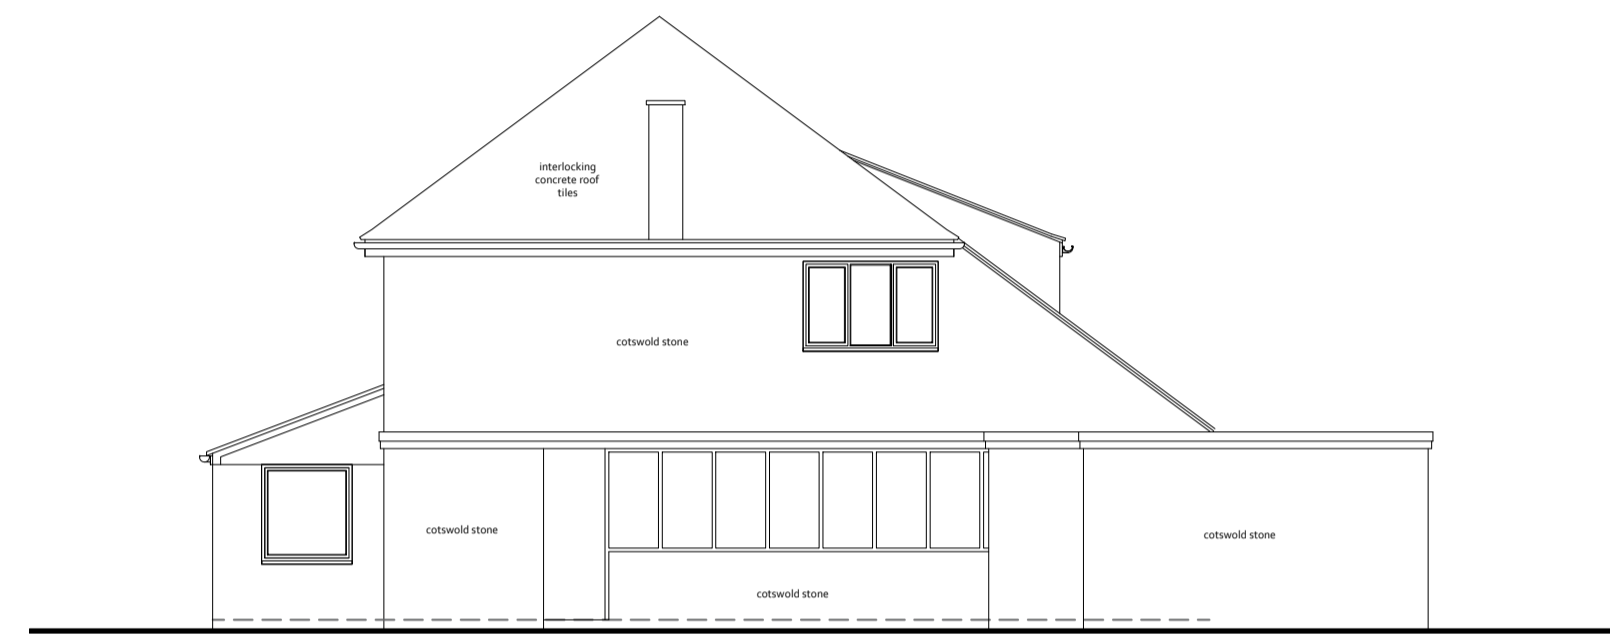 



West Elevation Scale 1:100

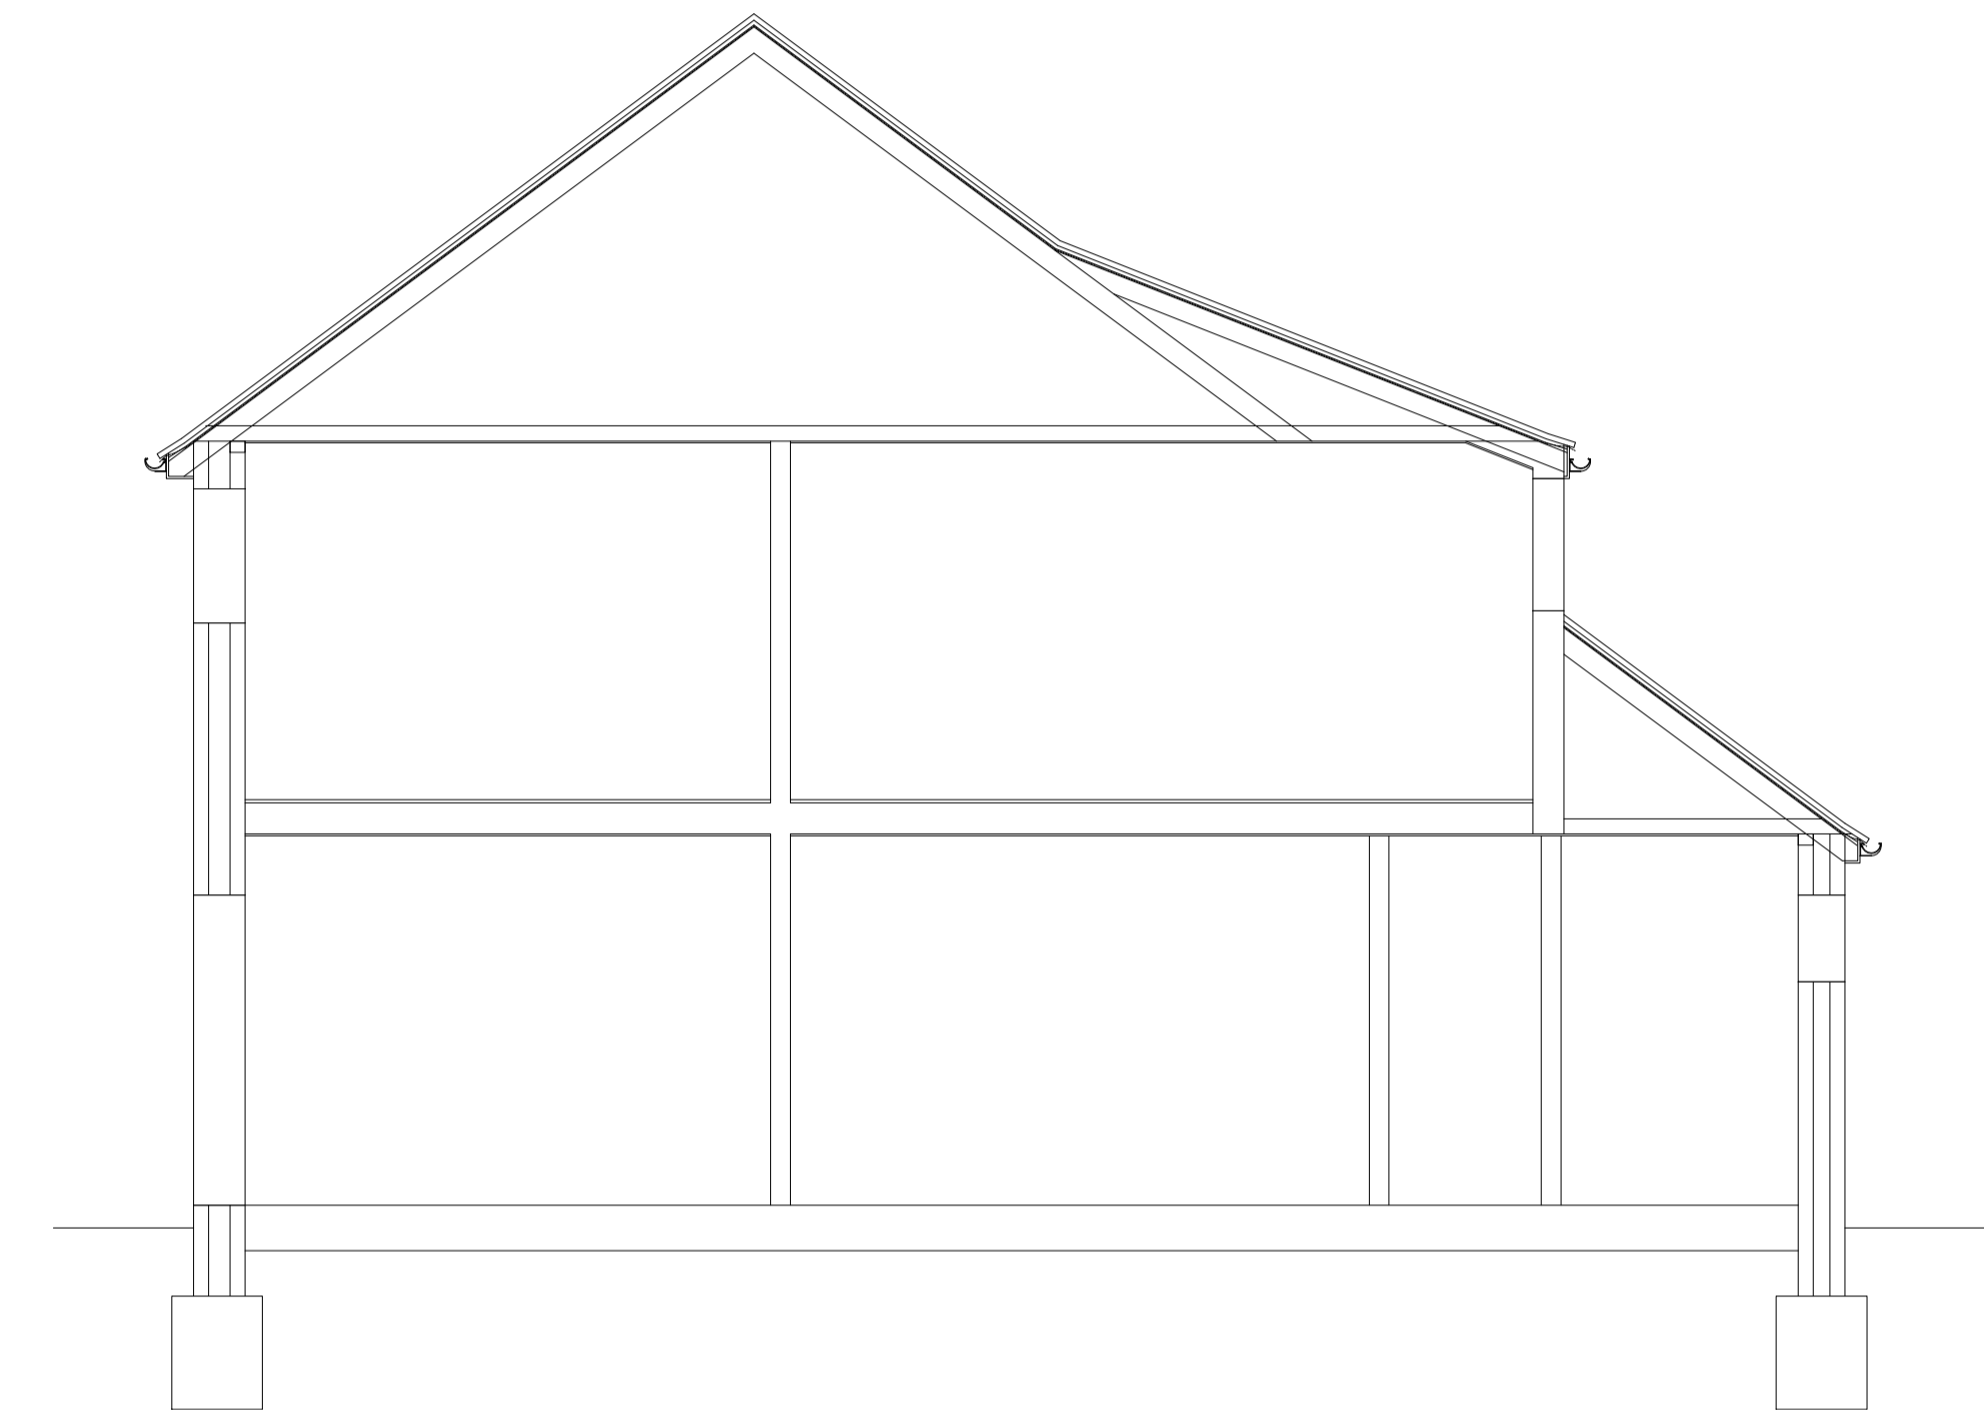



Internal Section Scale 1:50

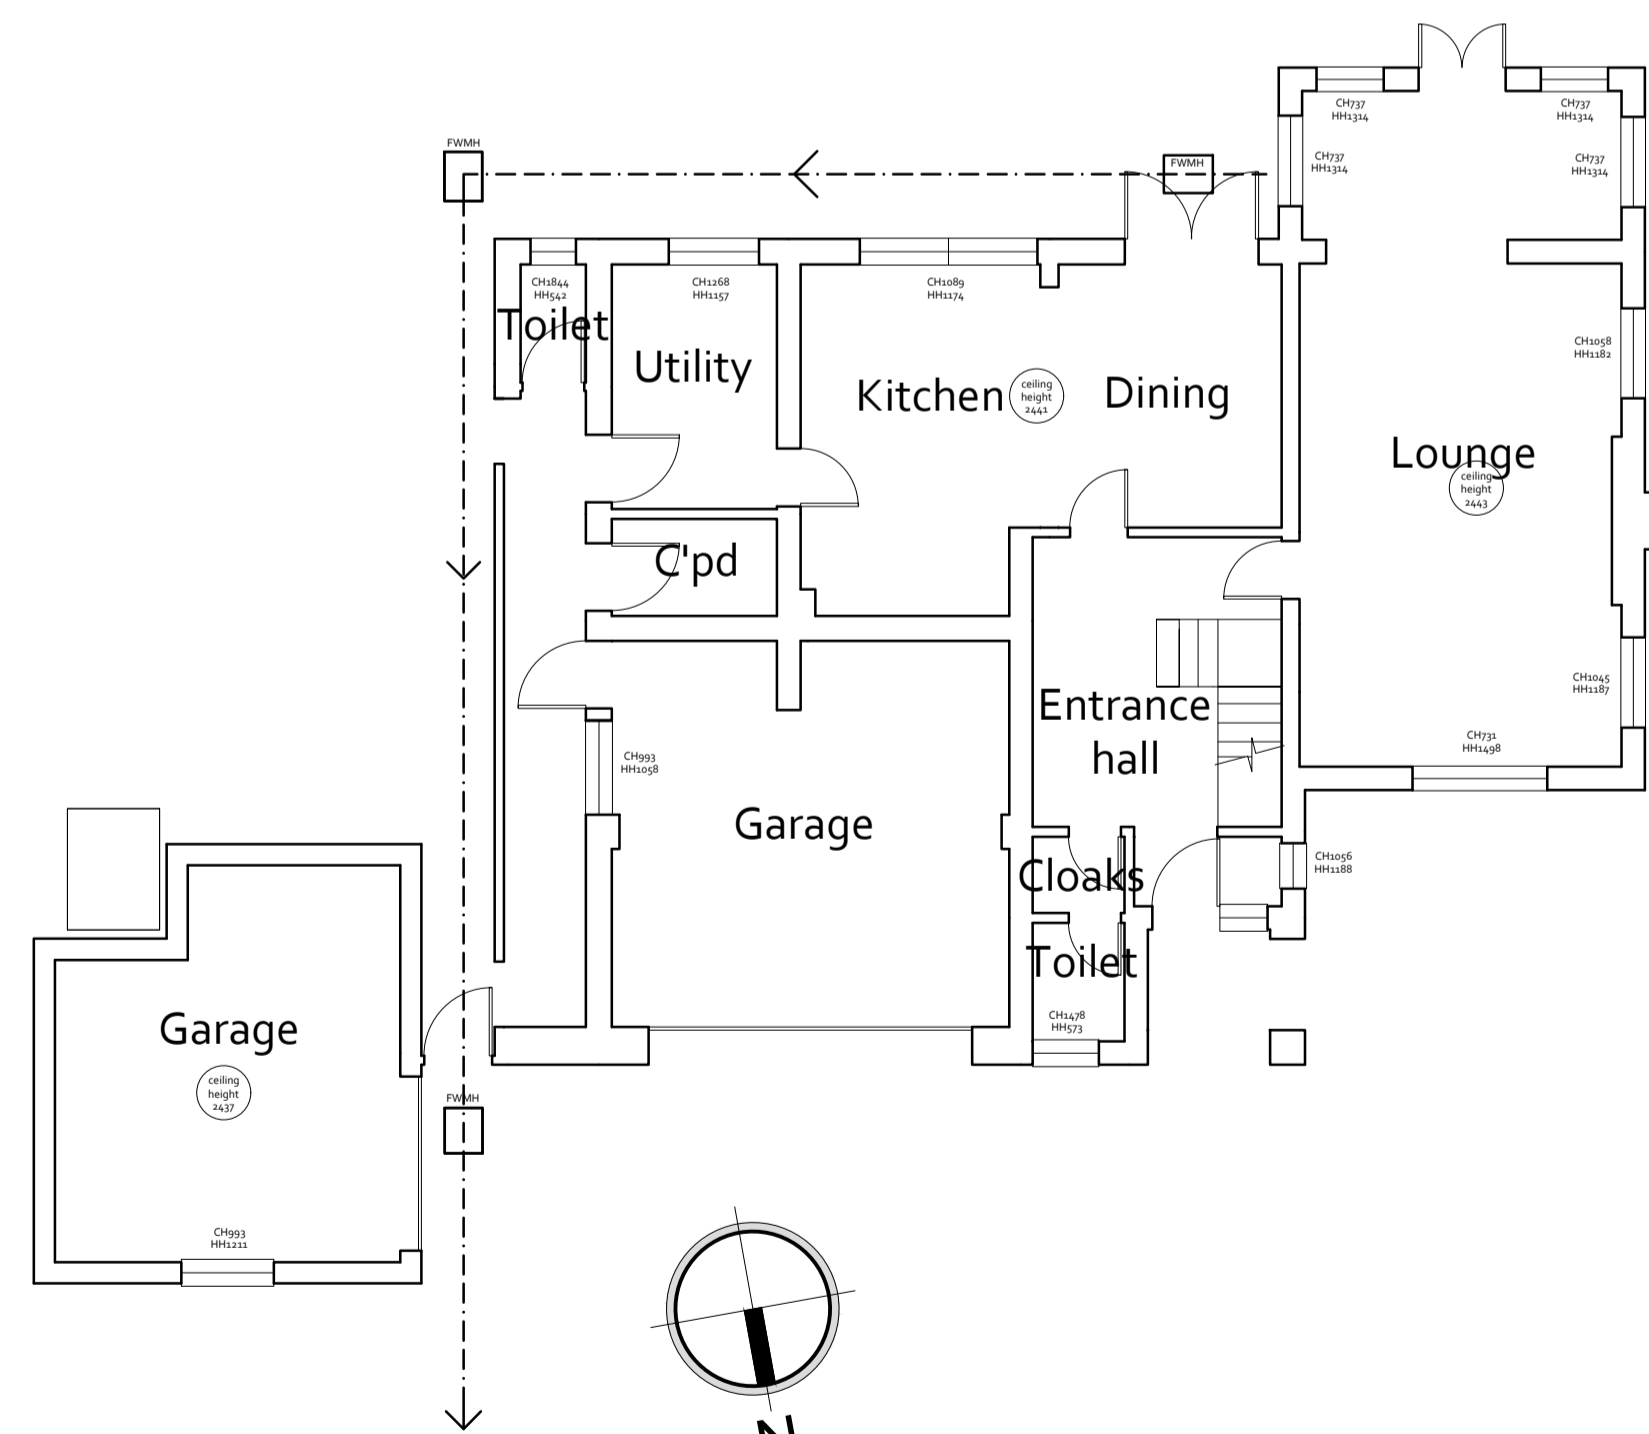 

Ground Floor Scale 1:100

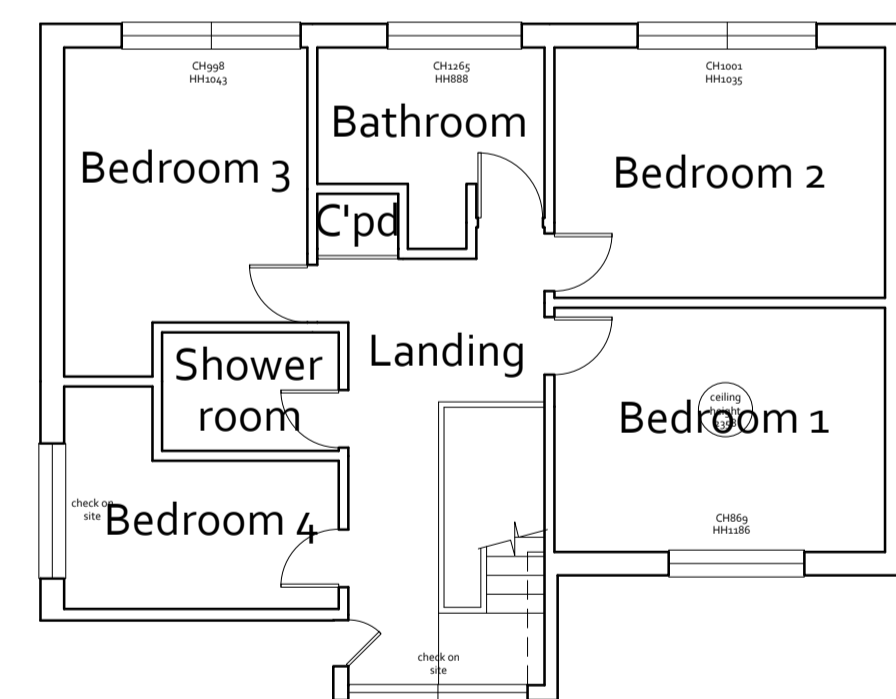 

First Floor Scale 1:100

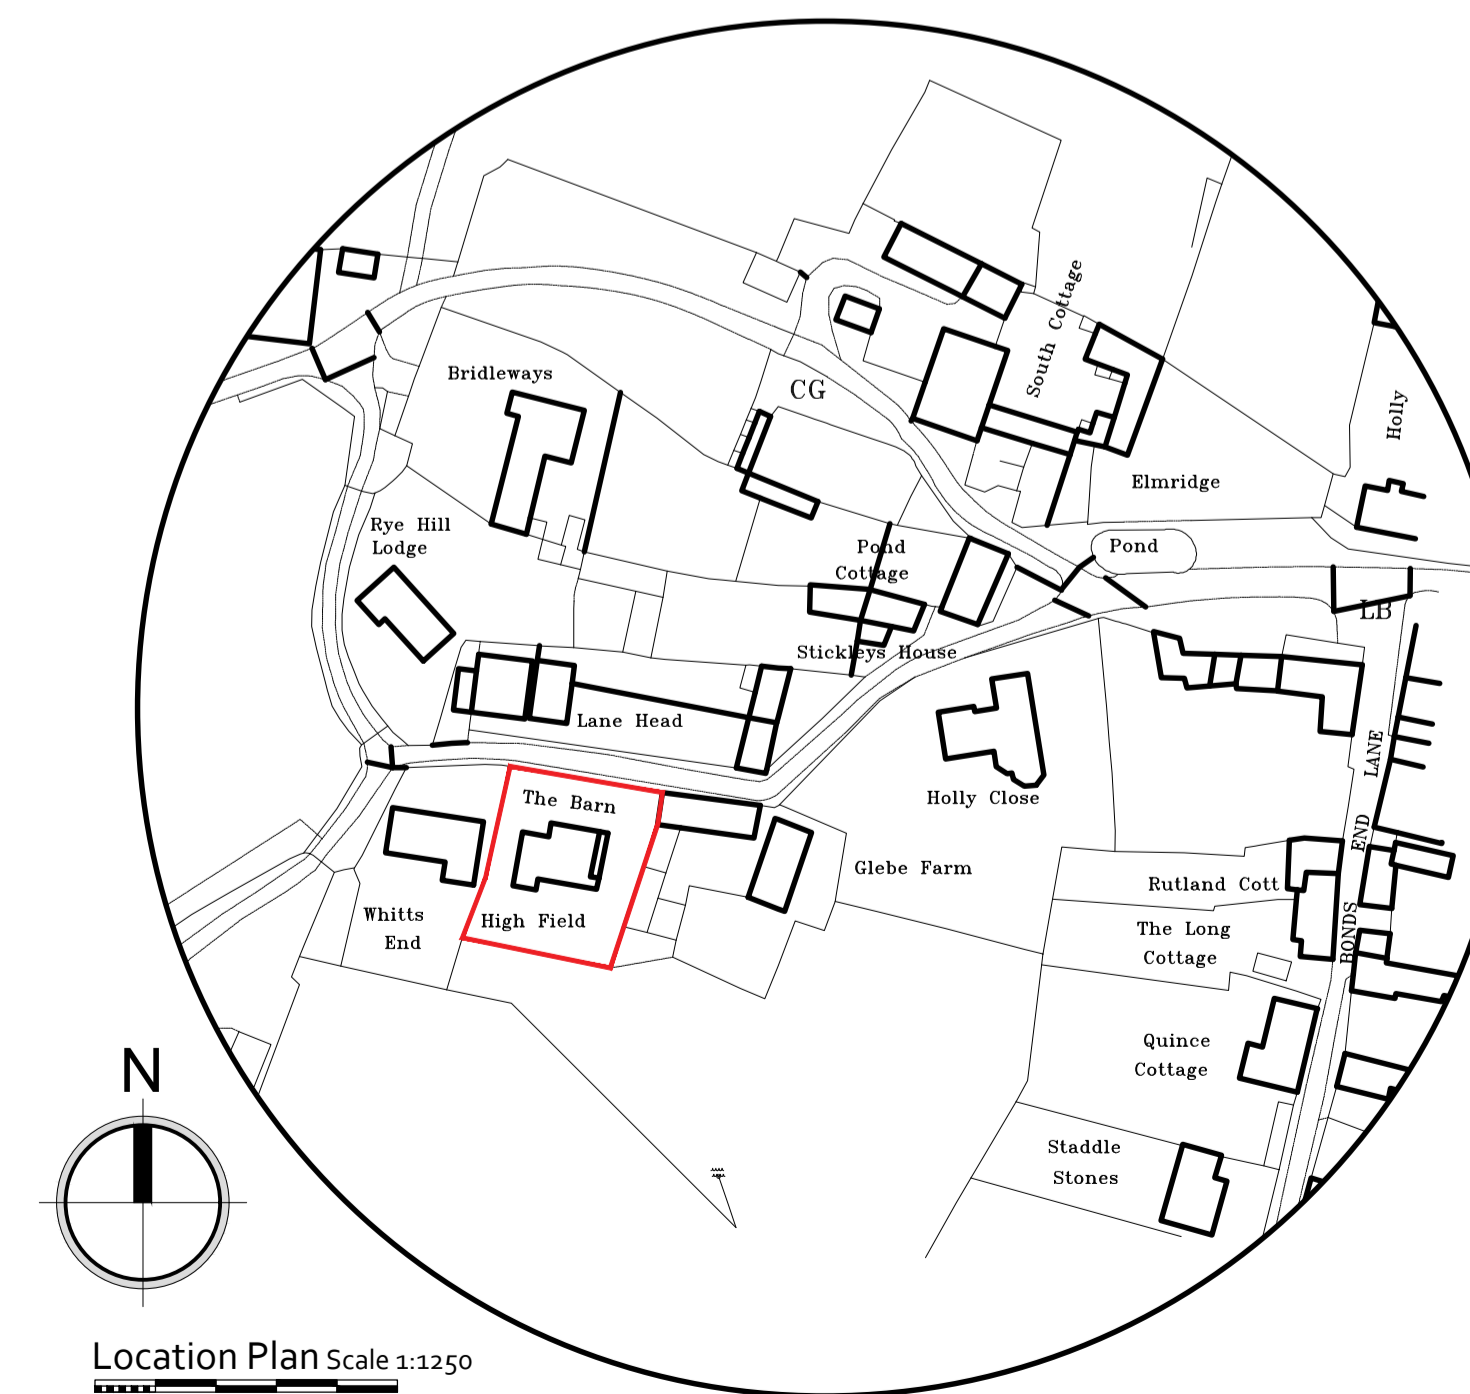 

Location Plan Scale 1:1250



Revisions		
Client	Mr and Mrs Thomas	
Project	Highfield Sibford Gower Banbury Oxon OX15 5RT	
Drawing	Survey drawing Plans and elevations	
Project Ref	Date	Drawing Number
DDC-2019-574	July 2019	
Scale	Sheet Size	001
AS SHOWN	A3	

DIGI·DESIGN·CO
Architecture Ltd

5 Church Farm Court,
Tysoe, Warwickshire. CV35 0TE.

T: +44 (0)1295 688382 M: +44 (0)7748 402723
F: +44 (0)717 336037

<http://www.digidesignco.com>

