



Phase 1 FW Pumped Main Plan 1:500

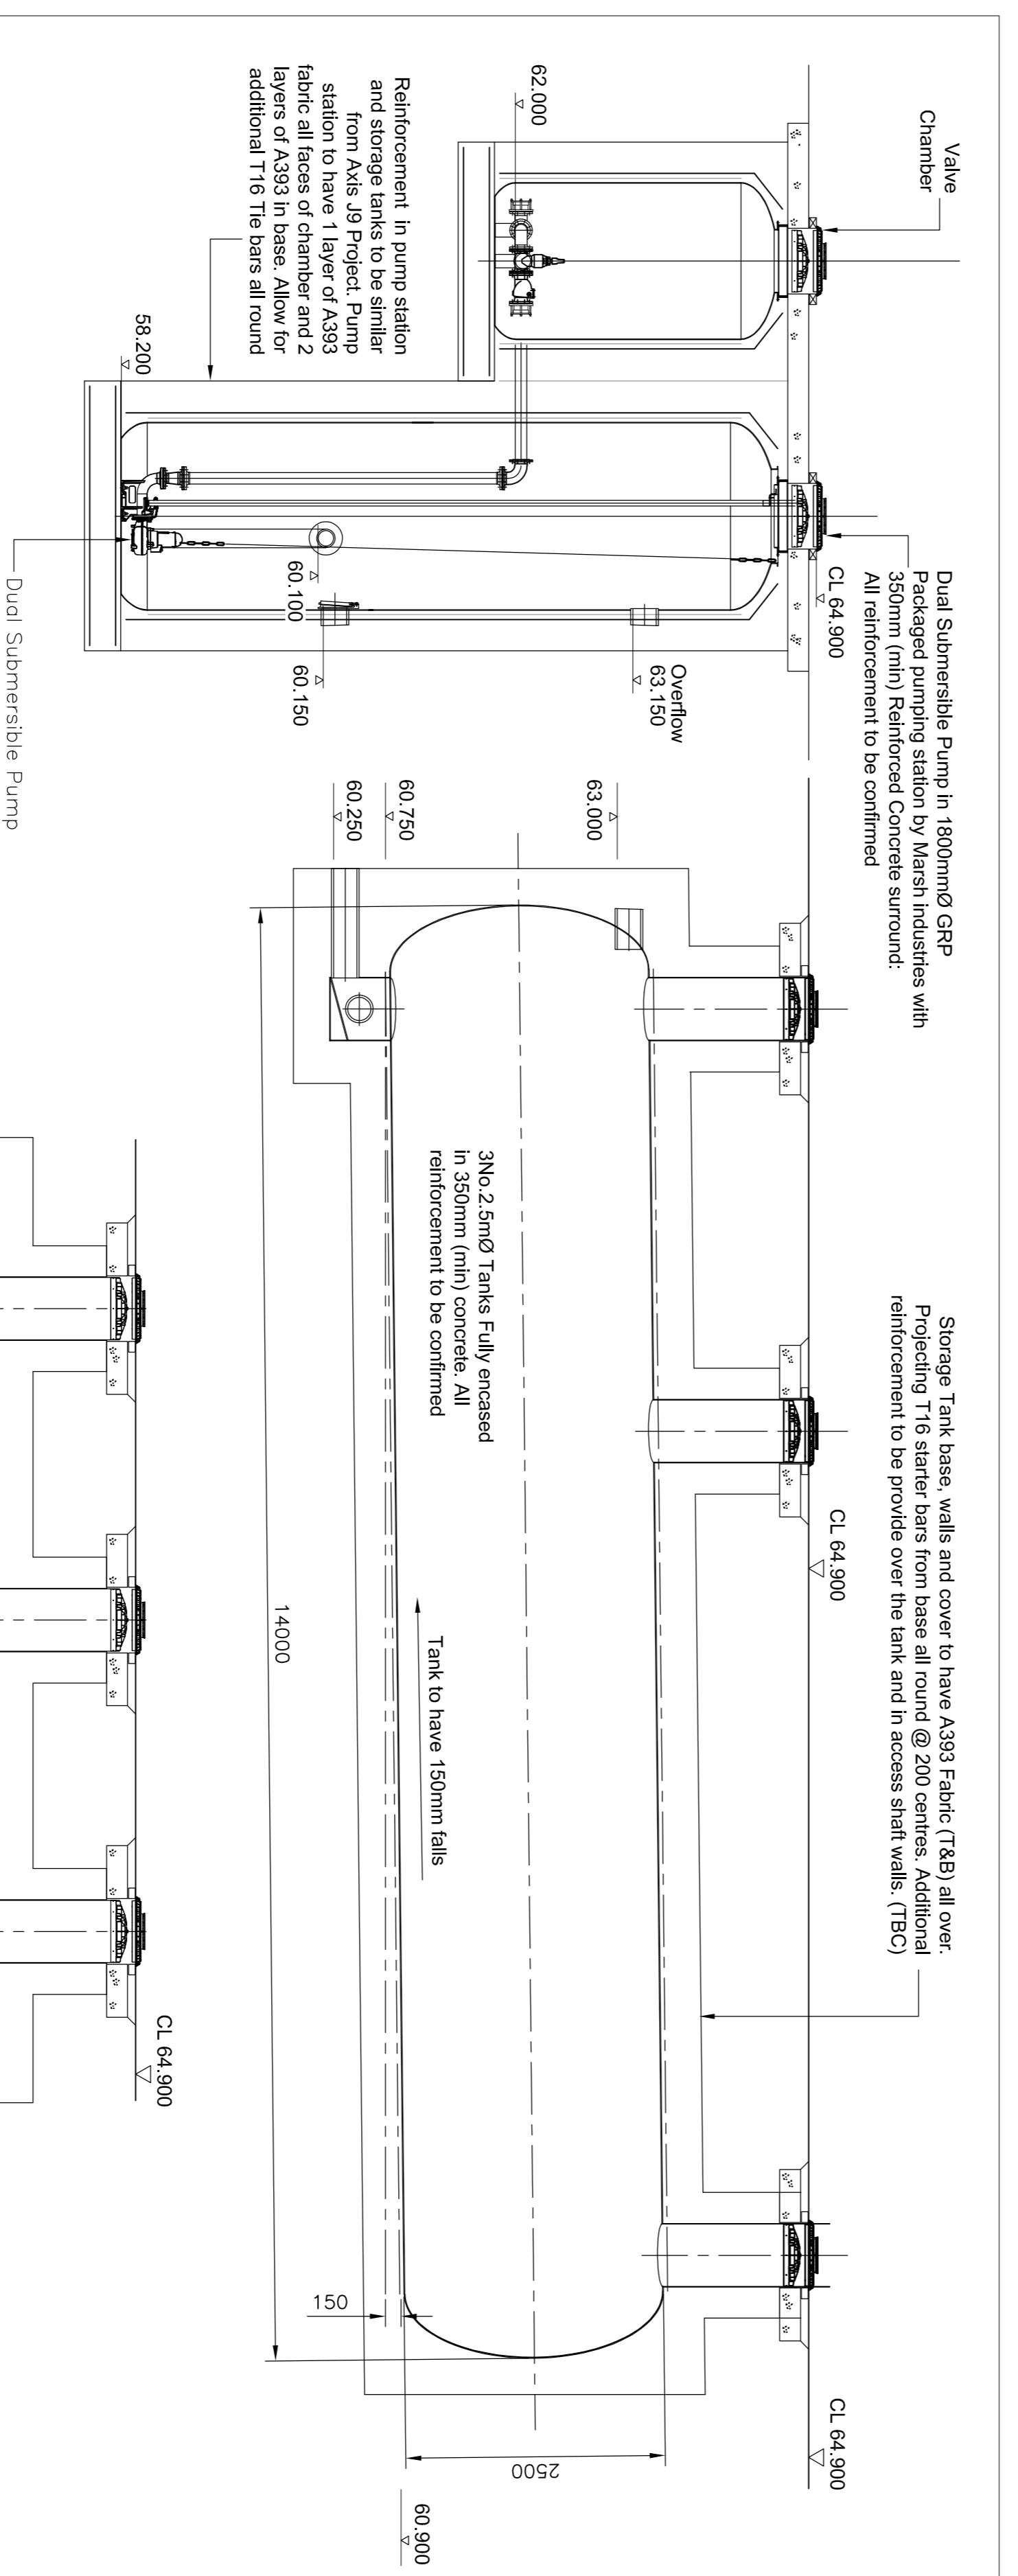

Foul water pumping station & Valve chamber 1:50

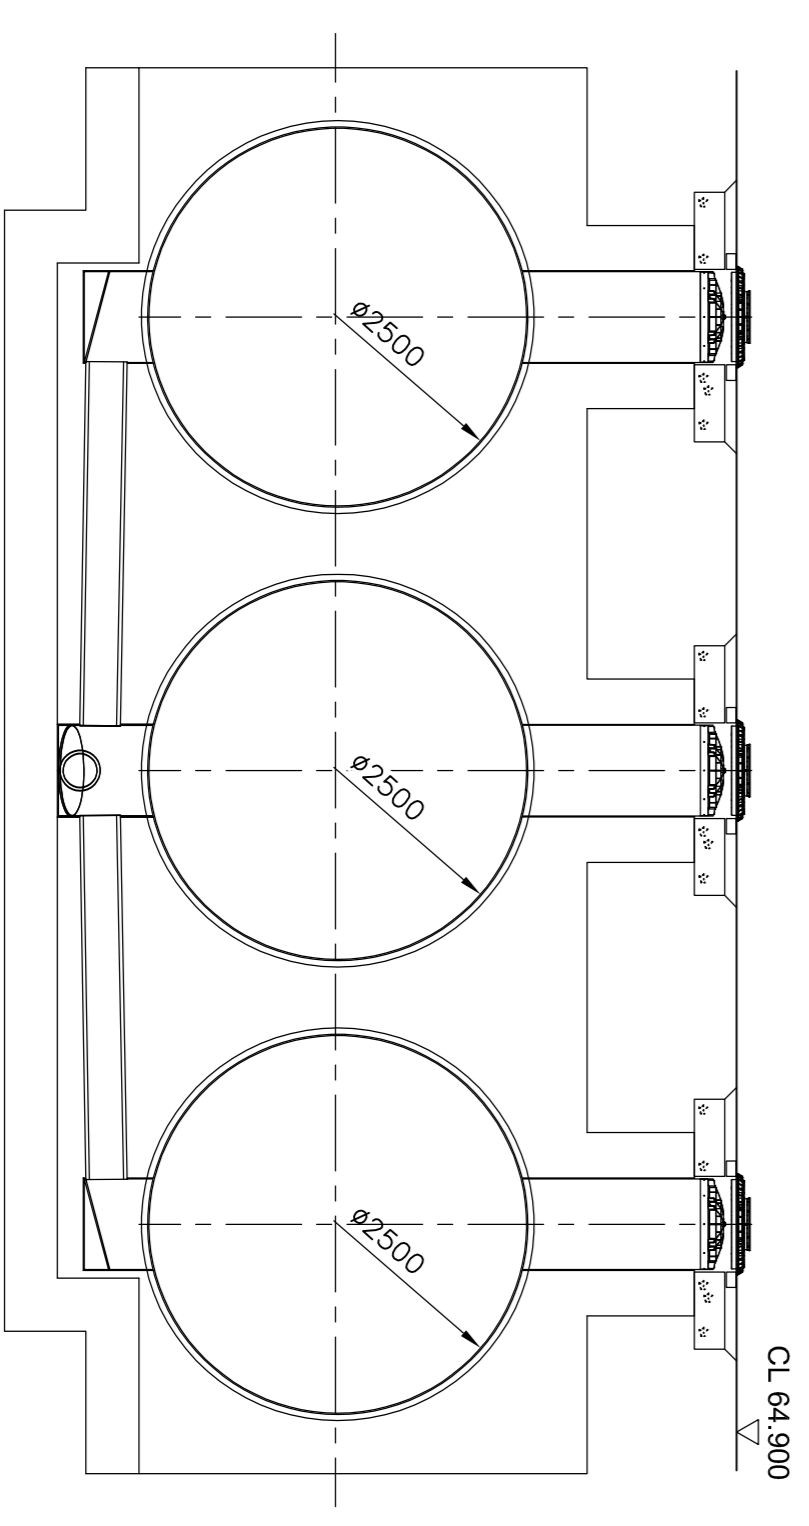

Typical Offline Storage tanks Section 1:50

RM A1 29.09.20

NOTES
 MK Surveys
 Topographical Survey (June 2018)
 Cornish Architects
 Phase 1 Proposed Site Plan Option 3
 Plan Ref: 18022 - SK - 117(C) (July 2020)

PRELIMINARY

Rev	Date	Revision Description
C	29.09.20	PHASE 1 RM A1 APPLICATION
B	17.08.20	PACKAGE 2 WORKS CLARIFIED
A	17.07.20	ISSUED FOR ENABLING WORKS TENDER

Revision Schedule
 Catalyst Bicester
 Wendlebury Road

Client:
Albion Land Plc.

**PHASE 1 - PACKAGE 2
 FW PUMP STATION & MAIN PLAN**

BAILEY JOHNSON HAYES
 Consulting Engineers
 STABAINS: Suite 4, Phoenix House, 63 Campbell Rd, ST ALBANS, Herts AL1 5FL
 MANCHESTER: George House, John Dalton Street, MANCHESTER, M2 6FW

Scale: 1:500, 50 @A1
 Date: 14.07.20
 Drawn: JNG
S1358-PH1-04C