


TYPICAL SOAKAWAY MODULAR TANK DETAIL (SDS GEOLIGHT TANK, OR SIMILAR APPROVED)

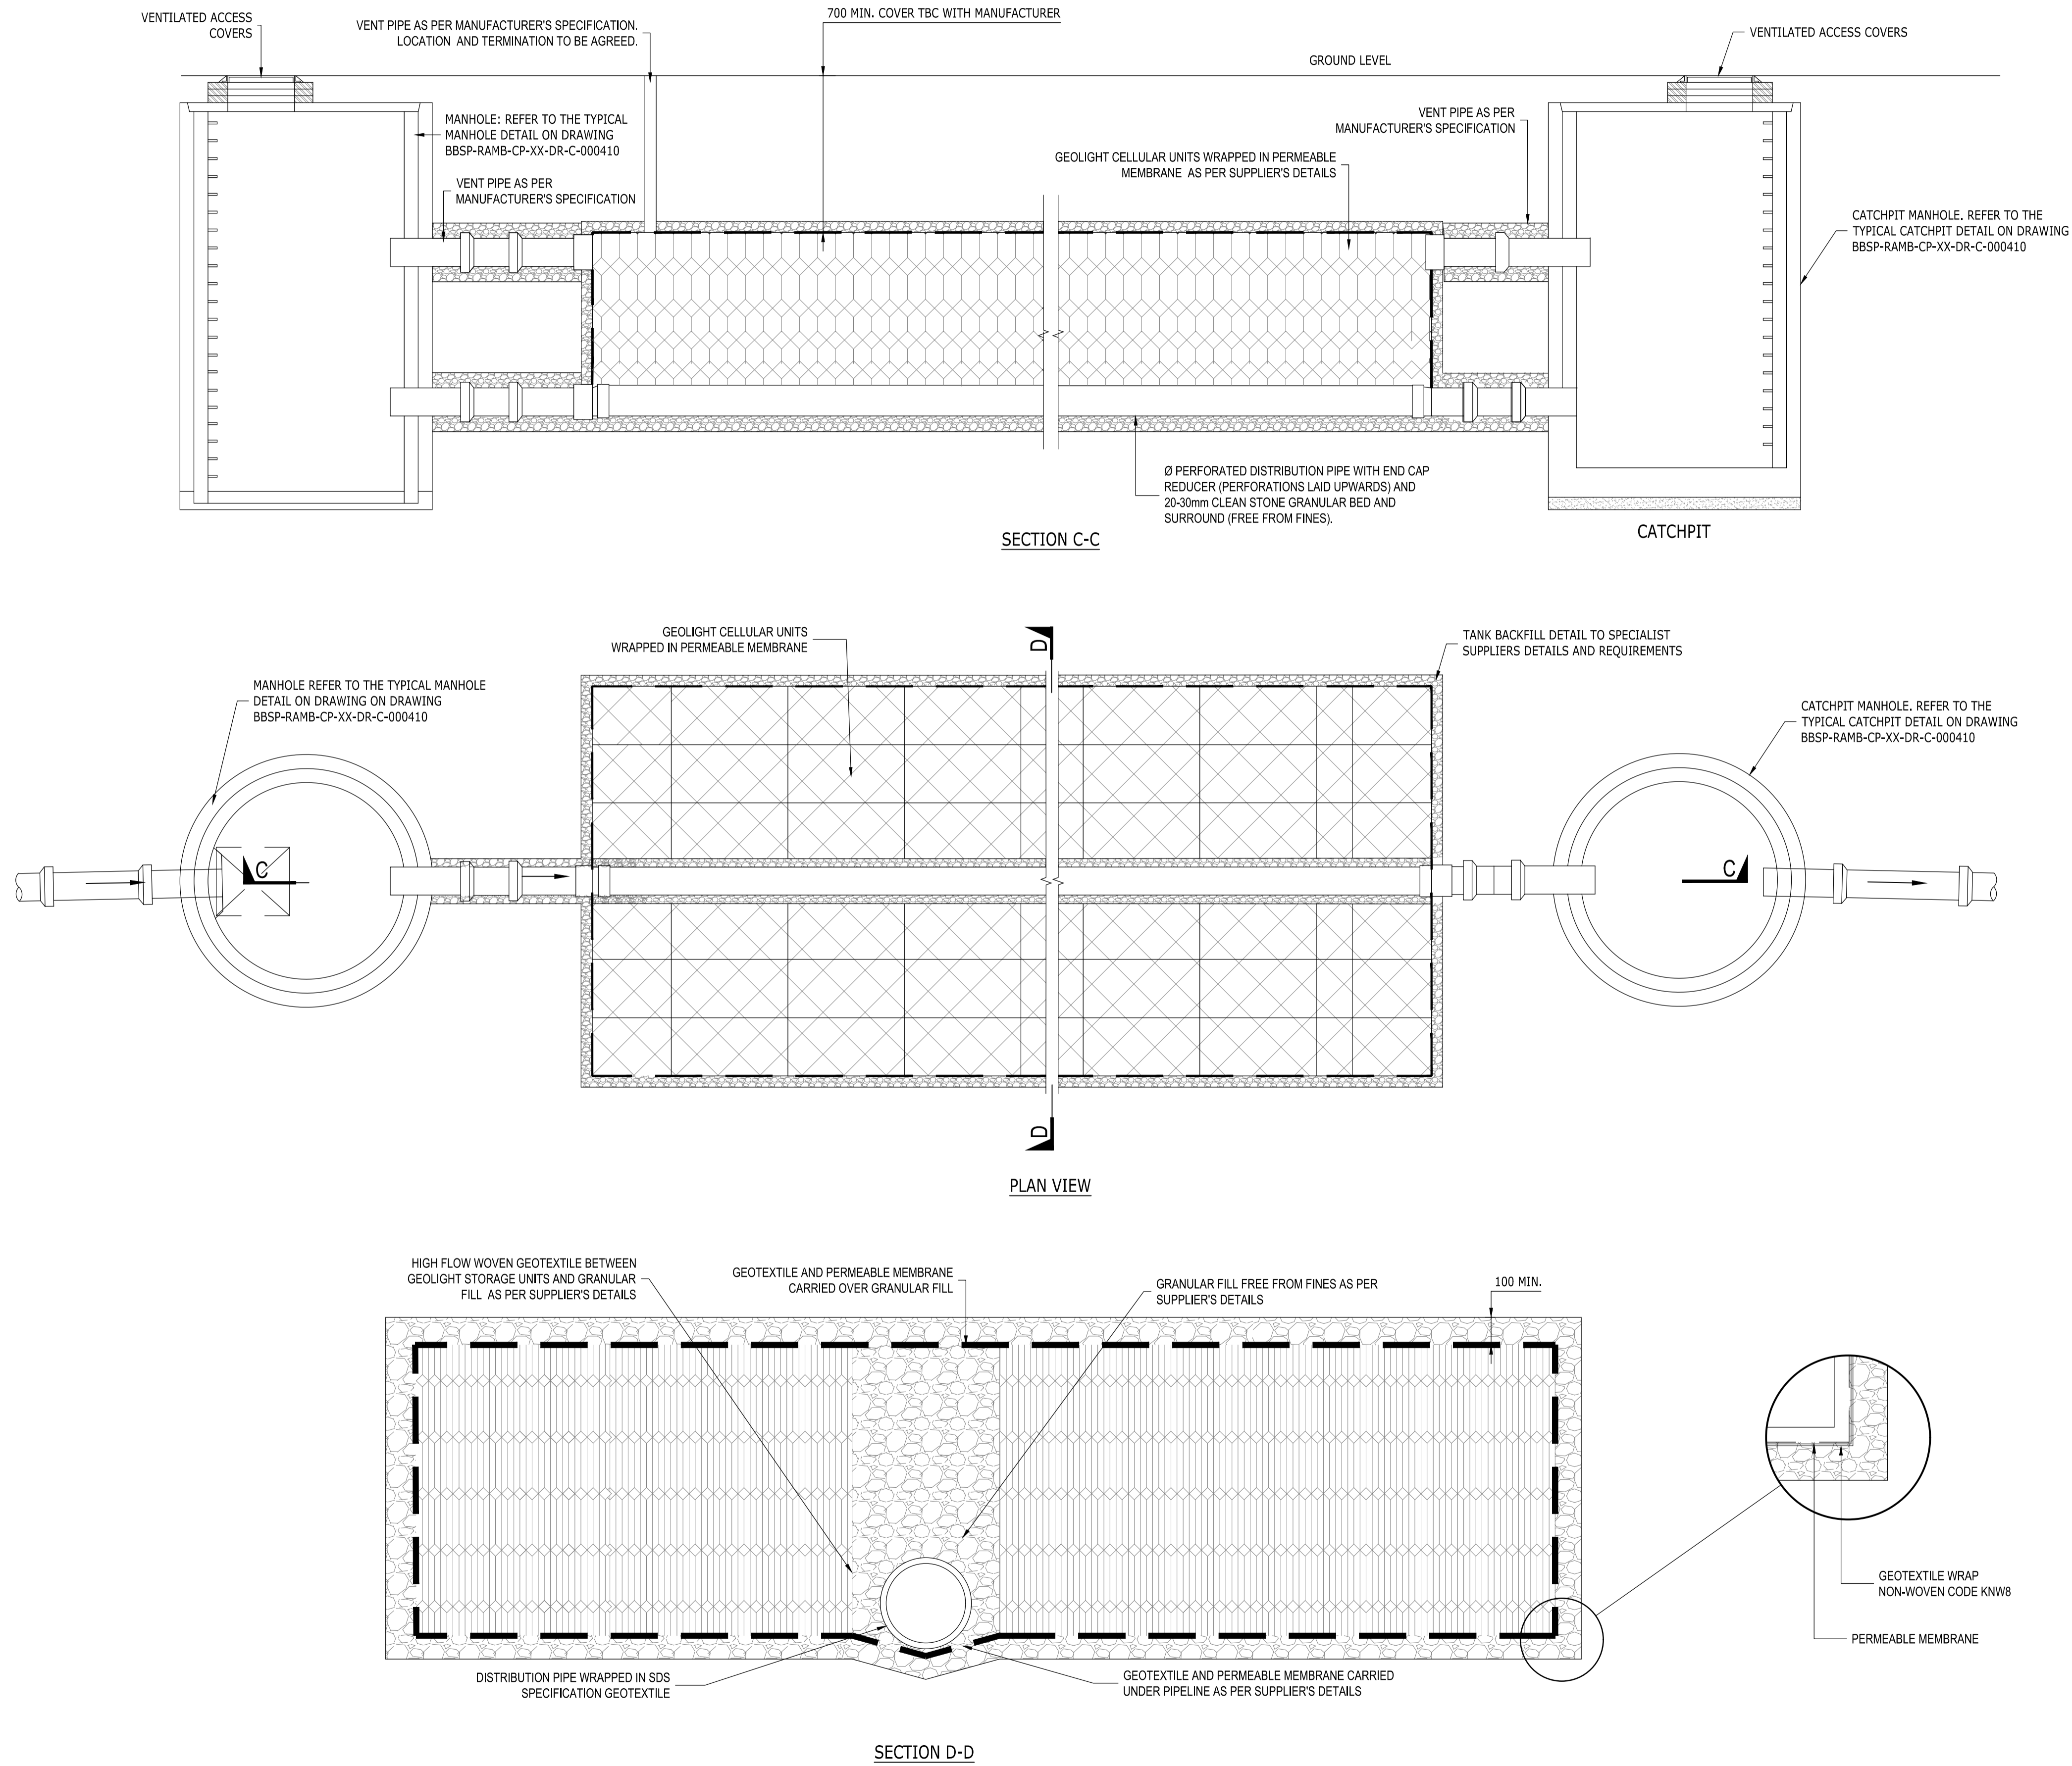

COPYRIGHT RAMBOLL UK LIMITED. ALL RIGHTS RESERVED. THIS DOCUMENT IS ISSUED FOR THE PARTY WHO COMMISSIONED IT AND FOR THE SPECIFIC PURPOSE CONNECTED WITH THE PROJECT ONLY. IT SHOULD NOT BE RELIED UPON BY ANY OTHER PARTY OR USED FOR ANY OTHER PURPOSE. RAMBOLL ACCEPTS NO RESPONSIBILITY OR LIABILITY WHICH MAY ARISE FROM RELIANCE OR USE OF THIS DOCUMENT OR THE DATA CONTAINED HEREIN BY ANY OTHER PARTY OR FOR ANY OTHER PURPOSE.

- Notes
1. THIS DRAWING IS NOT TO BE SCALED.
 2. THIS DRAWING IS TO BE READ IN CONJUNCTION WITH ALL RELEVANT ARCHITECTURAL, STRUCTURAL AND M&E DRAWINGS.
 3. THIS IS NOT AN INSTALLATION DRAWING NOR A CO-ORDINATION DRAWING.
 4. INDICATIVE BELOW GROUND DRAINAGE STRATEGY SUBJECT TO FURTHER DESIGN DEVELOPMENT AND COORDINATION.
 5. REFER TO DRAWING BBSP-RAMB-CP-XX-DR-C-000110 FOR DRAINAGE LAYOUT.

P01	ISSUED FOR PLANNING	20.08 2021	MES LF	LS
Rev	Description	Date	By Chk	App

PLANNING

BEGBROOKE SCIENCE PARK
SURFACE CAR PARK

RAMBOLL

tel 020 7631 5291 london@ramboll.co.uk
www.ramboll.co.uk

CAR PARK
DRAINAGE DETAILS
SHEET 4

Project No:	Scale (BA1):	Drawn:	Date:
1620011508	1:1000	MES	AUG 2021
Drawing No:	Rev:		
BBSP-RAMB-CP-XX-DR-C-00413	P01		