
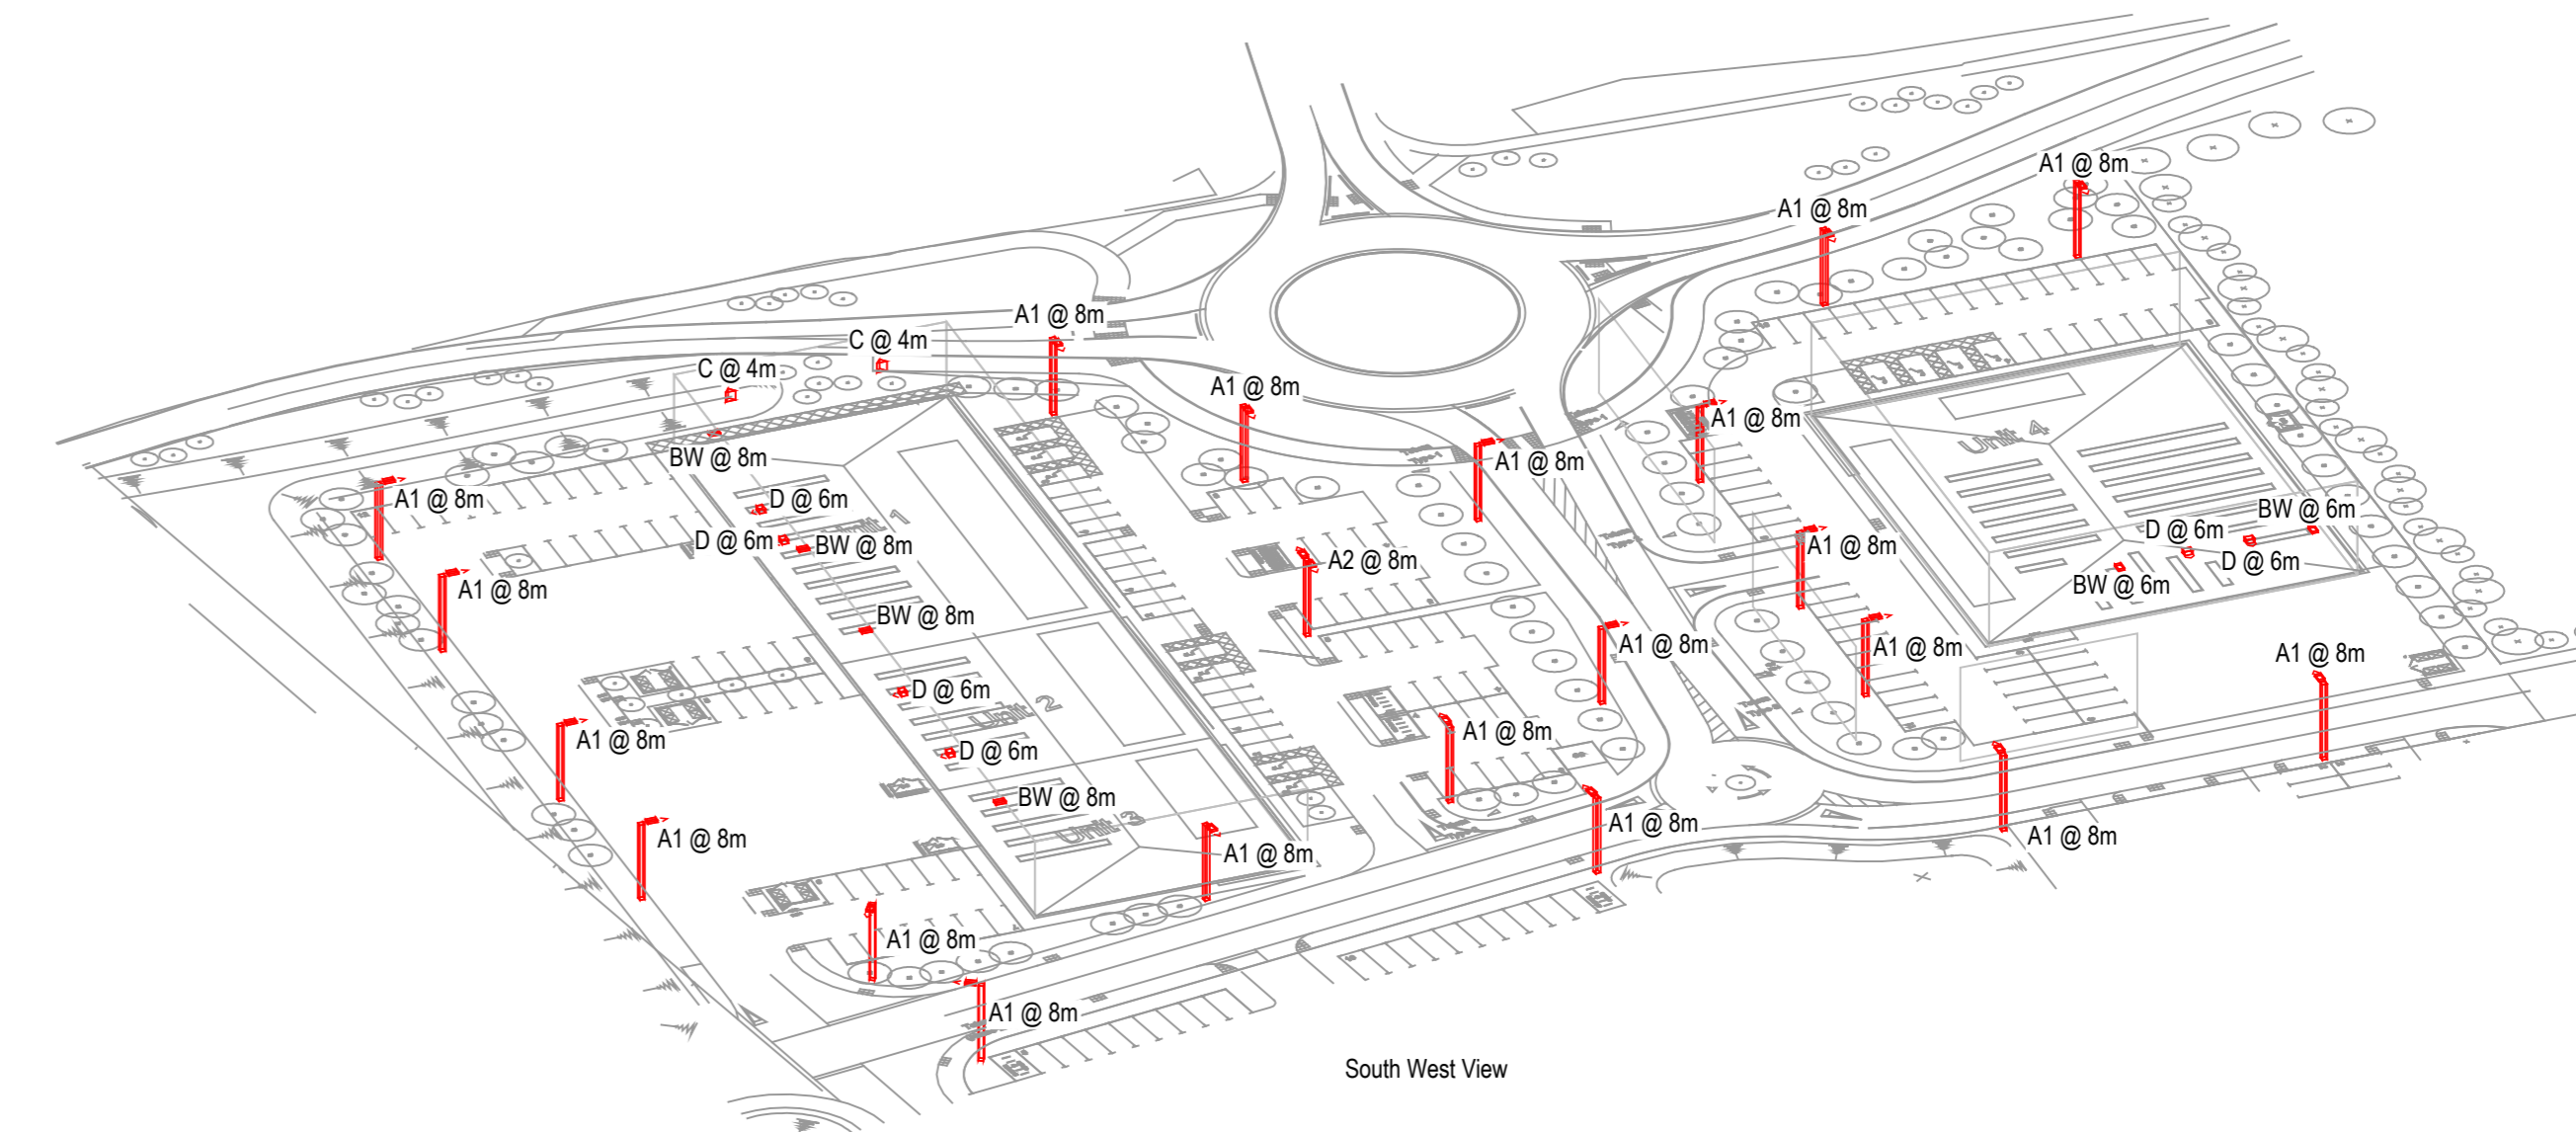


NO.	DESCRIPTION OF HAZARD	CONTROL MEASURES	ACTION BY
1	UNDERGROUND SERVICES AND SERVICES IDENTIFIED IN WIRING LOCATION	IDENTIFICATION OF EXISTING UNDERGROUND SERVICES DRAWINGS AND CAT SCANNING OF GROUND	CONTRACTOR
		CAREFUL EXCAVATION USING SLEET TRENCHES AND CAT SCANNING OF GROUND	

Statistics				
Description	Symbol	Avg	Min	Max/Avg
Access Road	+	20 lux	4 lux	0.20
SPILL	+	1 lux	0 lux	0.03
Unit 1 - Rear Walkway	+	13 lux	9 lux	0.62
Unit 1.2.3 - Parking	+	26 lux	11 lux	0.42
Unit 6 - Parking	+	25 lux	12 lux	0.48
Unit 6 - Service Yard	+	55 lux	19 lux	0.35
Unit 6 Loading Doors - 50	X	70 lux	65 lux	0.93
Unit 1 Loading Doors - 50	X	70 lux	65 lux	0.93
Unit 1.2.3 Yards and Parking	+	37 lux	13 lux	0.35
Unit 2 Loading Doors - 50	X	51 lux	47 lux	0.92
Unit 3 Loading Doors - 50	X	49 lux	47 lux	0.96

Schedule						
Symbol	Label	Quantity	Manufacturer	Catalog Number	Description	Wattage
+	A1	20	HOLOPHANE EUROPE LIMITED	1 x DSX1 2 LA164 FW on 8m Column	D-Series 1 Luminaire	131
+	A2	1	HOLOPHANE EUROPE LIMITED	2 x DSX1 2 LA164 FW on 8m Column	D-Series 1 Luminaire	262
+	BW	6	HOLOPHANE EUROPE LIMITED	DSX1 2 LA164 FW On Wall Bracket at 8m AFFL	D-Series 1 Luminaire	131
+	C	2	HOLOPHANE EUROPE LIMITED	DEW LA014 NR CGL at 4m AFFL	Denver Elite Wall	12
+	D	6	HOLOPHANE EUROPE LIMITED	WAP 1 LA094 FW at 6m AFFL	WALLPACK	81

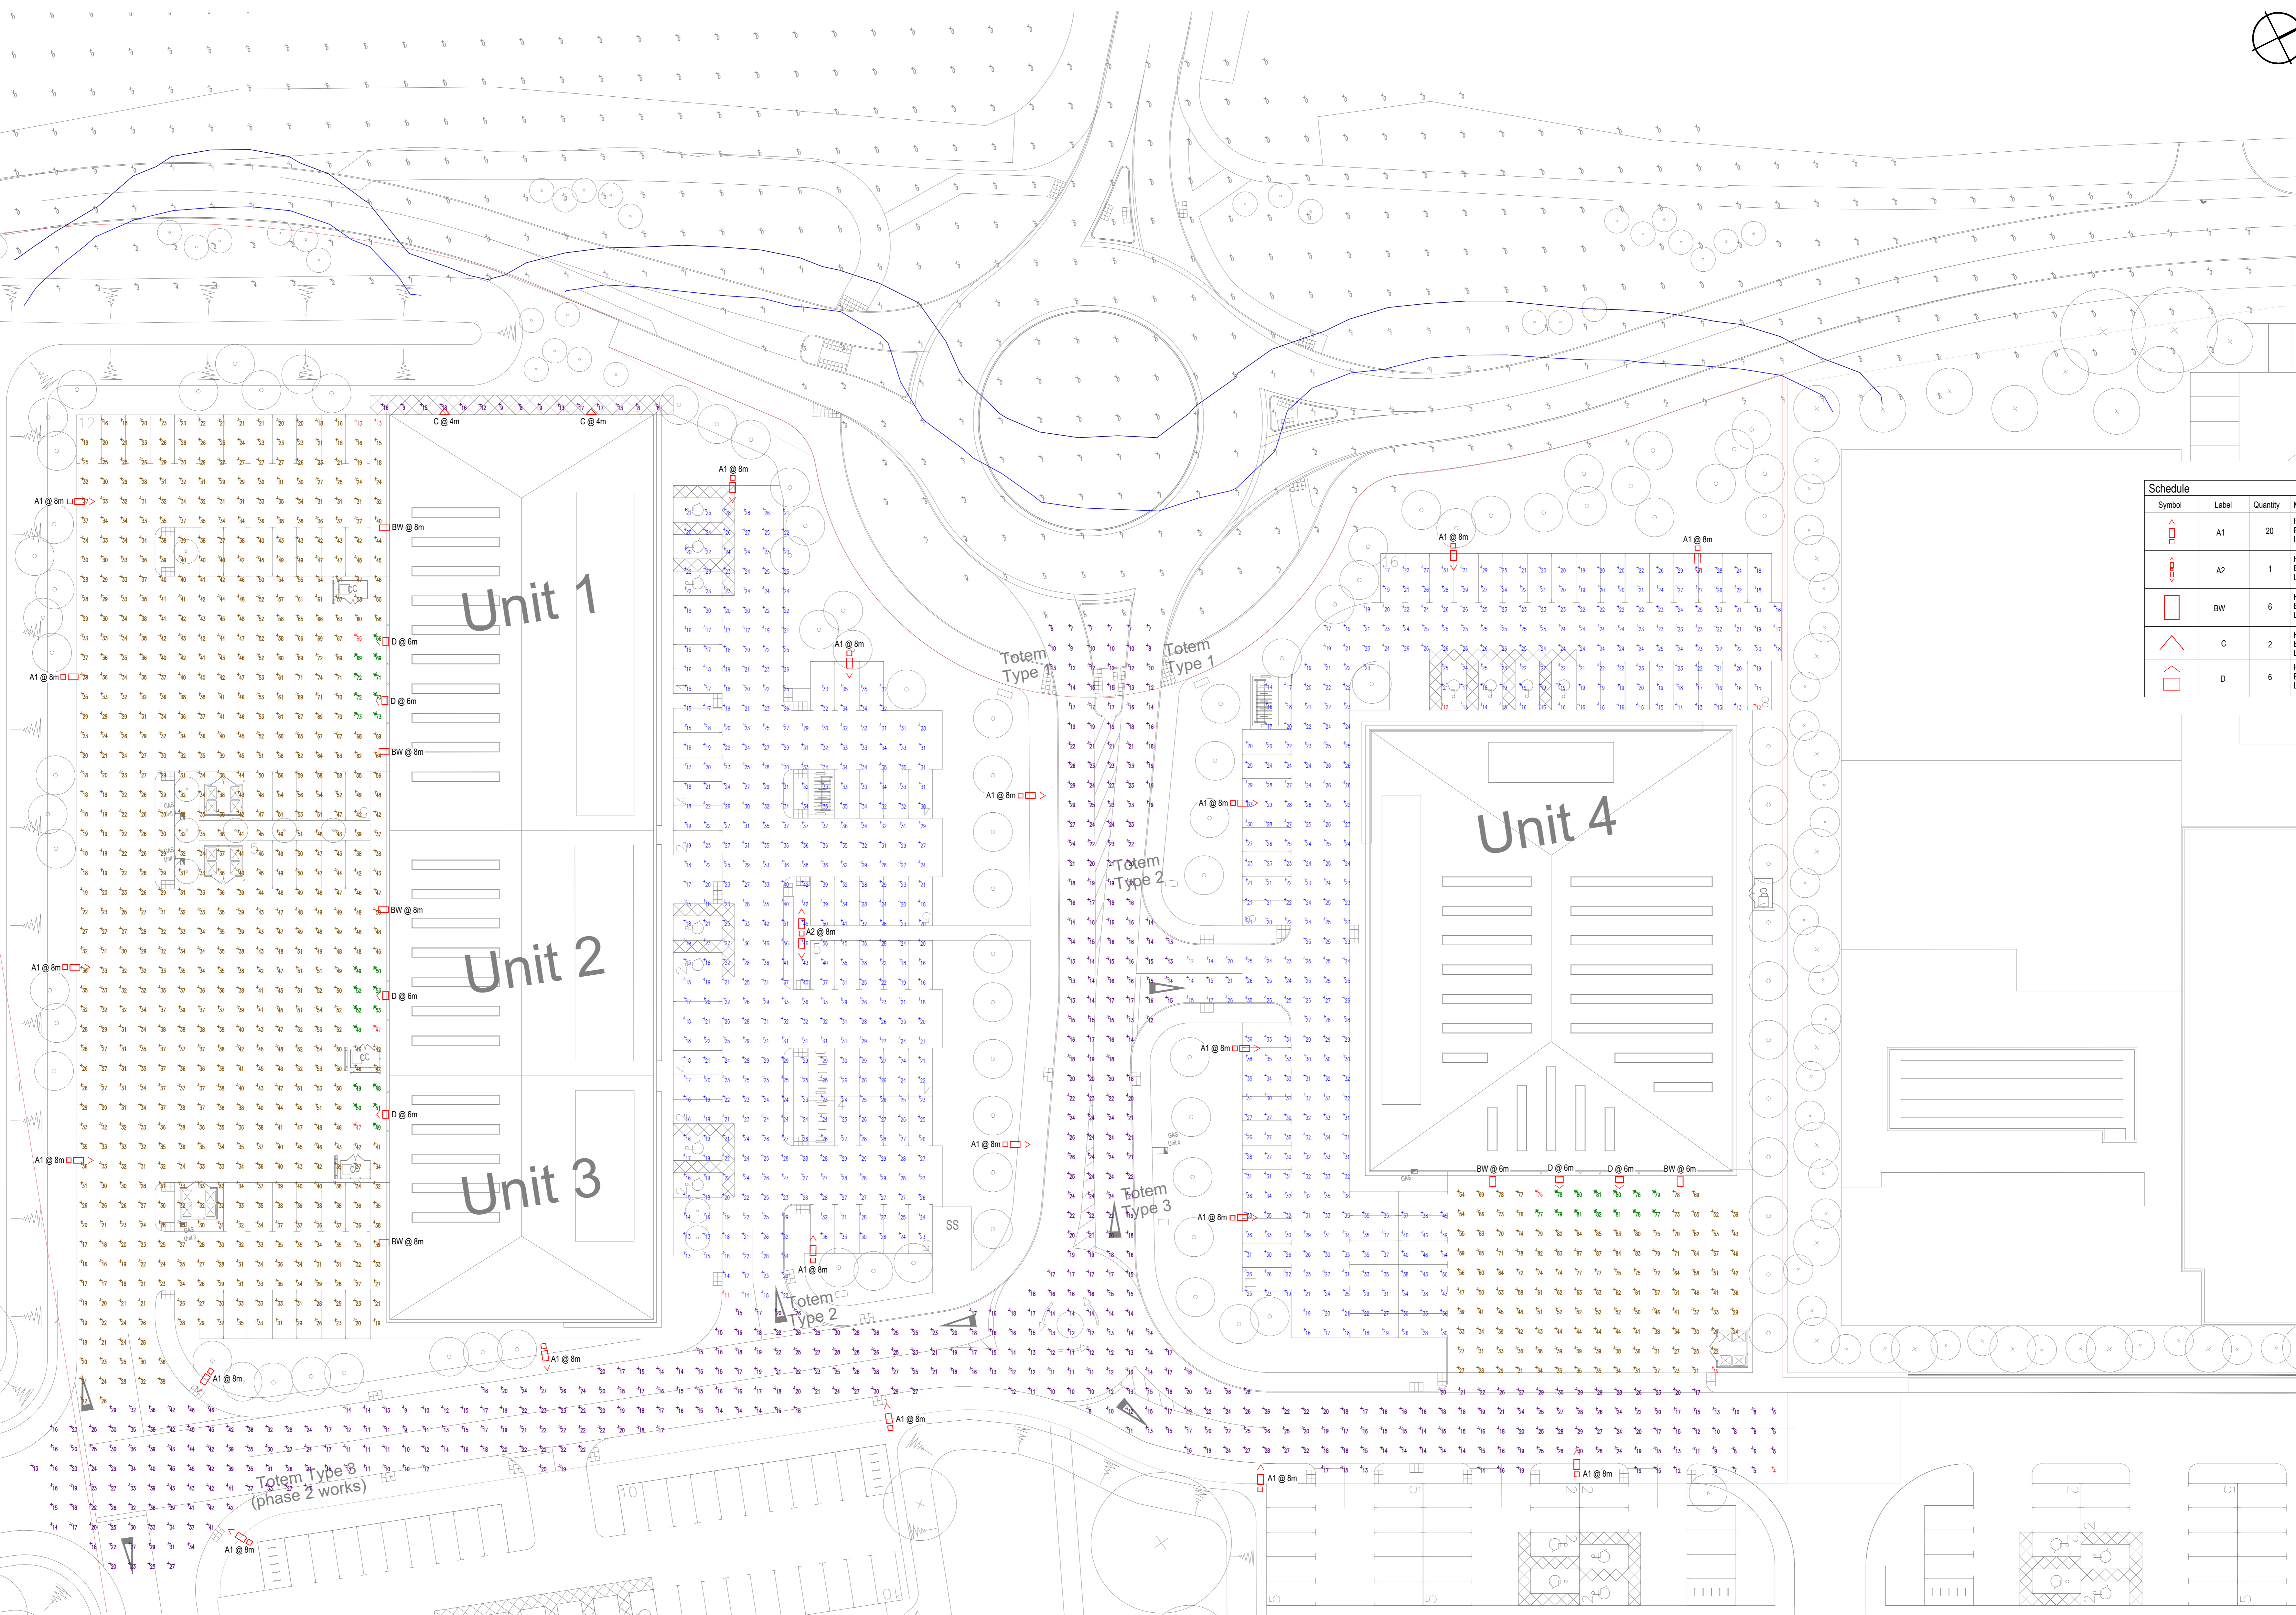

Rev.	Date	Details	Initials
T2	26.08.21	Tender Issue	CP
T1	27.11.20	Tender Issue	SB
P2	20.11.20	Preliminary Issue	CP
P1	10.07.20	Preliminary Issue	CP

Engineering Services Consultancy Ltd
 19 Luggate Hill
 Birmingham
 B3 1DW
 T: 0121 214 8000
 F: 0121 214 8999
 W: www.esoc.uk.com



Client: **ALBION LAND**
 Project: **Bicester Gateway**
 Drawing Title: **External Lighting Layout**

Purpose		
Drawn	Engineer	Approved
SC	CP	CP
Project No:	Date:	Scale: # A3
1463	Jul 2020	1:250
Revision:	1463-ESC-00-ZZ-DR-E-2100 T2	