
 


Antenna Aperture ID	Proposed 4G/5G Bearing	Operator: Shared/EE/H3G
A1	10°	H3G
A2	10°	H3G
B1	130°	H3G
B2	130°	H3G
C1	250°	H3G
C2	250°	H3G

NOTES:
1. ALL DIMENSIONS IN MM UNLESS OTHERWISE NOTED.

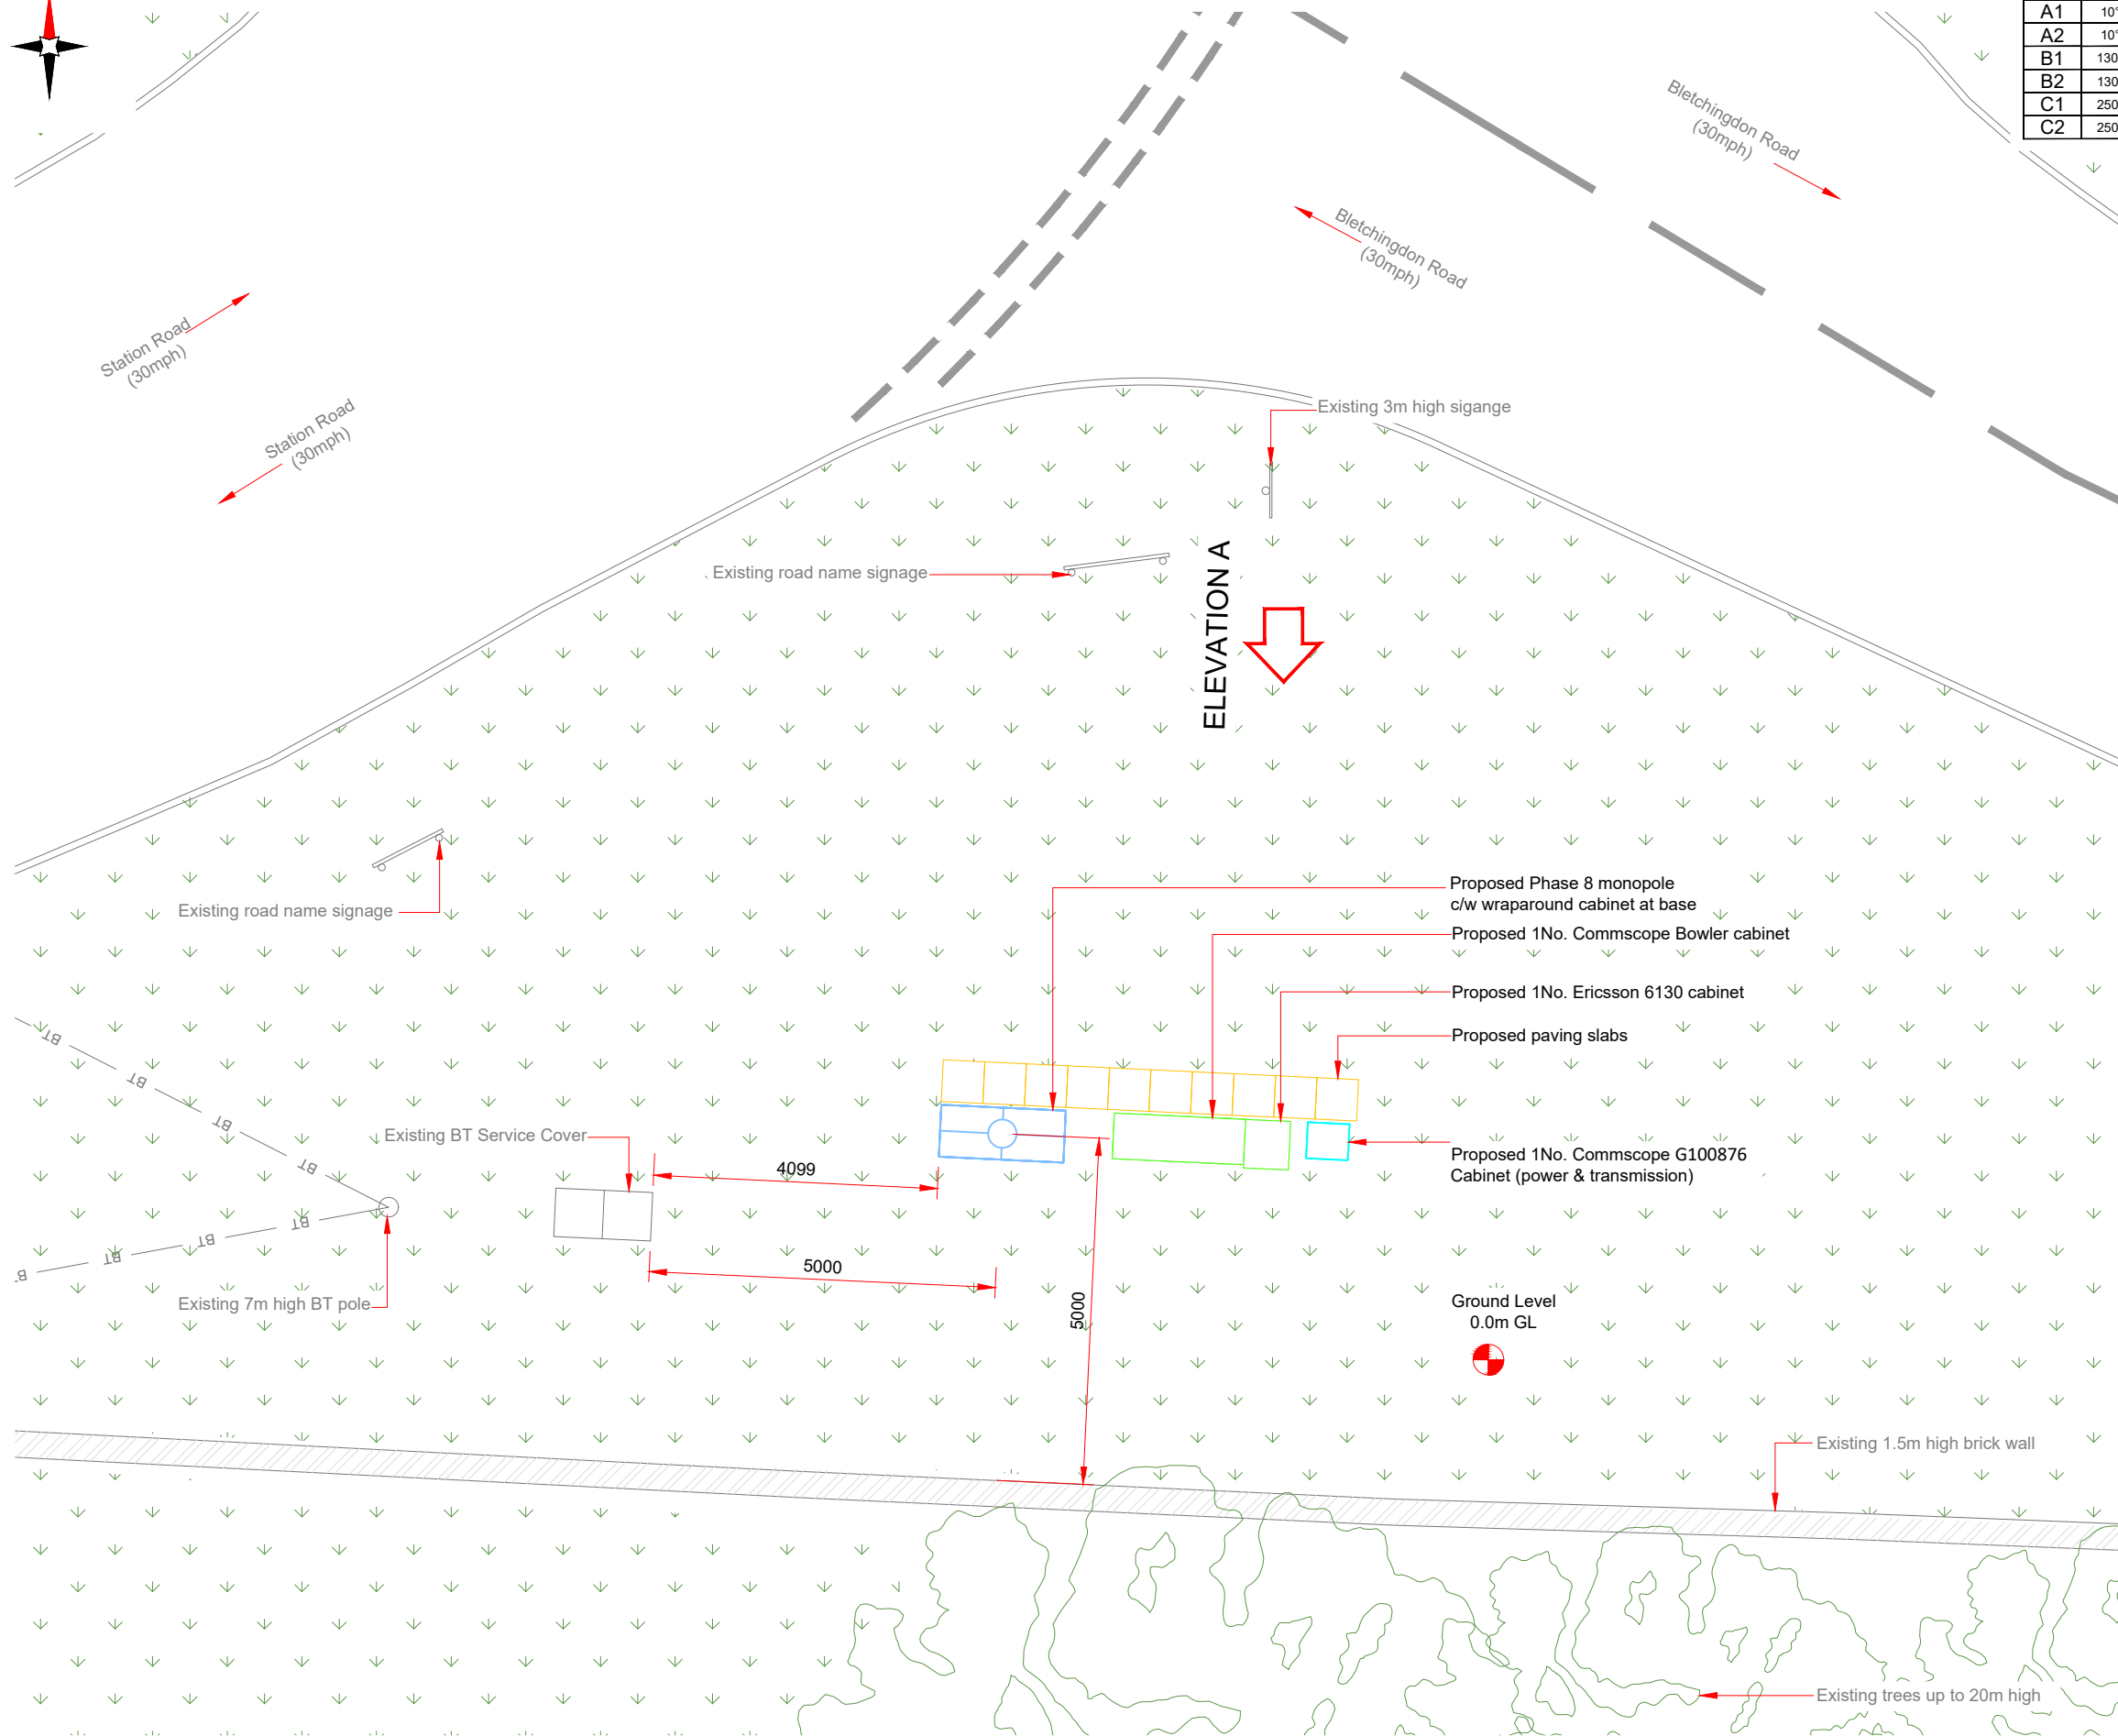

PROPOSED H3G CONFIGURATION SITE PLAN



Master: M001	MBNL / EE / H3G	Project: H3G 5G UNILATERAL	Purpose of Issue: Planning	Issue: A
Date: 07/09/2021	Revision / Upgrade Description: First Issue - Site nomination dated: 11/08/2021			
Drawn: PS				
Checked: DH				
Approved: SD				

CK Hutchison Networks (UK) Limited

Great Brighams Mead,
Vastern Road, Reading,
Berkshire, England,
RG1 8DJ

Design Consultant & Principal Contractor:



WHP Telecoms
Unit 1 Maple Park,
Low Fields Avenue, Leeds
LS12 6HH
Tel: 01133023550
e-mail: info@whptelecoms.com

Site Name:	STATION ROAD SW		
Site ID:	CWL18719		
Address:	STATION ROAD, KIRTLINGTON, CHERWELL, OXFORDSHIRE, SOUTH EAST ENGLAND, ENGLAND, OX5 3EZ		
Title:	210 PROPOSED SITE PLAN		
Project:	5G UNILATERAL		
Purpose of Issue:	PLANNING		
EE Cell ID:	MBNL Cell ID:	Cell ID:	
N/A	N/A	N/A	
Master Drawing No:	CWL18719_M001		Issue: A