 



Reproduced by permission of Ordnance Survey on behalf of the Controller of Her Majesty's Stationary Office
All rights reserved. © Crown Copyright licence no. 100022432

SITE AREA PLAN

 


SITE PHOTOGRAPH

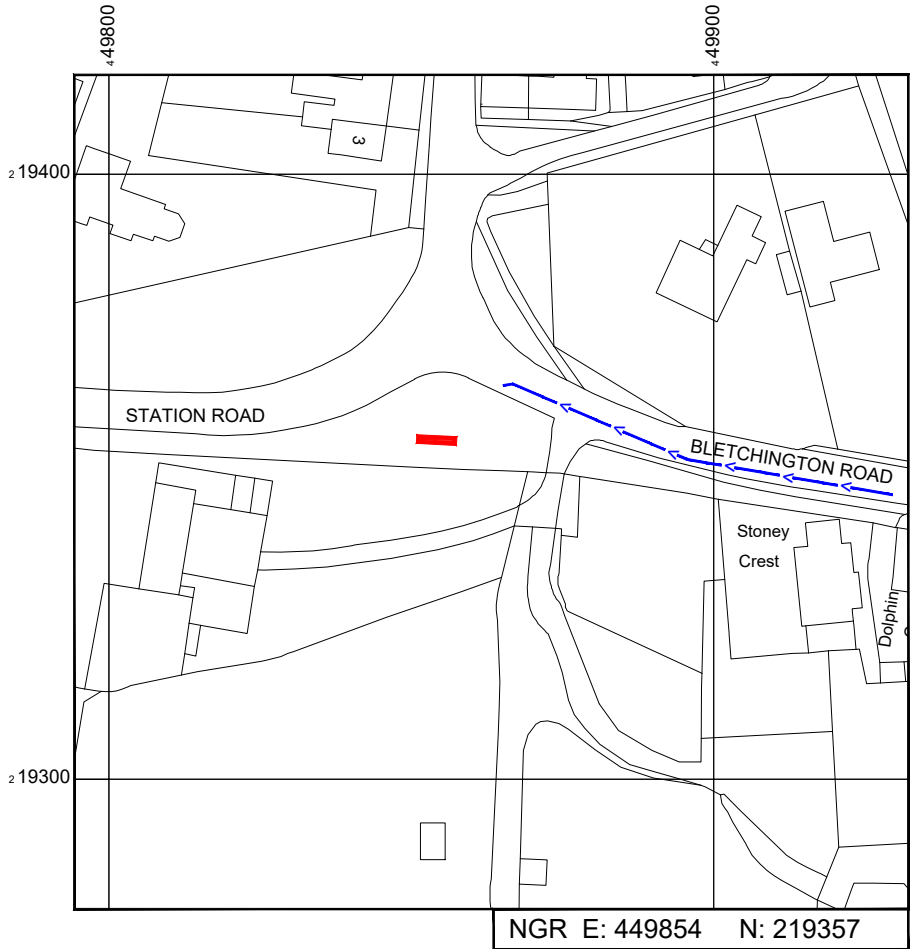

Reproduced by permission of Ordnance Survey on behalf of the Controller of Her Majesty's Stationary Office
All rights reserved. © Crown Copyright licence no. 100022432

SITE LOCATION PLAN



GOOGLE MAPS QR CODE

GOOGLE MAPS -<https://goo.gl/maps/y1WcPXSakBnyKysu6>

GOOGLE STREETVIEW -<https://goo.gl/maps/hkJmfWzxm2iTU5q1A>

NOTES:

1. ALL DIMENSIONS IN MM UNLESS OTHERWISE NOTED.

DIRECTIONS TO SITE:

Head north-west on M40, At junction 9, take the A34/A41 exit to Oxford/Newbury/Bicester, At Wendlebury Interchange, take the 1st exit onto A34, Take the B4027 exit towards Bletchington/Heathfield/Isle, Turn left onto B4027, Turn right onto Springwell Hill, Continue onto Bletchington Rd, the site is located on the left hand side on the grass verge

Site Provider's
Property Boundary:



Access Route To Site:



Access Route:



Master:	MBNL / EE / H3G:	Project:	Purpose of Issue:	Issue:
M001	MBNL	H3G 5G UNILATERAL	Planning	A
Date:	07/09/2021	Revision / Upgrade Description:		
Drawn:	PS	First Issue - Site nomination dated: 11/08/2021		
Checked:	DH			
Approved:	SD			

CK Hutchison
Networks (UK)
Limited

Great Brighams Mead,
Vastern Road, Reading,
Berkshire, England,
RG1 8DJ

Design Consultant & Principal Contractor:



WHP Telecoms

Unit 1 Maple Park,
Low Fields Avenue, Leeds
LS12 6HH

Tel: 01133023550
e-mail: info@whptelecoms.com

Site Name: STATION ROAD SW

Site ID: CWL18719


Address: STATION ROAD,
KIRTINGTON, CHERWELL,
OXFORDSHIRE,
SOUTH EAST ENGLAND,
ENGLAND,
OX5 3EZ

Title: 002 SITE LOCATION PLAN

Project: 5G UNILATERAL

Purpose of Issue: PLANNING


EE Cell ID:	MBNL Cell ID:	Cell ID:
N/A	N/A	N/A
Master Drawing No:		Issue:
CWL18719_M001		A

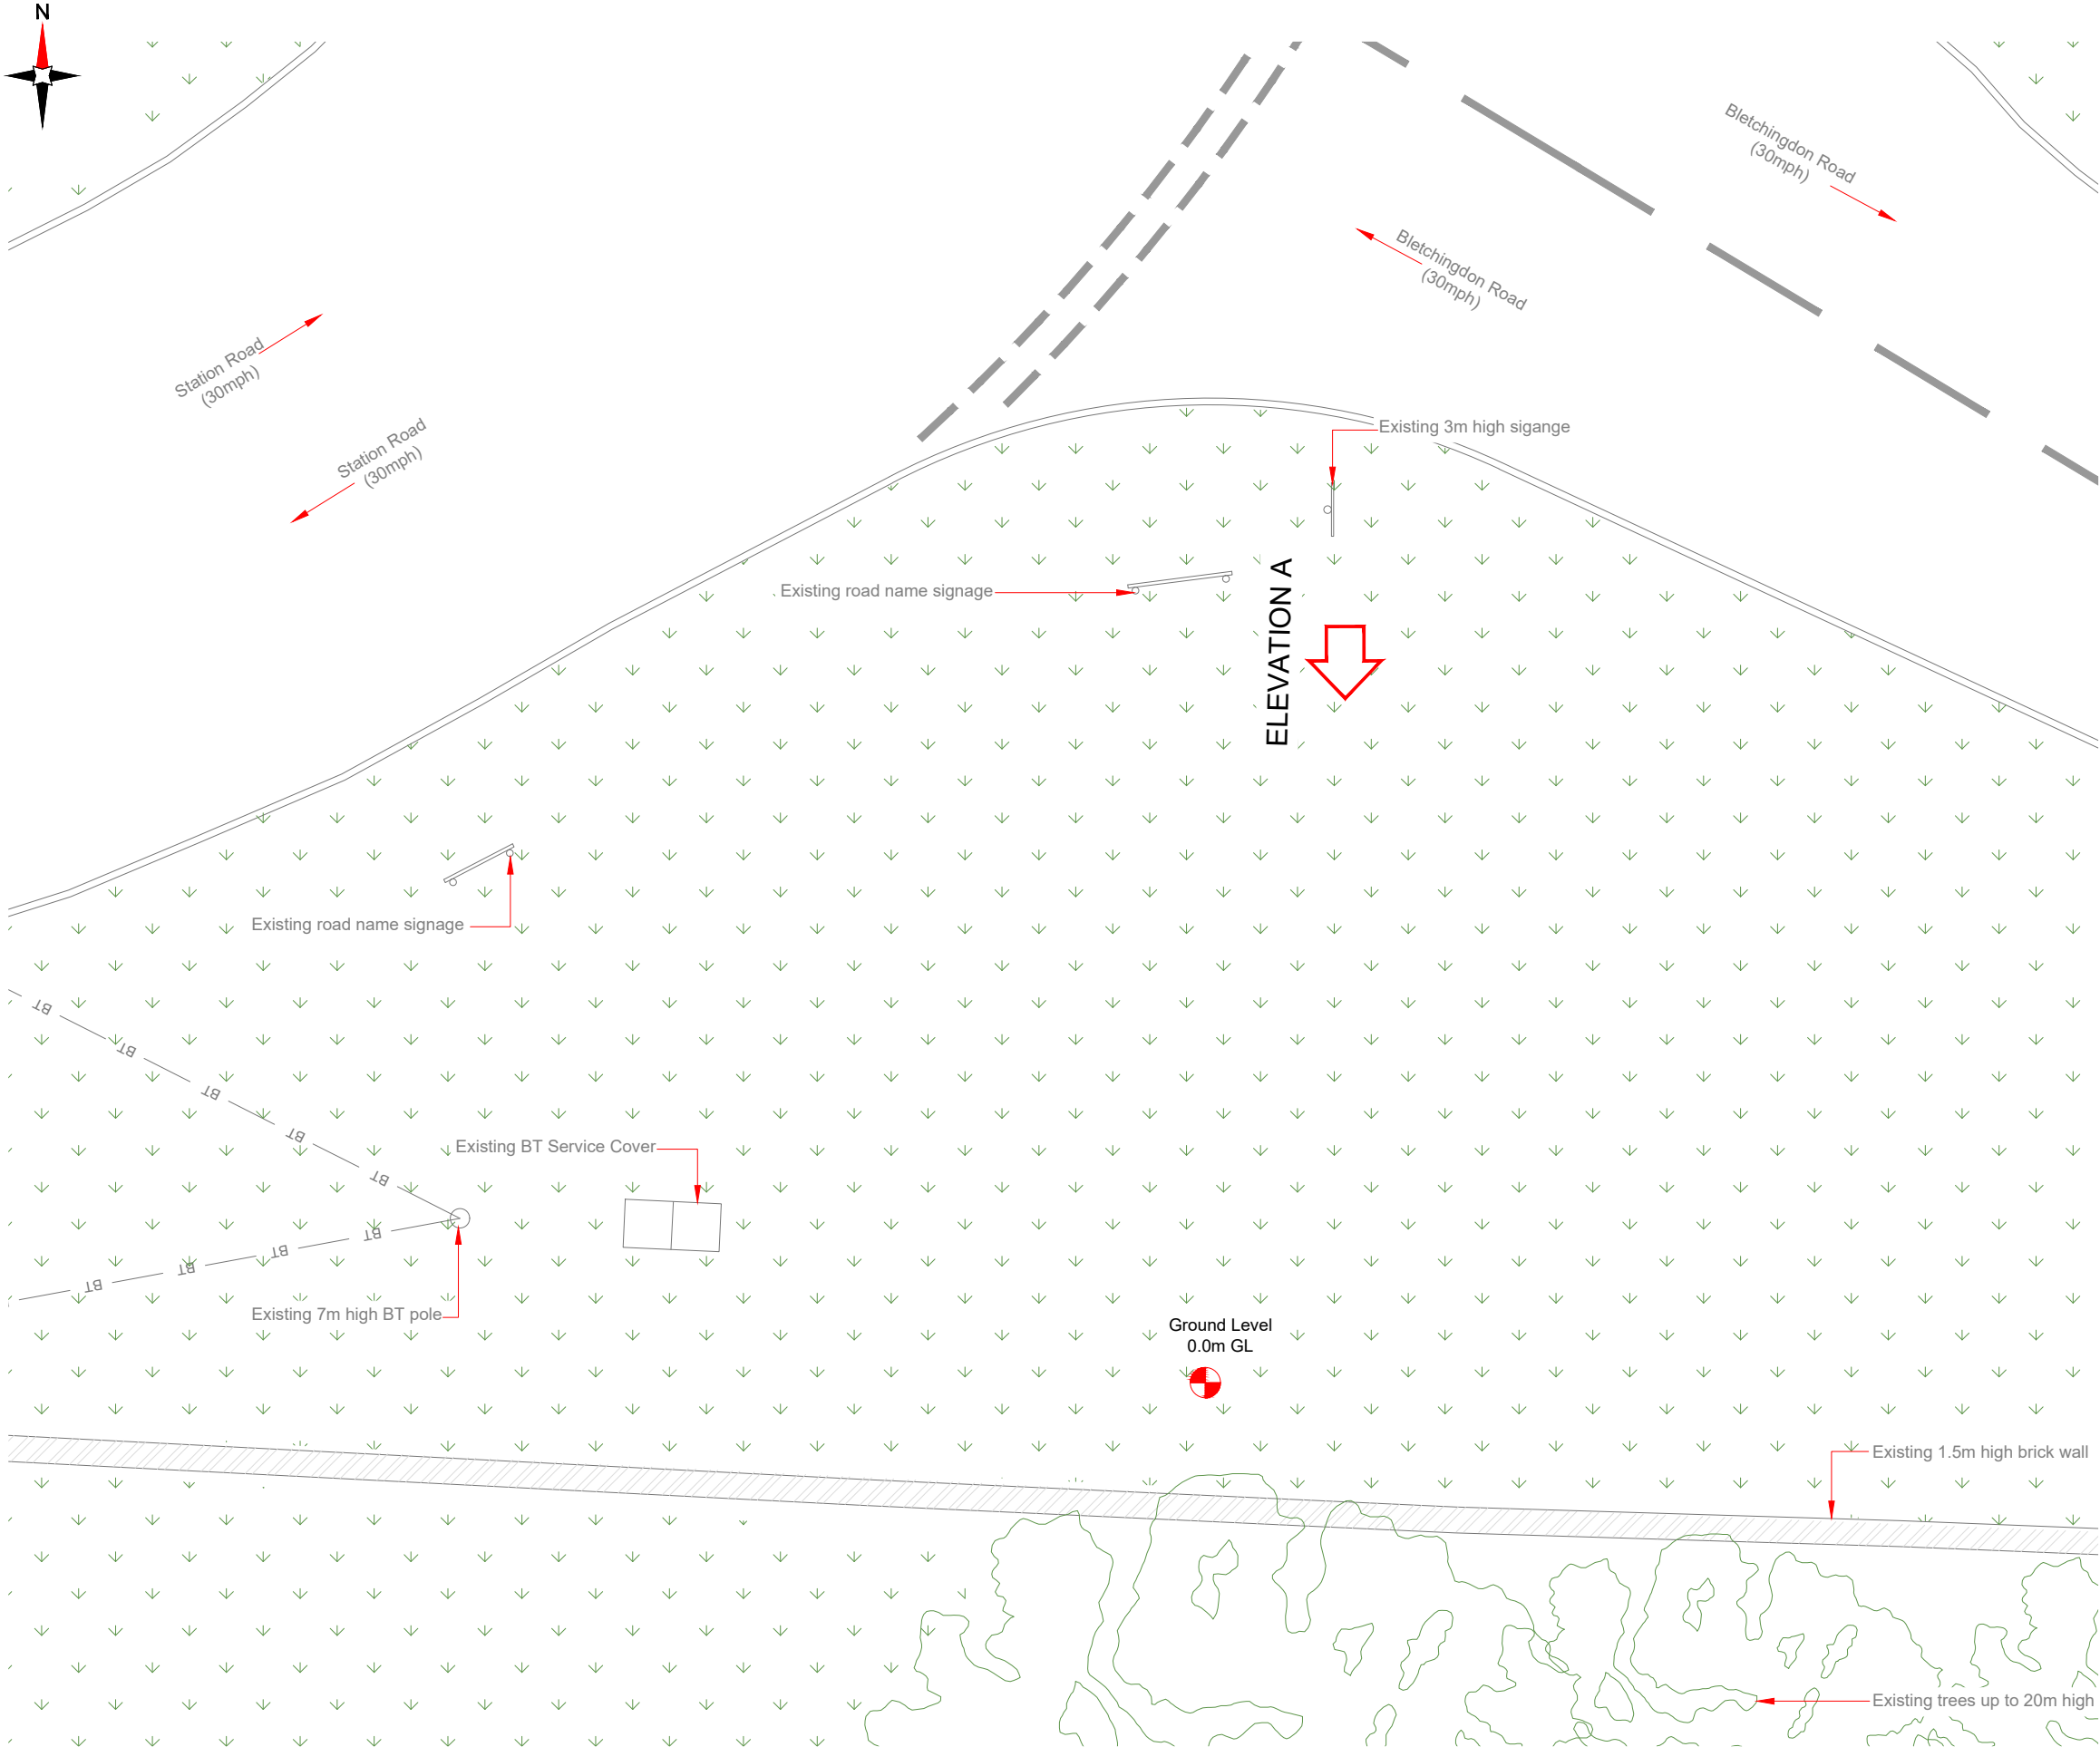

ELEVATION A



 
EXISTING SITE PLAN



NOTES:


1. ALL DIMENSIONS IN MM UNLESS OTHERWISE NOTED.

Master: M001		MBNL / EE / H3G:		Project: H3G 5G UNILATERAL		Purpose of Issue: Planning		Issue: A	
Date: 07/09/2021		Drawn: PS		Checked: DH		Approved: SD		Revision / Upgrade Description: First Issue - Site nomination dated: 11/08/2021	
<div><div>CK Hutchison Networks (UK) Limited</div><div>Great Brighams Mead, Vastern Road, Reading, Berkshire, England, RG1 8DJ</div></div>									
<div><div></div><div><div>Design Consultant & Principal Contractor:</div><div>WHP Telecoms Unit 1 Maple Park, Low Fields Avenue, Leeds LS12 6HH Tel: 01133023550 e-mail: info@whptelecoms.com</div></div></div>									
Site Name:		STATION ROAD SW							
Site ID:		CWL18719							
Address:		STATION ROAD, KIRTLINGTON, CHERWELL, OXFORDSHIRE, SOUTH EAST ENGLAND, ENGLAND, OX5 3EZ							
Title:		100 EXISTING SITE PLAN							
Project:		5G UNILATERAL							
Purpose of Issue:		PLANNING							
EE Cell ID: N/A		MBNL Cell ID: N/A		Cell ID: N/A					
Master Drawing No: CWL18719_M001								Issue: A	

100mm

50mm

10mm

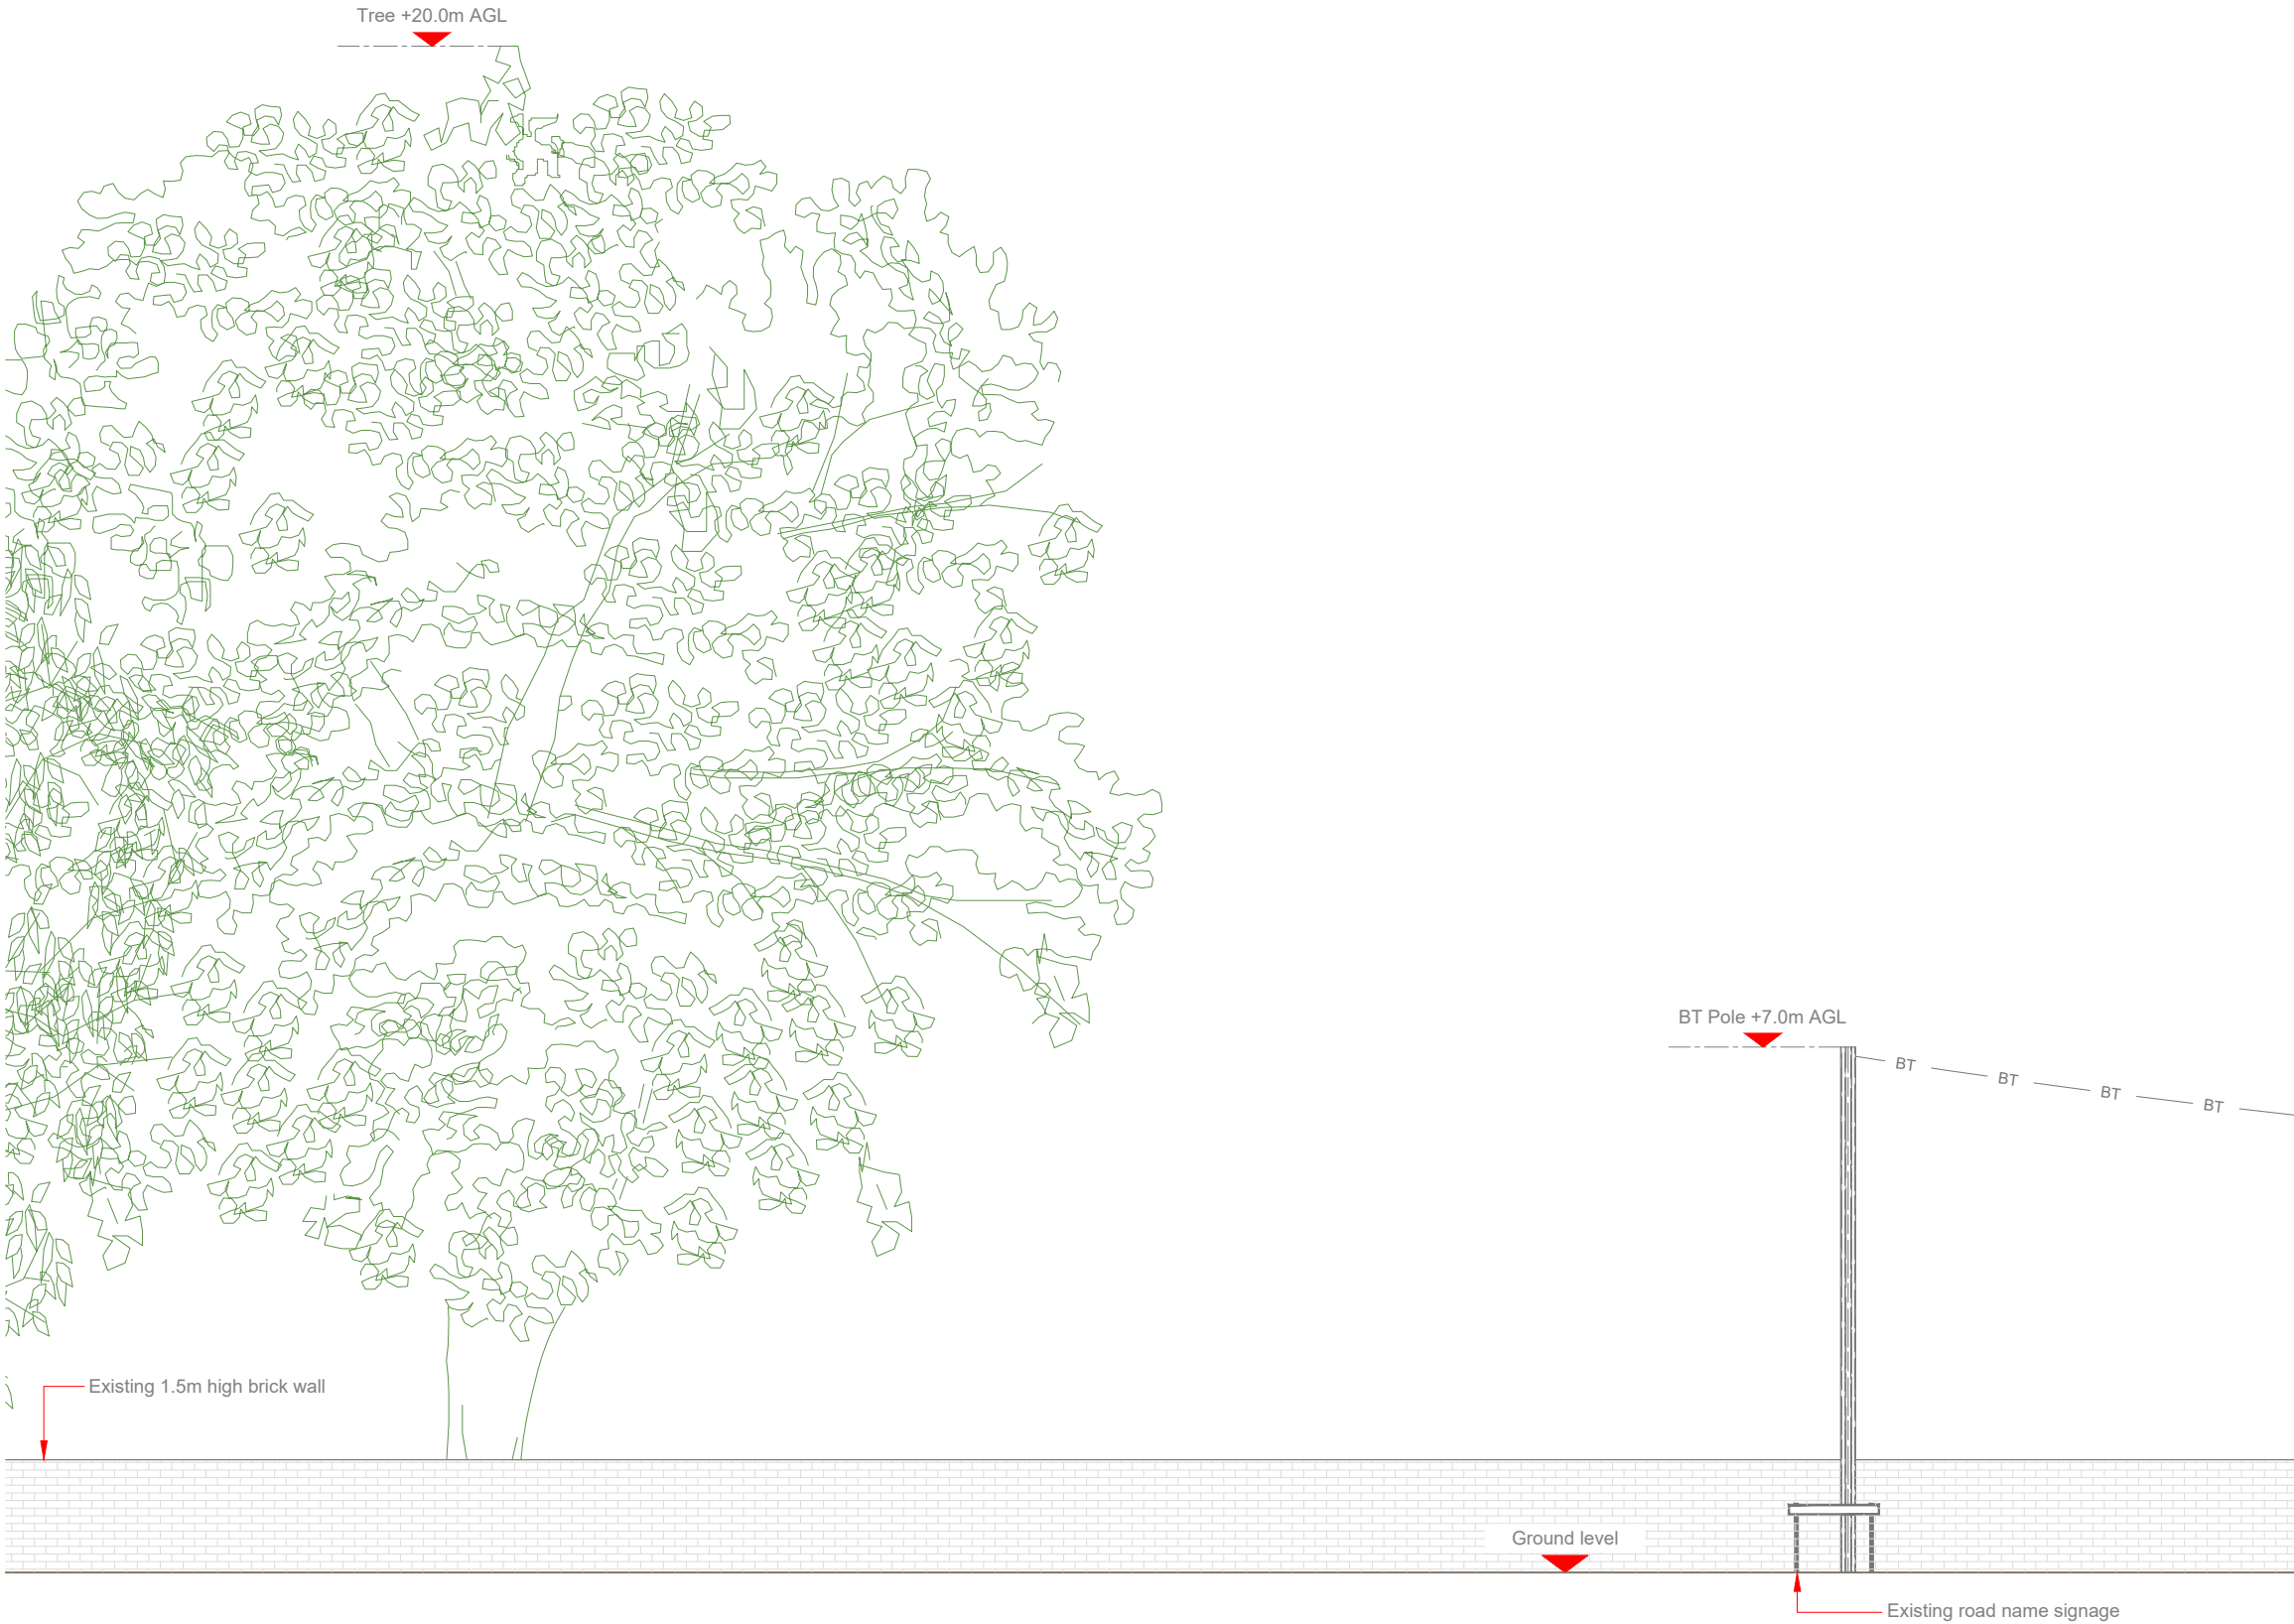

- NOTES:
- ALL DIMENSIONS IN MM UNLESS OTHERWISE NOTED.

Master:	MBNL / EE / H3G:	Project:	Purpose of Issue:	Issue:
M001	MBNL	H3G 5G UNILATERAL	Planning	A
Date:	07/09/2021	Revision / Upgrade Description:		
Drawn:	PS	First Issue - Site nomination dated: 11/08/2021		
Checked:	DH			
Approved:	SD			

CK Hutchison
Networks (UK)
Limited

Great Brighams Mead,
Vastern Road, Reading,
Berkshire, England,
RG1 8DJ

Design Consultant & Principal Contractor:



WHP Telecoms
Unit 1 Maple Park,
Low Fields Avenue, Leeds
LS12 6HH

Tel: 01133023550
e-mail: info@whptelecoms.com

Site Name: STATION ROAD SW

Site ID: CWL18719

Address: STATION ROAD,
KIRTLINGTON, CHERWELL,
OXFORDSHIRE,
SOUTH EAST ENGLAND,
ENGLAND,
OX5 3EZ

Title: 150 EXISTING ELEVATION A

Project: 5G UNILATERAL


Purpose of Issue: PLANNING

EE Cell ID:	MBNL Cell ID:	Cell ID:
N/A	N/A	N/A
Master Drawing No: CWL18719_M001		
Issue: A		




Antenna Aperture ID	Proposed 4G/5G Bearing	Operator: Shared/ EE/H3G
A1	10°	H3G
A2	10°	H3G
B1	130°	H3G
B2	130°	H3G
C1	250°	H3G
C2	250°	H3G


NOTES:
1. ALL DIMENSIONS IN MM UNLESS OTHERWISE NOTED.

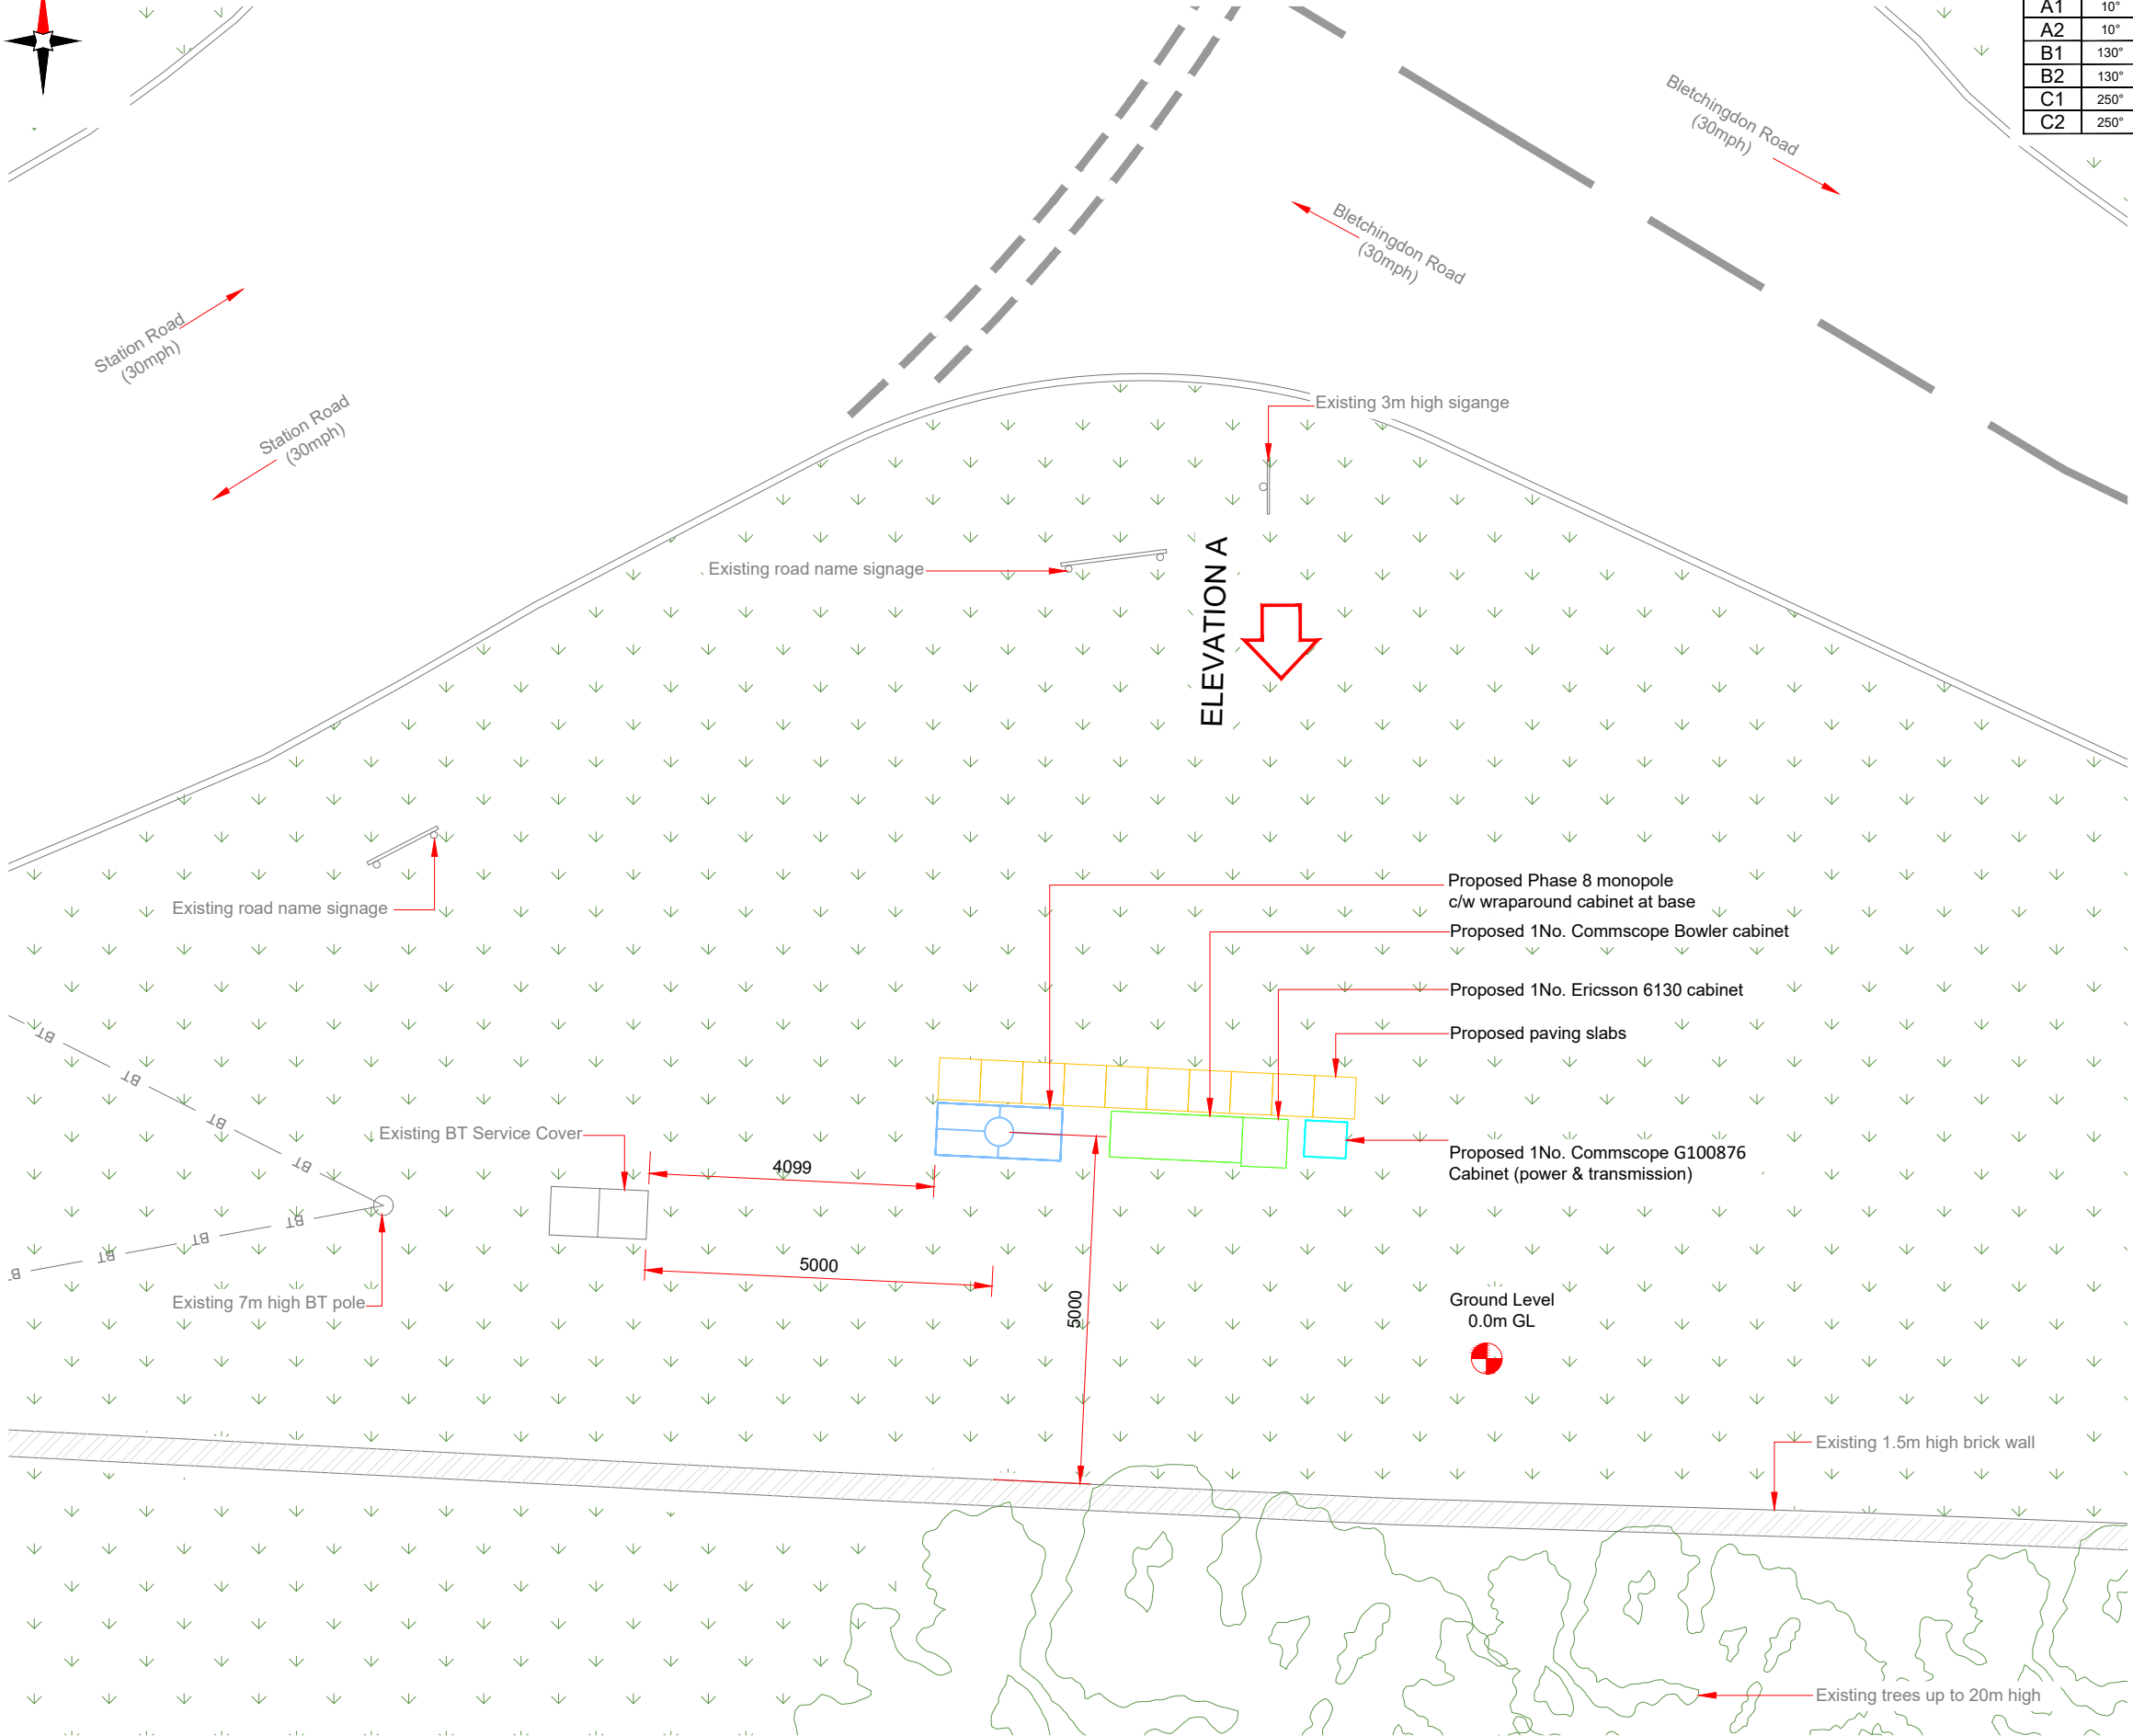

PROPOSED H3G CONFIGURATION SITE PLAN

 

Master: M001	MBNL / EE / H3G:	Project: H3G 5G UNILATERAL	Purpose of Issue: Planning	Issue: A
Date: 07/09/2021	Drawn: PS	Revision / Upgrade Description: First Issue - Site nomination dated: 11/08/2021		
Checked: DH	Approved: SD			
<div>CK Hutchison Networks (UK) Limited Great Brighams Mead, Vastern Road, Reading, Berkshire, England, RG1 8DJ</div>				
<div>Design Consultant & Principal Contractor:  WHP Telecoms Unit 1 Maple Park, Low Fields Avenue, Leeds LS12 6HH Tel: 01133023550 e-mail: info@whptelecoms.com</div>				
Site Name: STATION ROAD SW				
Site ID: CWL18719				
Address: STATION ROAD, KIRTLINGTON, CHERWELL, OXFORDSHIRE, SOUTH EAST ENGLAND, ENGLAND, OX5 3EZ				
Title: 210 PROPOSED SITE PLAN				
Project: 5G UNILATERAL				
Purpose of Issue: PLANNING				
EE Cell ID: N/A	MBNL Cell ID: N/A	Cell ID: N/A		
Master Drawing No: CWL18719_M001				Issue: A

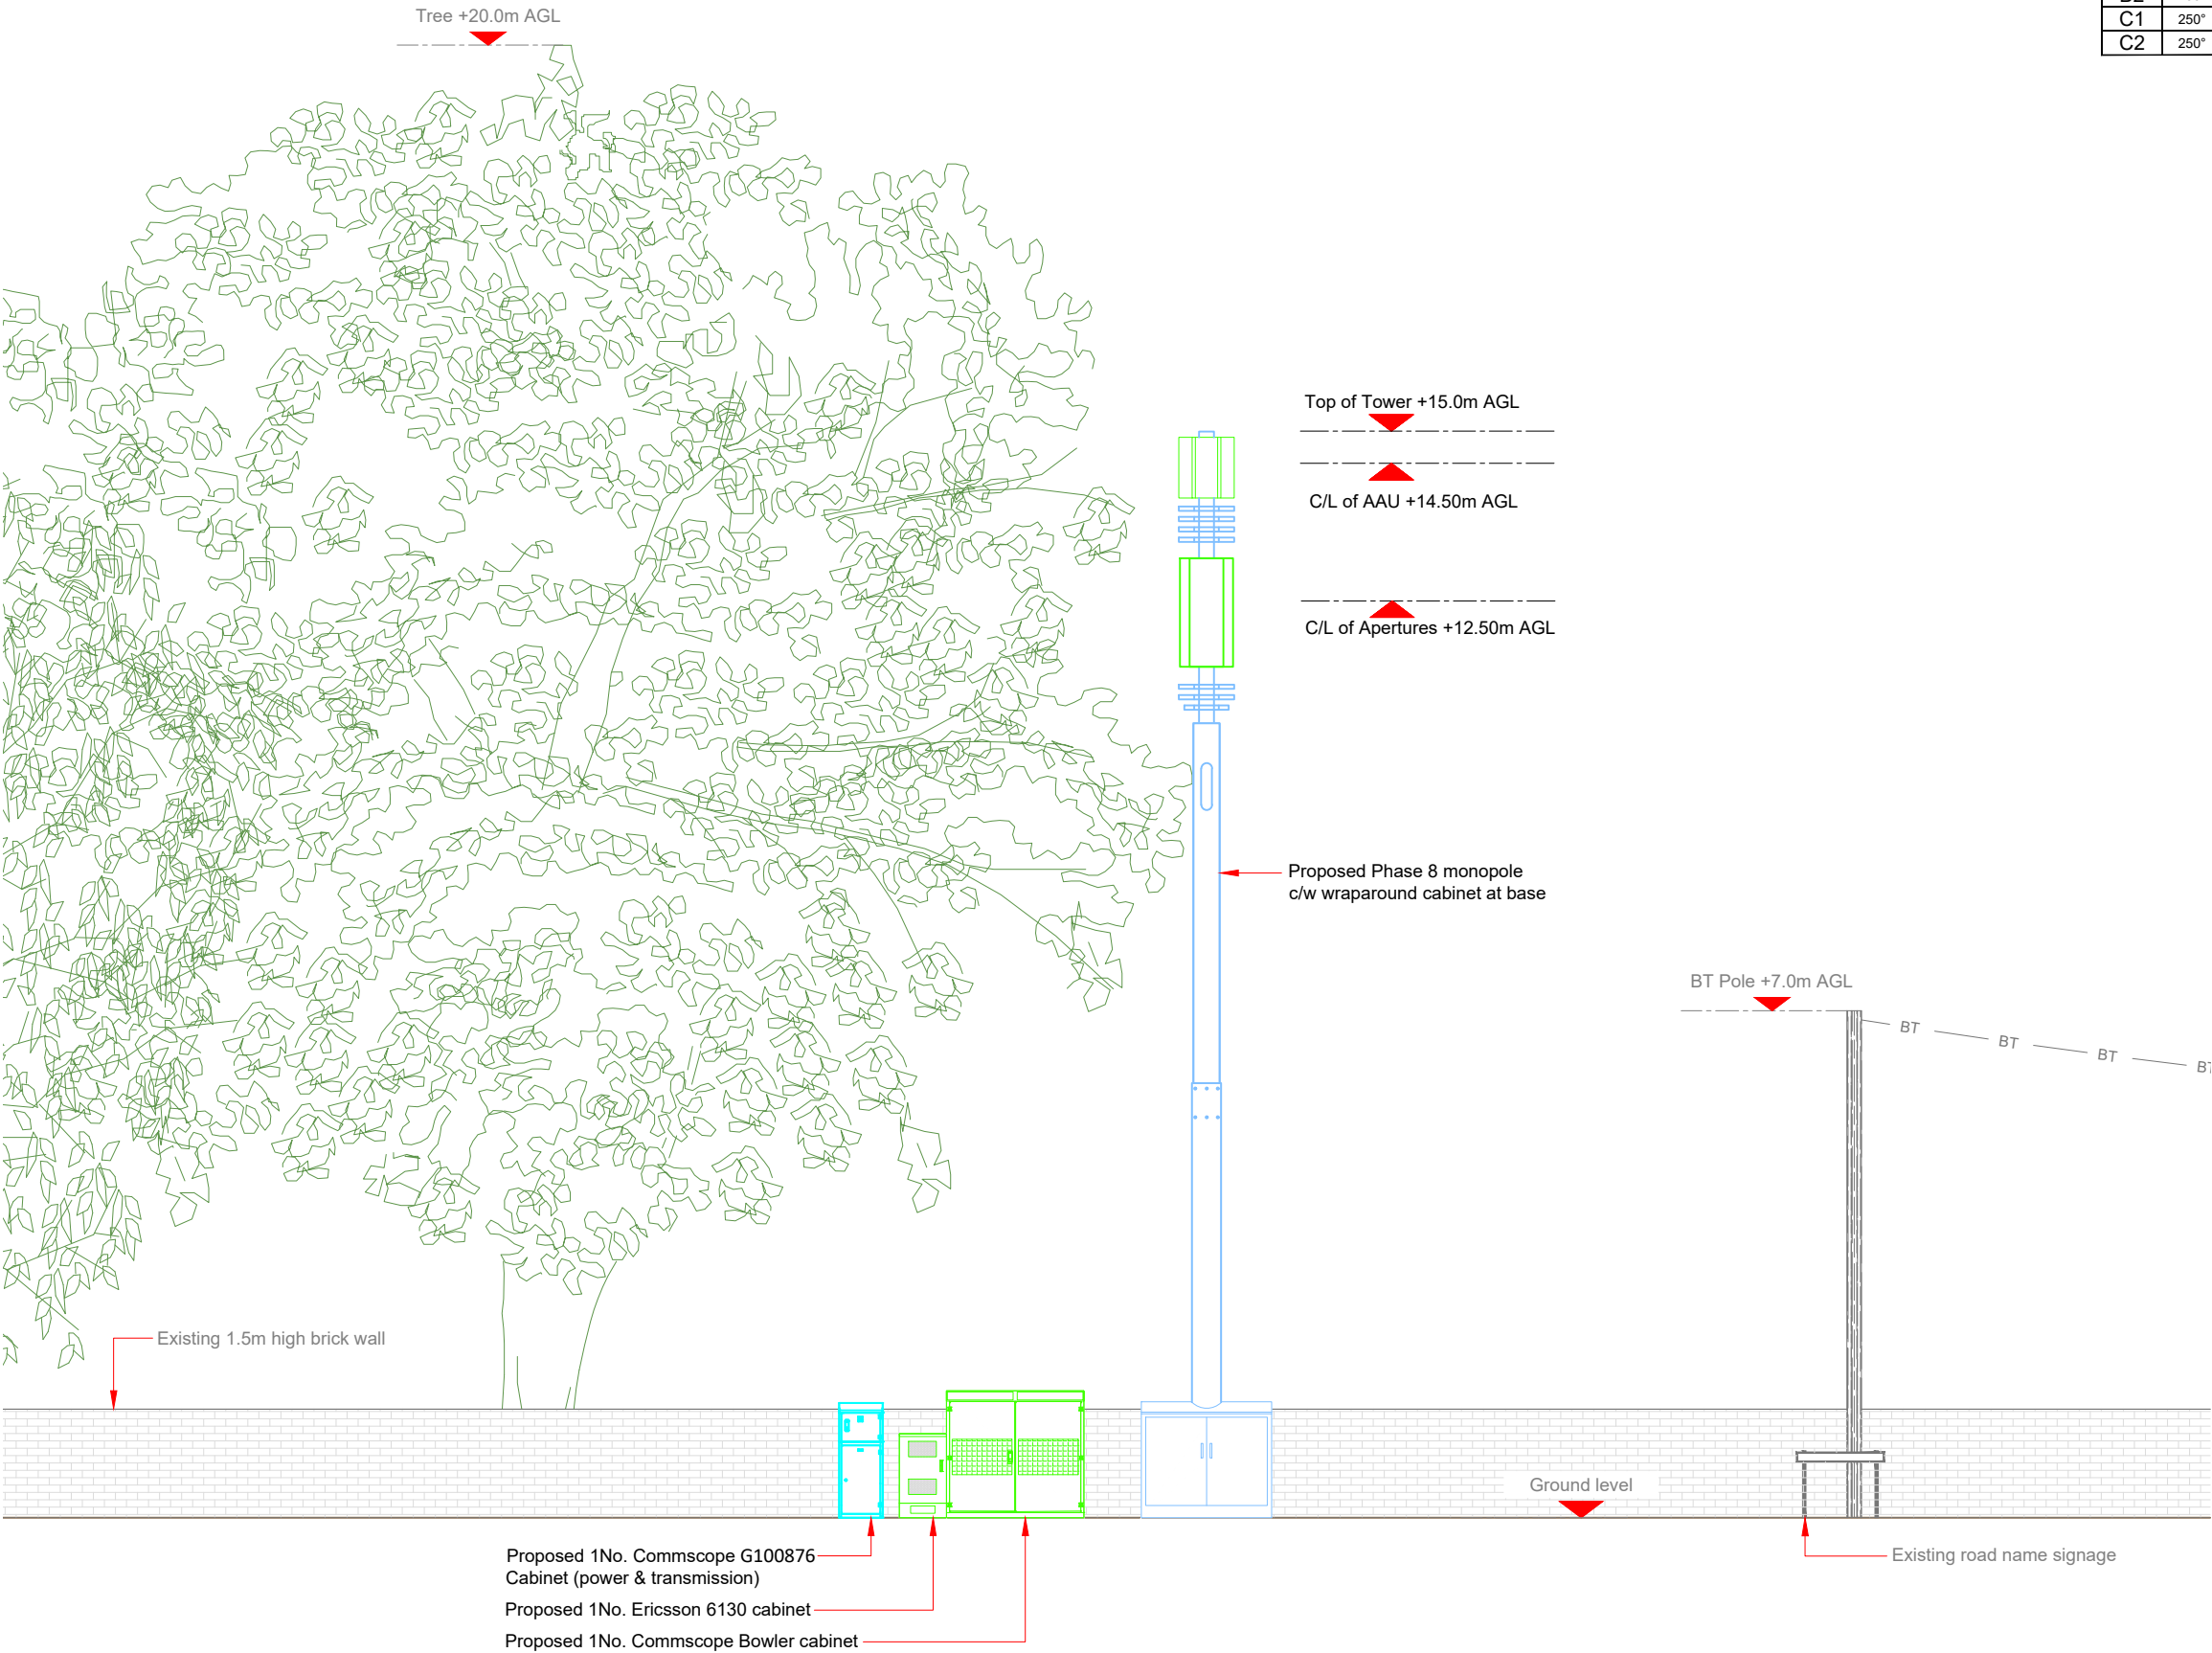

Antenna Aperture ID	Proposed 4G/5G Bearing	Operator: Shared/ EE/H3G
A1	10°	H3G
A2	10°	H3G
B1	130°	H3G
B2	130°	H3G
C1	250°	H3G
C2	250°	H3G


NOTES:
1. ALL DIMENSIONS IN MM UNLESS OTHERWISE NOTED.

Master:	MBNL / EE / H3G:	Project:	Purpose of Issue:	Issue:
M001	MBNL	H3G 5G UNILATERAL	Planning	A
Date:	07/09/2021	Revision / Upgrade Description:		
Drawn:	PS	First Issue - Site nomination dated: 11/08/2021		
Checked:	DH			
Approved:	SD			

CK Hutchison Networks (UK) Limited

Great Brighams Mead,
Vastern Road, Reading,
Berkshire, England,
RG1 8DJ

Design Consultant & Principal Contractor:



WHP Telecoms
Unit 1 Maple Park,
Low Fields Avenue, Leeds
LS12 6HH
Tel: 01133023550
e-mail: info@whptelecoms.com

Site Name: **STATION ROAD SW**

Site ID: **CWL18719**

Address: **STATION ROAD,
KIRTLINGTON, CHERWELL,
OXFORDSHIRE,
SOUTH EAST ENGLAND,
ENGLAND,
OX5 3EZ**

Title: **260 PROPOSED ELEVATION**

Project: **5G UNILATERAL**

Purpose of Issue: **PLANNING**

EE Cell ID:	MBNL Cell ID:	Cell ID:
N/A	N/A	N/A
Master Drawing No: CWL18719_M001		
Issue: A		