


— Mansafe system to specialists design
 Roof lights to achieve min 12% of ground floor full height warehouse space GIA

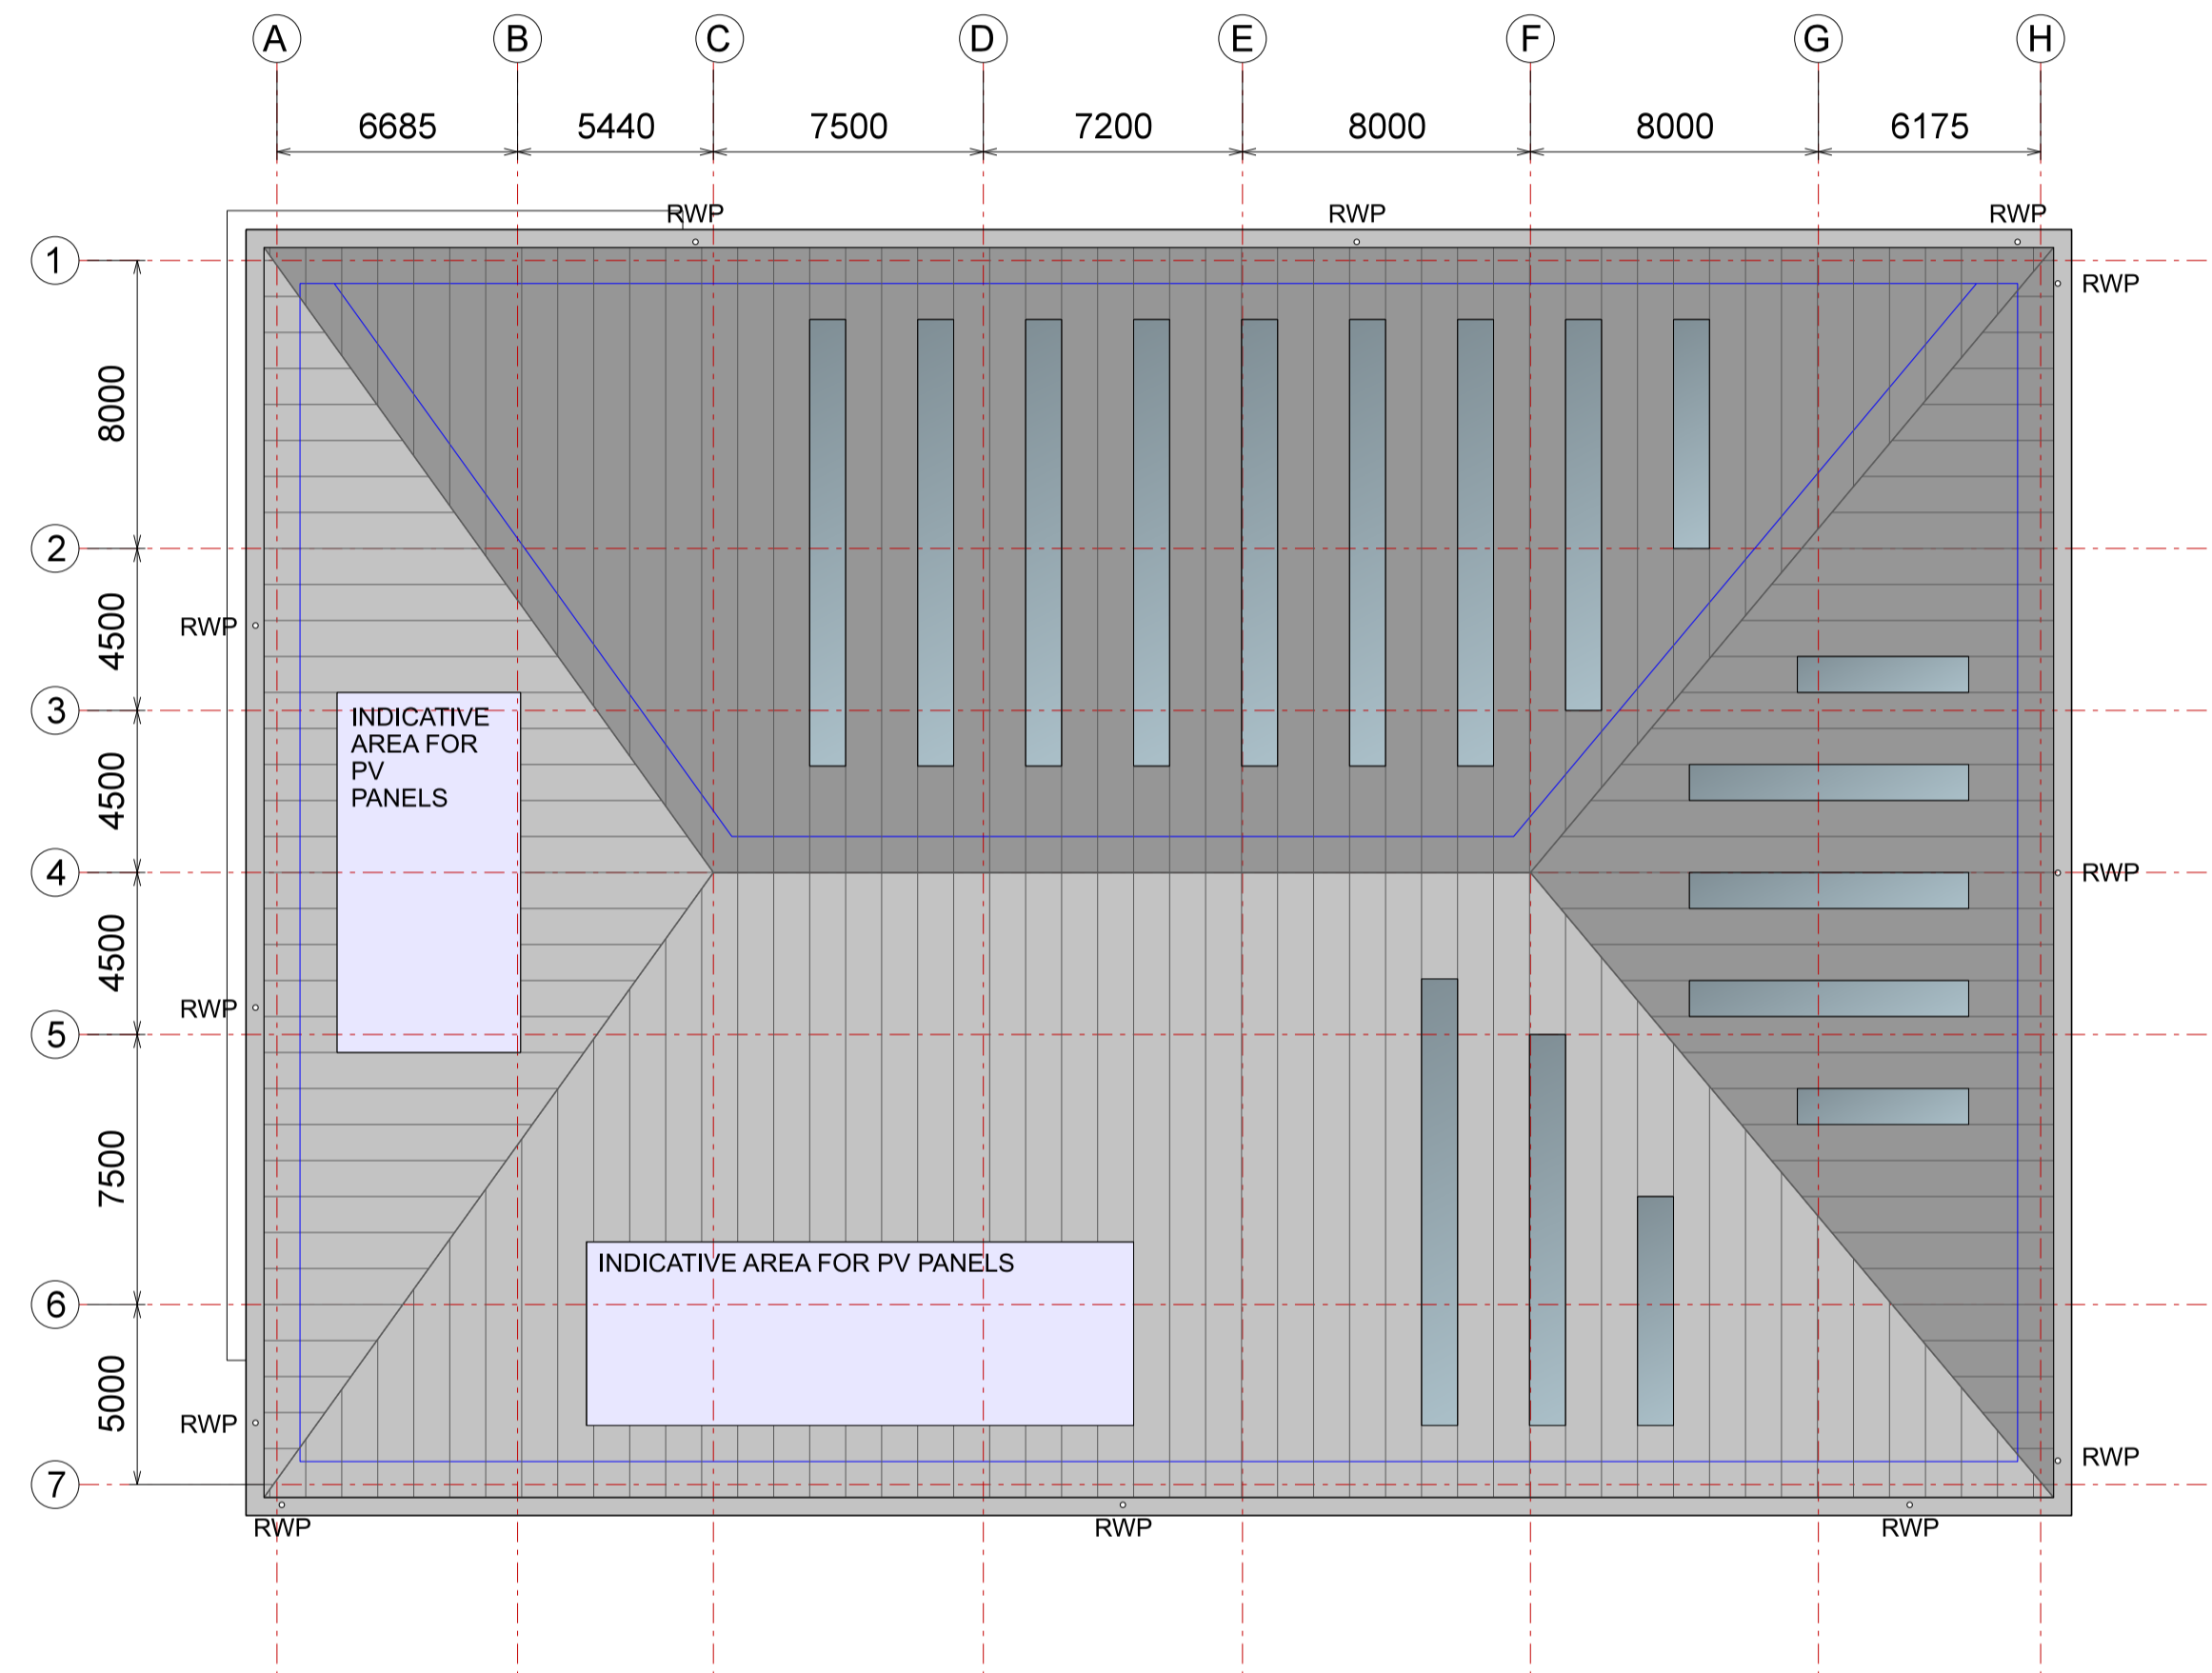

1 Unit 5a
 003 Roof Plan

Rev	Description	Chk	Date
-----	-------------	-----	------

Peer House
 8 -14 Verulam Street
 London WC1X 8LZ

tel +44(0)20 7400 2120

enquiries@cornisharchitects.com
 www.cornisharchitects.com



cornisharchitects

Project Title. **CATALYST PHASE 2**

Drawing Title. **UNIT 5A ROOF PLAN**

Drawing Status. **TOWN PLANNING**



Drawn By:	Scale:	Date:	Chk'd By:
C B	1:200 @ A1	07/03/2022	S M



Drawing No.	Rev.
21023 - TP - 003	-