


— Mansafe system to specialists design
 Roof lights to achieve min 12% of ground floor full height warehouse space GIA

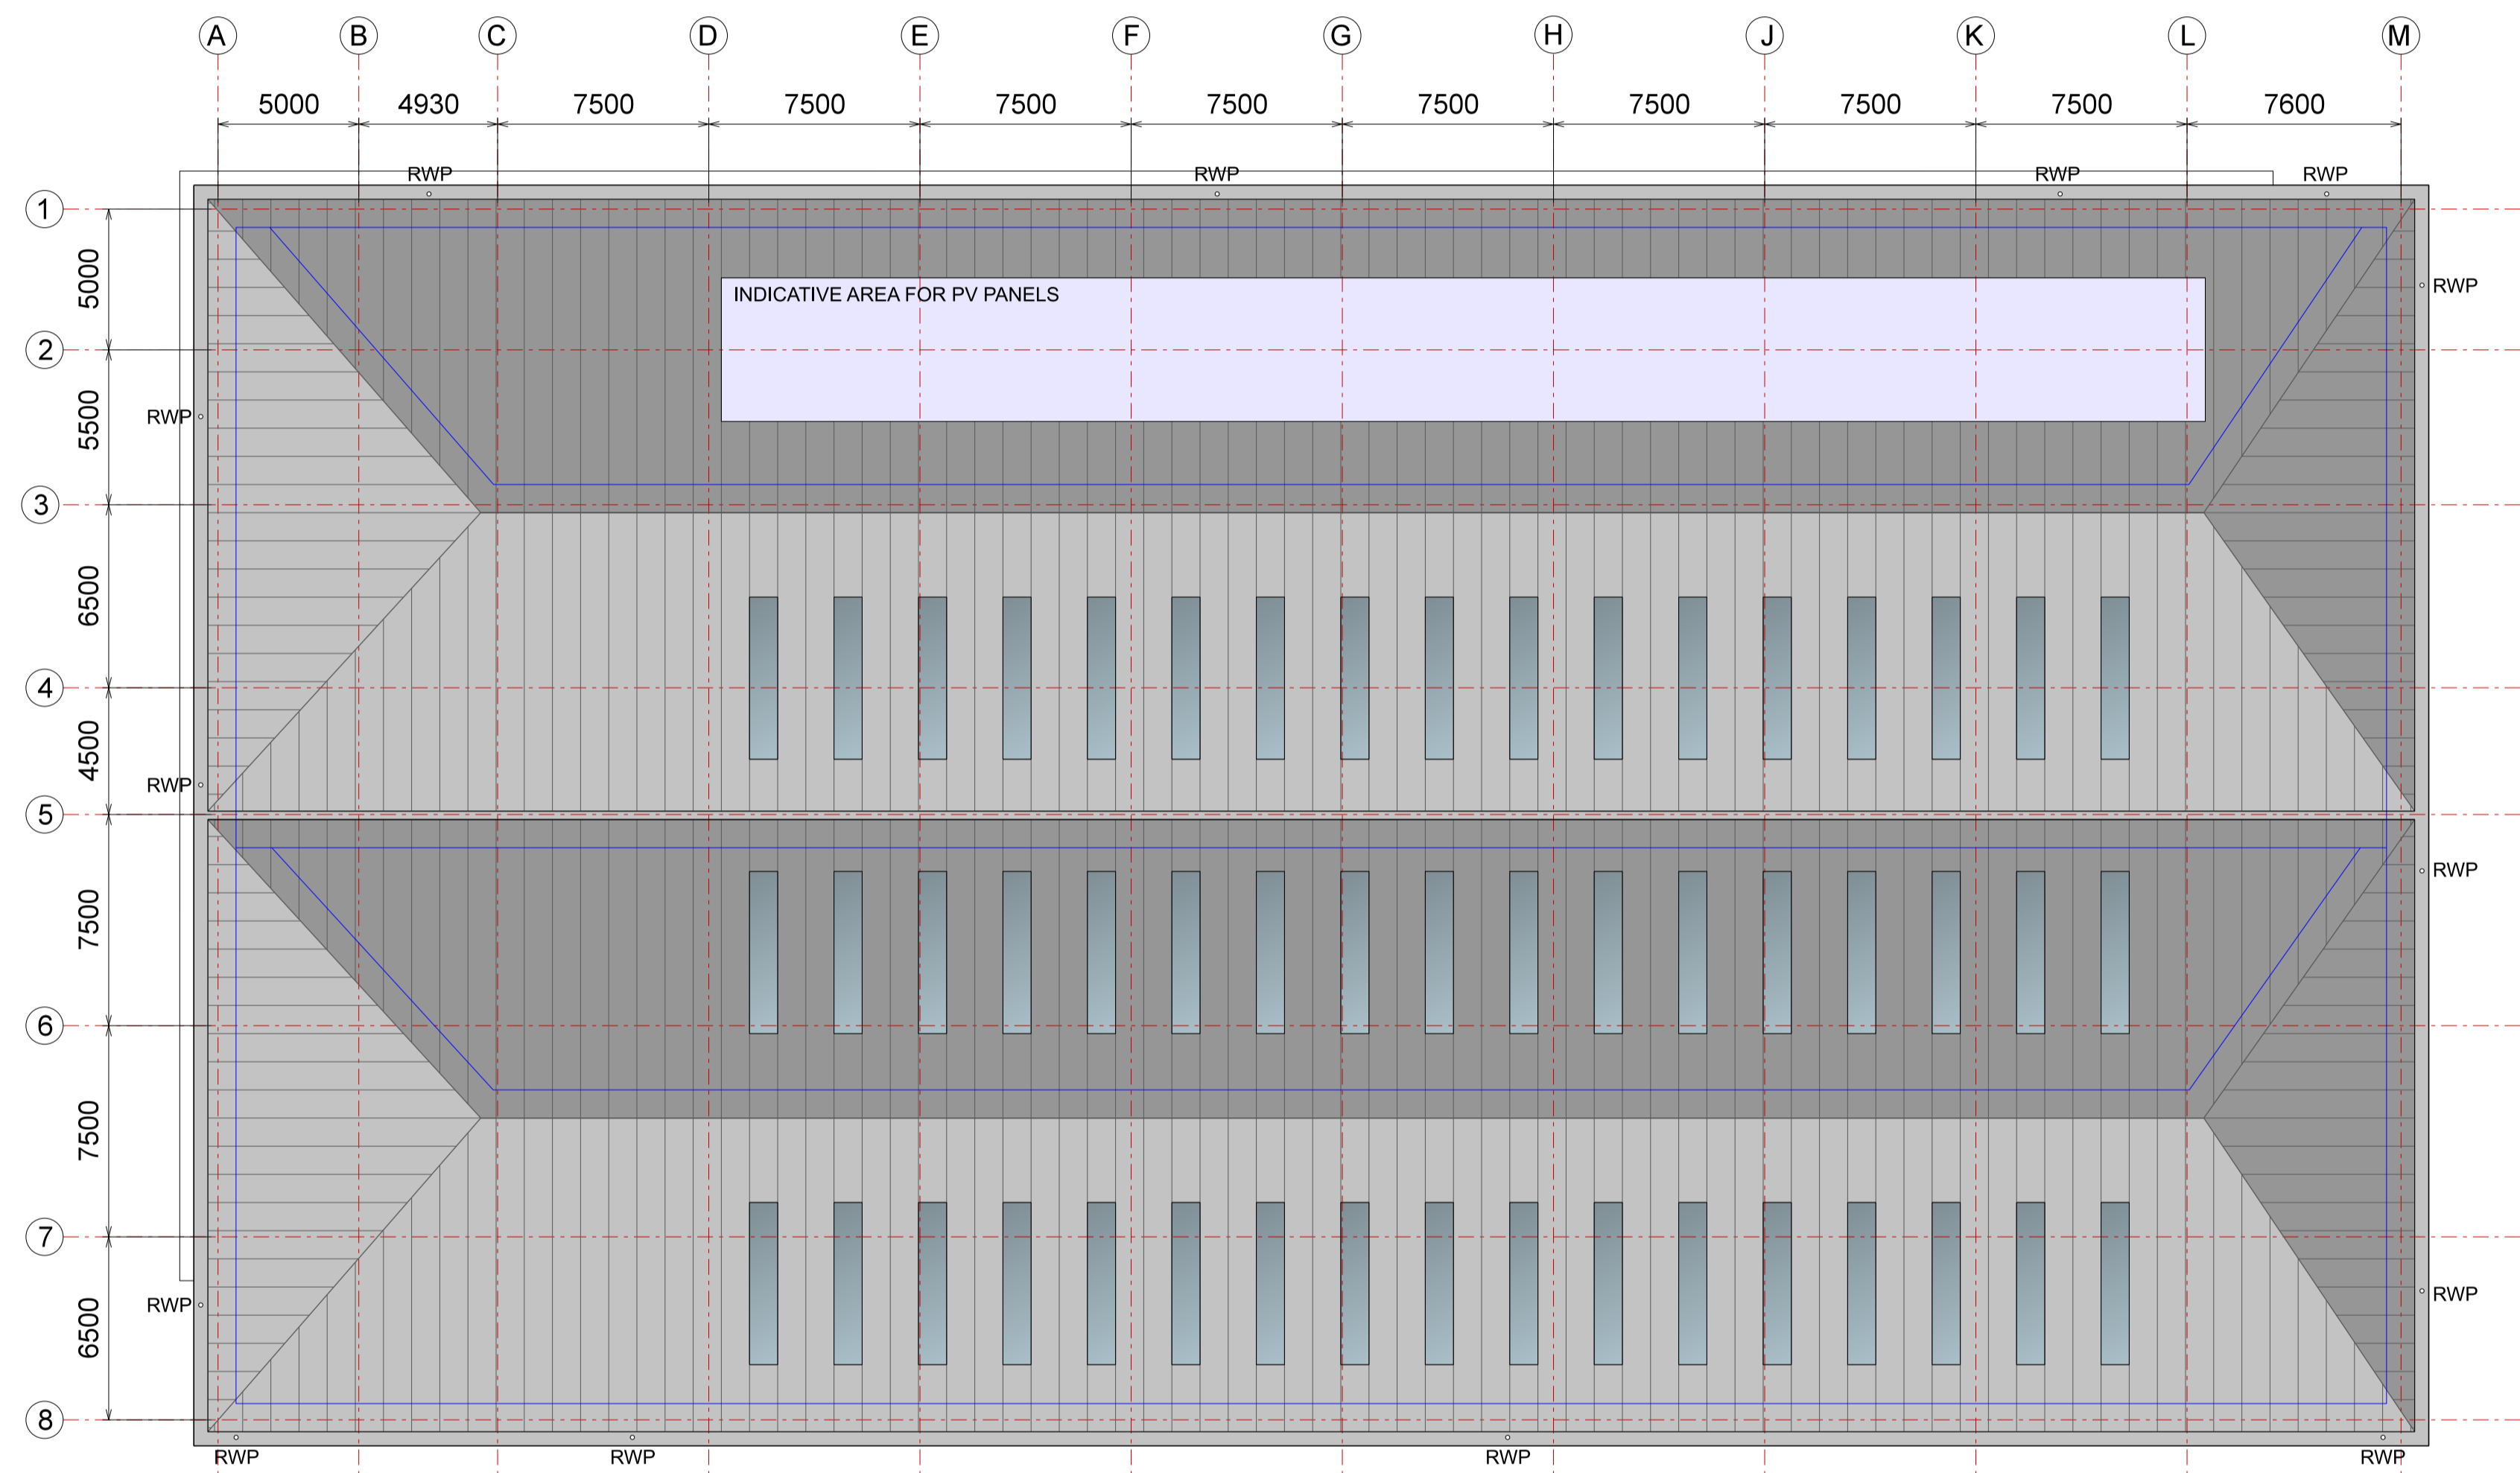

1 Unit 5b
 007 Roof Plan

Rev	Description	Chk	Date
-----	-------------	-----	------

Peer House
 8 -14 Verulam Street
 London WC1X 8LZ

tel +44(0)20 7400 2120

enquiries@cornisharchitects.com
 www.cornisharchitects.com

RIBA
 Chartered Practice

cornisharchitects

Project Title. CATALYST PHASE 2

Drawing Title. UNIT 5B ROOF PLAN

Drawing Status. TOWN PLANNING

Scale. 0 2 16 metres

Drawn By	Scale	Date	Chk'd By
R P	1:200 @ A1	07/03/2022	S M

ALBION LAND

Drawing No. 21023 - TP - 007 Rev. -