



**West Elevation**  
1 : 100



**North Elevation**  
1 : 100





**East Elevation**  
1 : 100




**South Elevation**  
1 : 100




This drawing is the property of Digi Design Co Architecture Ltd. Copyright is reserved by them and the drawing is issued on the condition that it is not used, copied, reproduced, retained or disclosed either wholly or in part, by or to any unauthorised persons, without previous consent in writing of Digi Design Co Architecture Ltd.

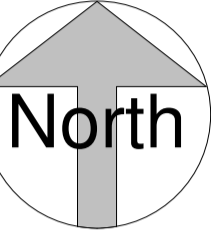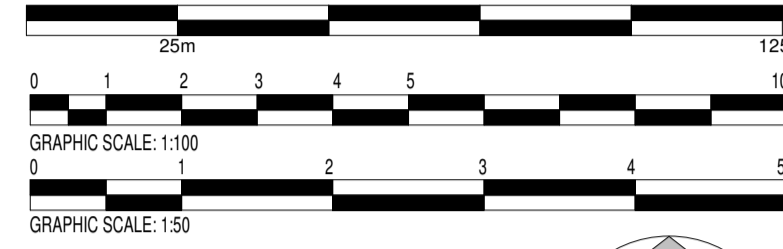

**Location Plan**  
1 : 1250

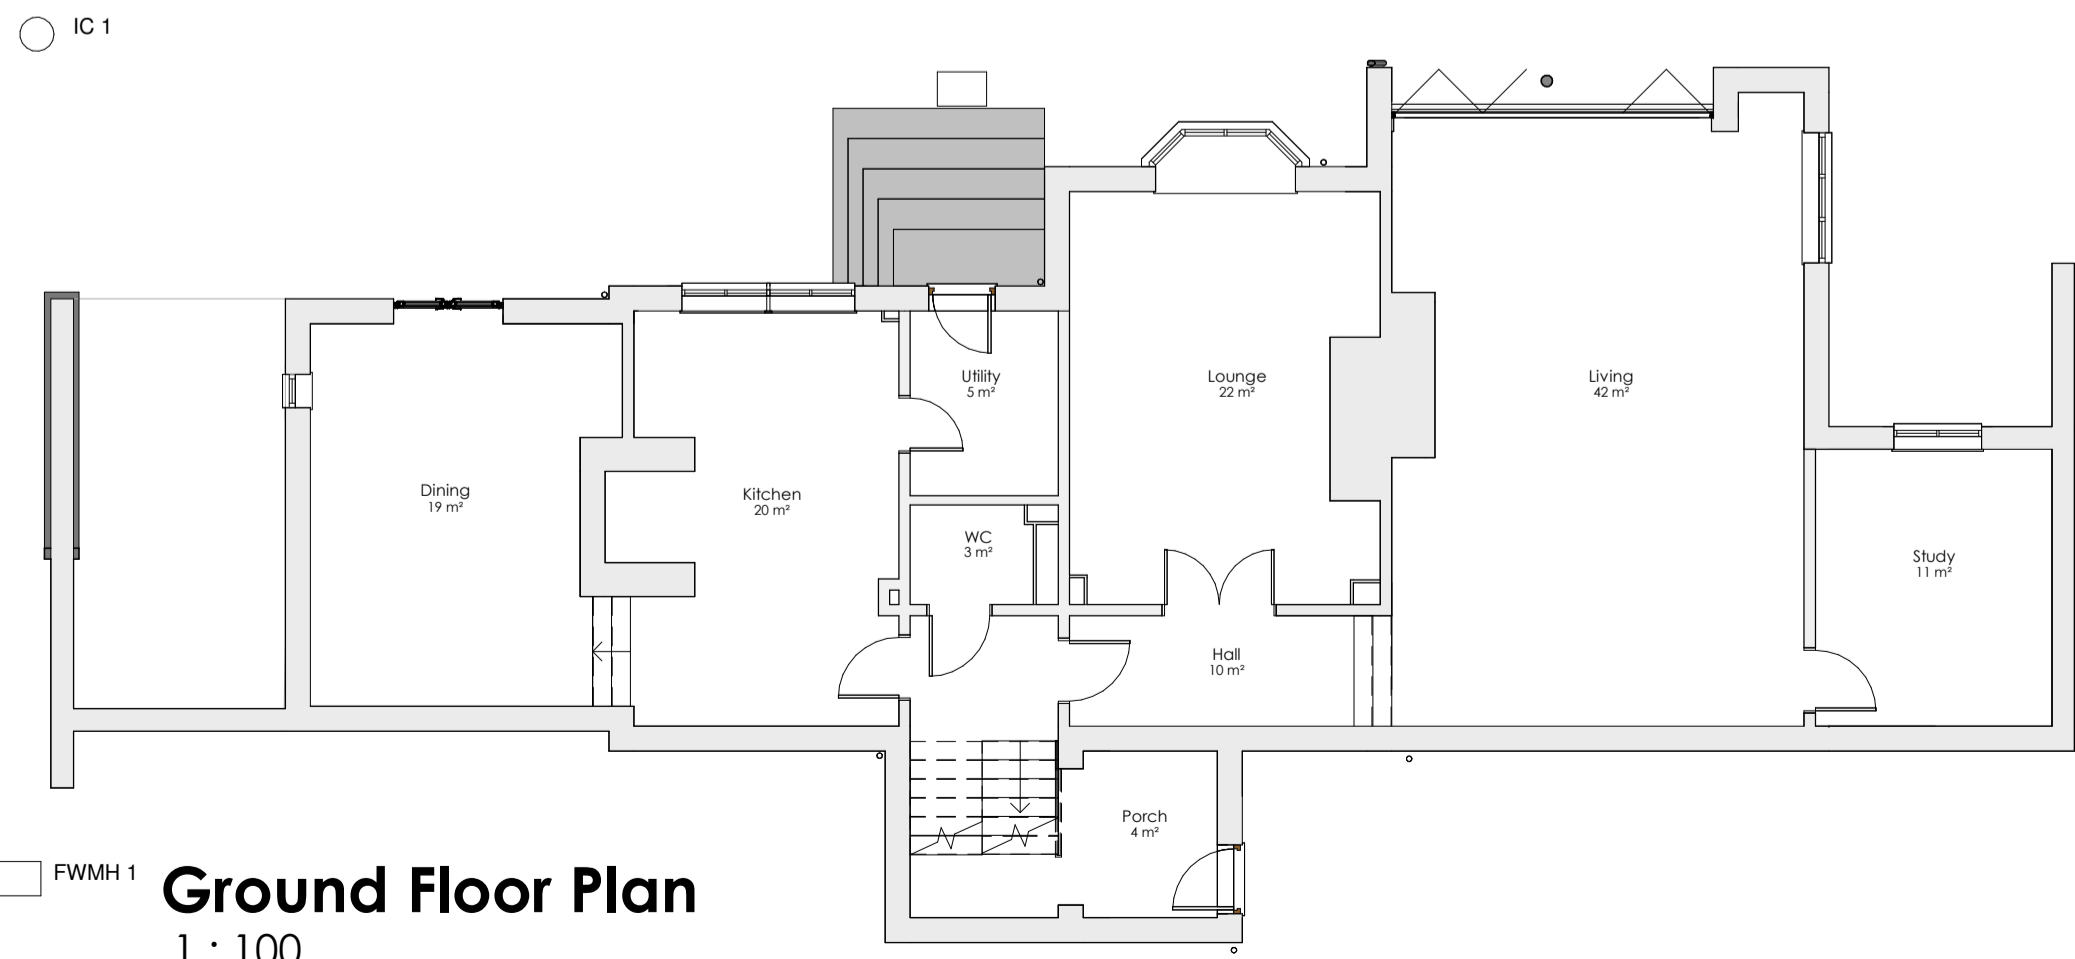

**Ground Floor Plan**  
1 : 100

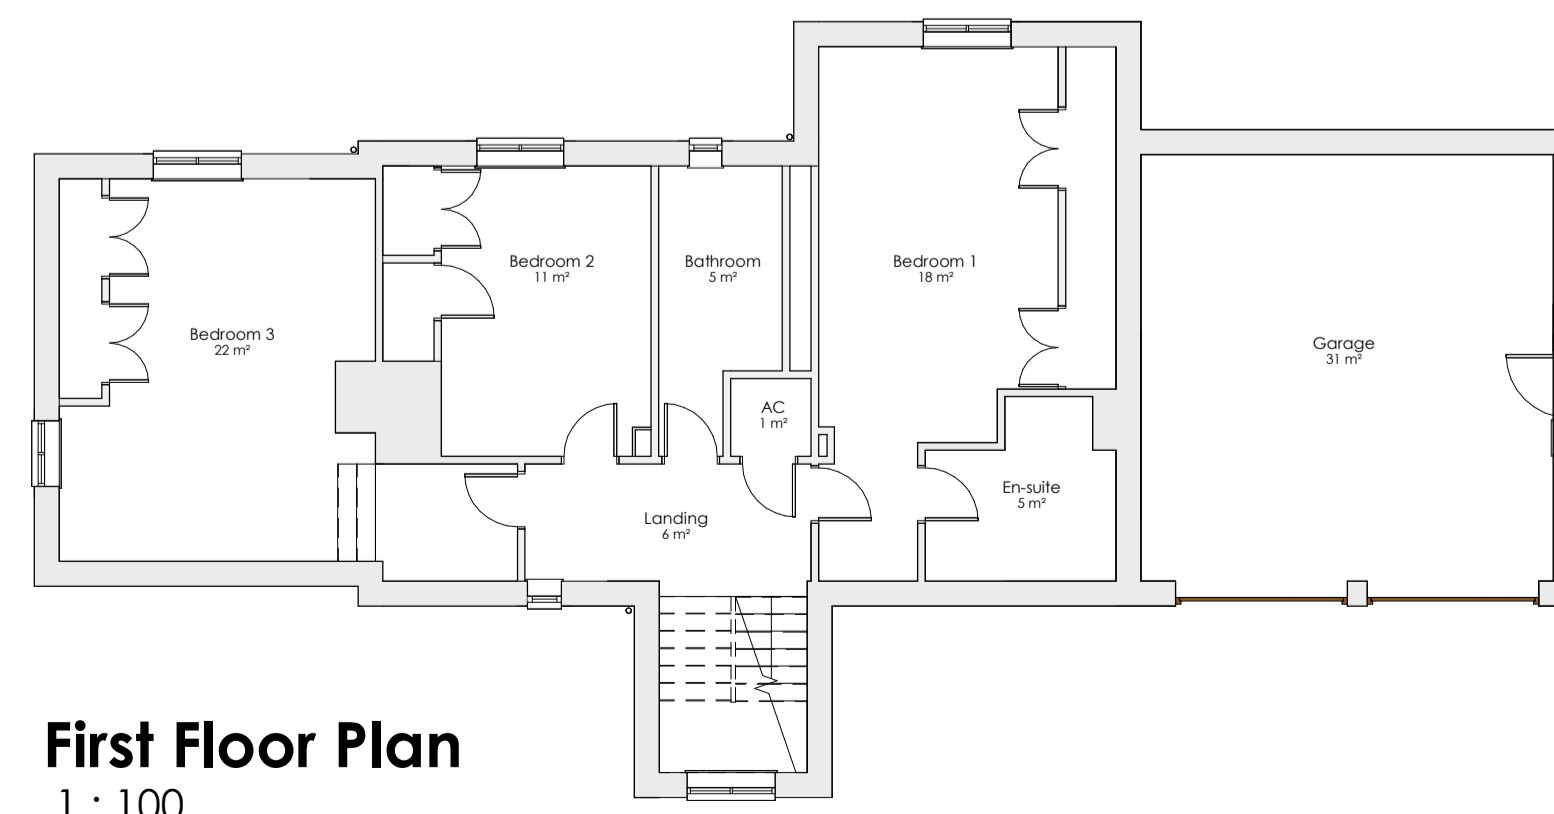

**First Floor Plan**  
1 : 100

The Loft  
Greenway House  
Sugarswell Business Park  
Banbury  
Oxfordshire OX15 6HW  
T: +44 (0)1295 257617 W: <http://www.digidesignco.com>

**CLIENT:**  
Mr P Miles

**PROJECT:**  
7 Walford Road  
Sibford Ferris,  
Banbury,  
Oxfordshire  
OX15 5PL

**DRAWING:**  
Measured Survey

**JOB NUMBER:** DDC-2022-792  
**SCALE:** As indicated  
**DATE:** June 2022  
**SHEET:** A1

**DRAWING NUMBER:** 001  
**DRAWN BY:** AM  
**CHECKED BY:** AJL

**UNITS:** mm