


THE CONTRACTOR IS RESPONSIBLE FOR CHECKING ALL DIMENSIONS ON SITE. ANY DISCREPANCY SHOULD BE REPORTED TO THE CONSULTANT PRIOR TO COMMENCEMENT OF ANY WORKS.
IT IS THE CONTRACTOR'S RESPONSIBILITY TO DETERMINE THE LOCATION OF ALL UNDERGROUND SERVICES.
THIS DRAWING IS COPYRIGHT AND IS NOT TO BE REPRODUCED WITHOUT WRITTEN CONSENT OF THE PARTNERSHIP.

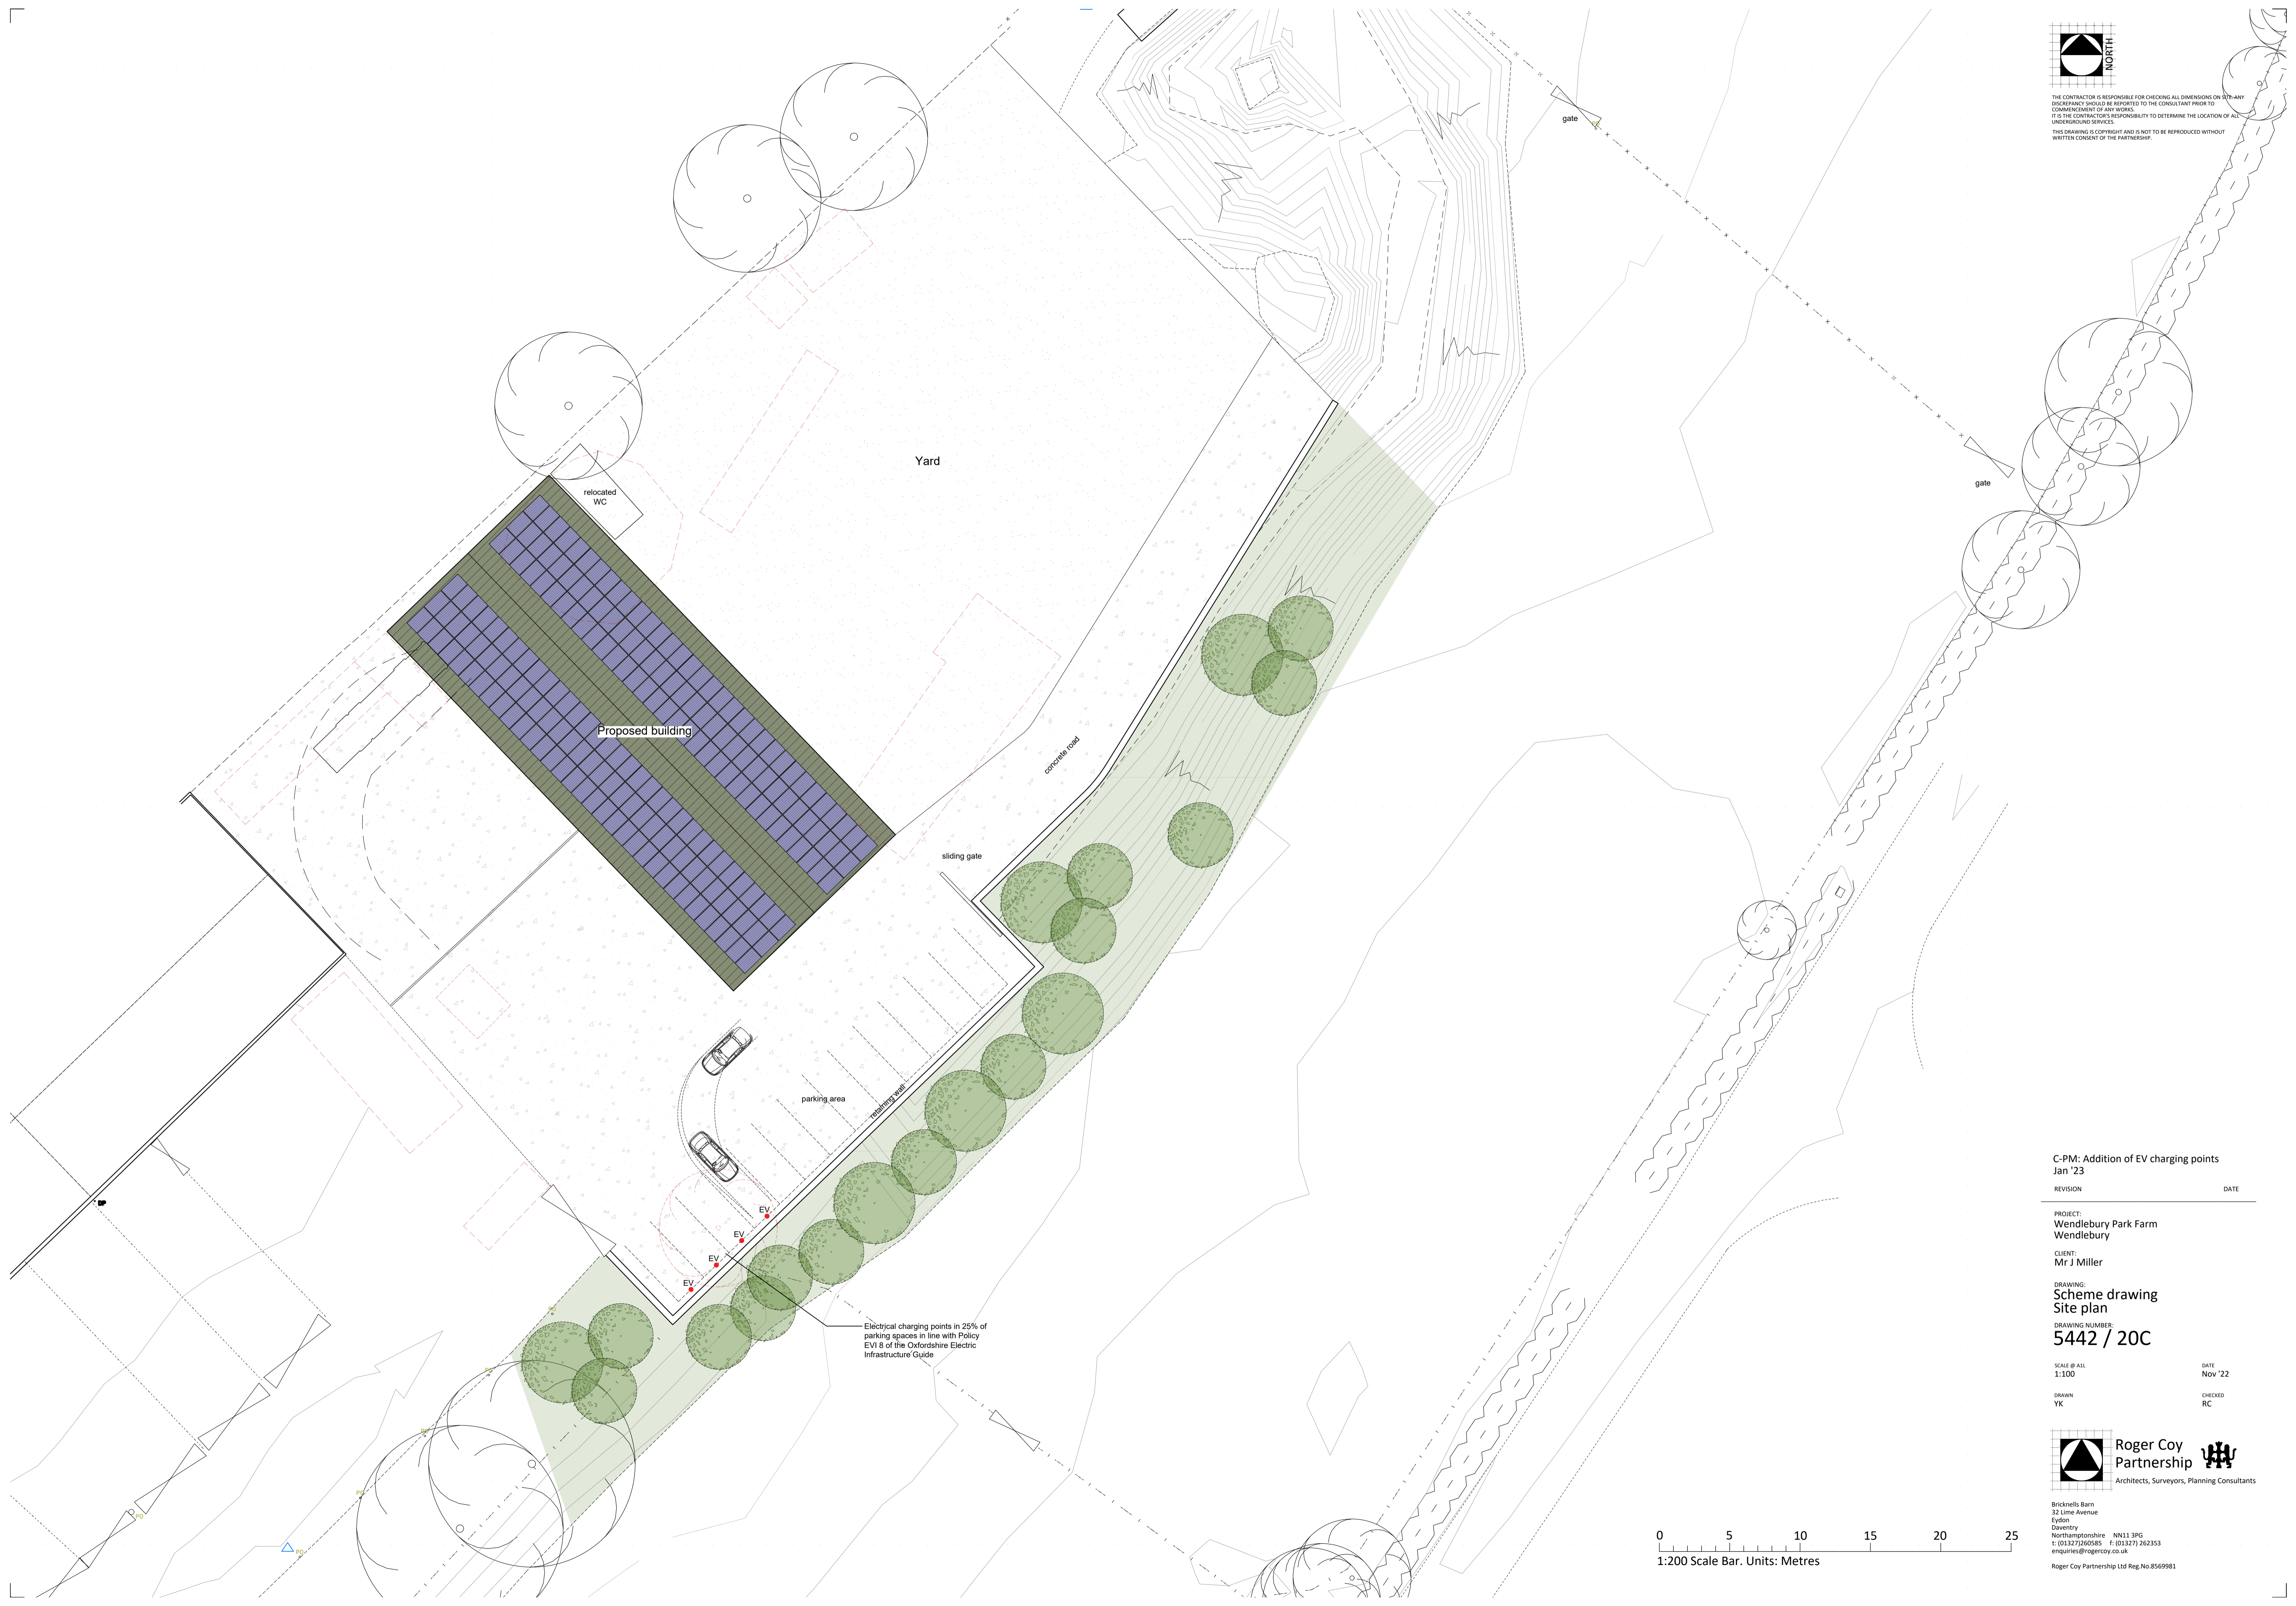

Electrical charging points in 25% of parking spaces in line with Policy EVI 8 of the Oxfordshire Electric Infrastructure Guide

C-PM: Addition of EV charging points
Jan '23

REVISION _____ DATE _____

PROJECT:
Wendlebury Park Farm
Wendlebury

CLIENT:
Mr J Miller

DRAWING:
Scheme drawing
Site plan

DRAWING NUMBER:
5442 / 20C

SCALE @ A1:

1:100

DATE


Nov '22

DRAWN

YK

CHECKED

RC

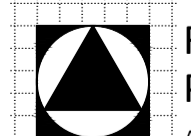

Roger Coy Partnership
Architects, Surveyors, Planning Consultants

Bricknell's Barn
32 Lime Avenue
Eyton
Daventry
Northamptonshire NN13 3PG
t: (01327) 260585 f: (01327) 262353
enquiries@rogercoypartnership.co.uk

Roger Coy Partnership Ltd Reg. No. 8569981

