 


Reproduced by permission of Ordnance Survey on behalf of the Controller of Her Majesty's Stationery Office
All rights reserved. © Crown Copyright licence no. 100022432


 
Reproduced by permission of Ordnance Survey on behalf of the Controller of Her Majesty's Stationery Office
All rights reserved. © Crown Copyright licence no. 100022432

SITE AREA PLAN



SITE PHOTOGRAPH

SITE LOCATION PLAN

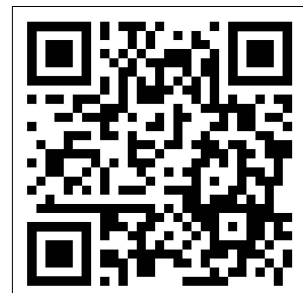


GOOGLE MAPS QR CODE

GOOGLE MAPS -<https://goo.gl/maps/y1WcPXSakBnyKysu6>

GOOGLE STREETVIEW -<https://goo.gl/maps/hkJmFWzxm2iTu5q1A>

NOTES:
1. ALL DIMENSIONS IN MM UNLESS OTHERWISE NOTED.
DIRECTIONS TO SITE:
Head north-west on M40, At junction 9, take the A34/A41 exit to Oxford/Newbury/Bicester, At Wendlebury Interchange, take the 1st exit onto A34, Take the B4027 exit towards Blethingdon/Heathfield/Islip, Turn left onto B4027, Turn right onto Springwell Hill, Continue onto Blethingdon Rd, the site is located on the left hand side on the grass verge

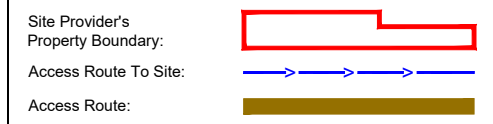

Master: M002	MBNL / EE: MBNL	Project: 3UK DNSW	Purpose of Issue: Planning	Issue: B
Date: 13/03/2023	Drawn: CDN	Revision / Upgrade Description: Pole type changed to Phase 9		
Checked: DH	Approved: SD			
Master: M001	MBNL / EE: MBNL	Project: 3UK DNSW	Purpose of Issue: Planning	Issue: A
Date: 07/09/2021	Drawn: CDN	Revision / Upgrade Description: First Issue - Site nomination dated: TBC		
Checked: DH	Approved: SD			

CK Hutchison Networks (UK) Limited

Green Park
450 Longwater Avenue
Reading
RG30 3UR


Design Consultant & Principal Contractor:




WHP Telecoms
Unit 1 Maple Park,
Low Fields Avenue, Leeds
LS12 6HH
Tel: 01133023550
e-mail: info@whptelecoms.com

Site Name:	STATION ROAD SW		
Site ID:	CWL18719		
Address:	STATION ROAD, KIRTLINGTON, CHERWELL, OXFORDSHIRE, SOUTH EAST ENGLAND, ENGLAND, OX5 3EZ		
Title:	002 SITE LOCATION PLAN		
Project:	3UK DNSW		
Purpose of Issue:	PLANNING		
EE Cell ID:	82874	MBNL Cell ID:	CWL124
		Cell ID:	OX0603
Master Drawing No:	CWL18719_M002		Issue: B

100mm
50mm
10mm

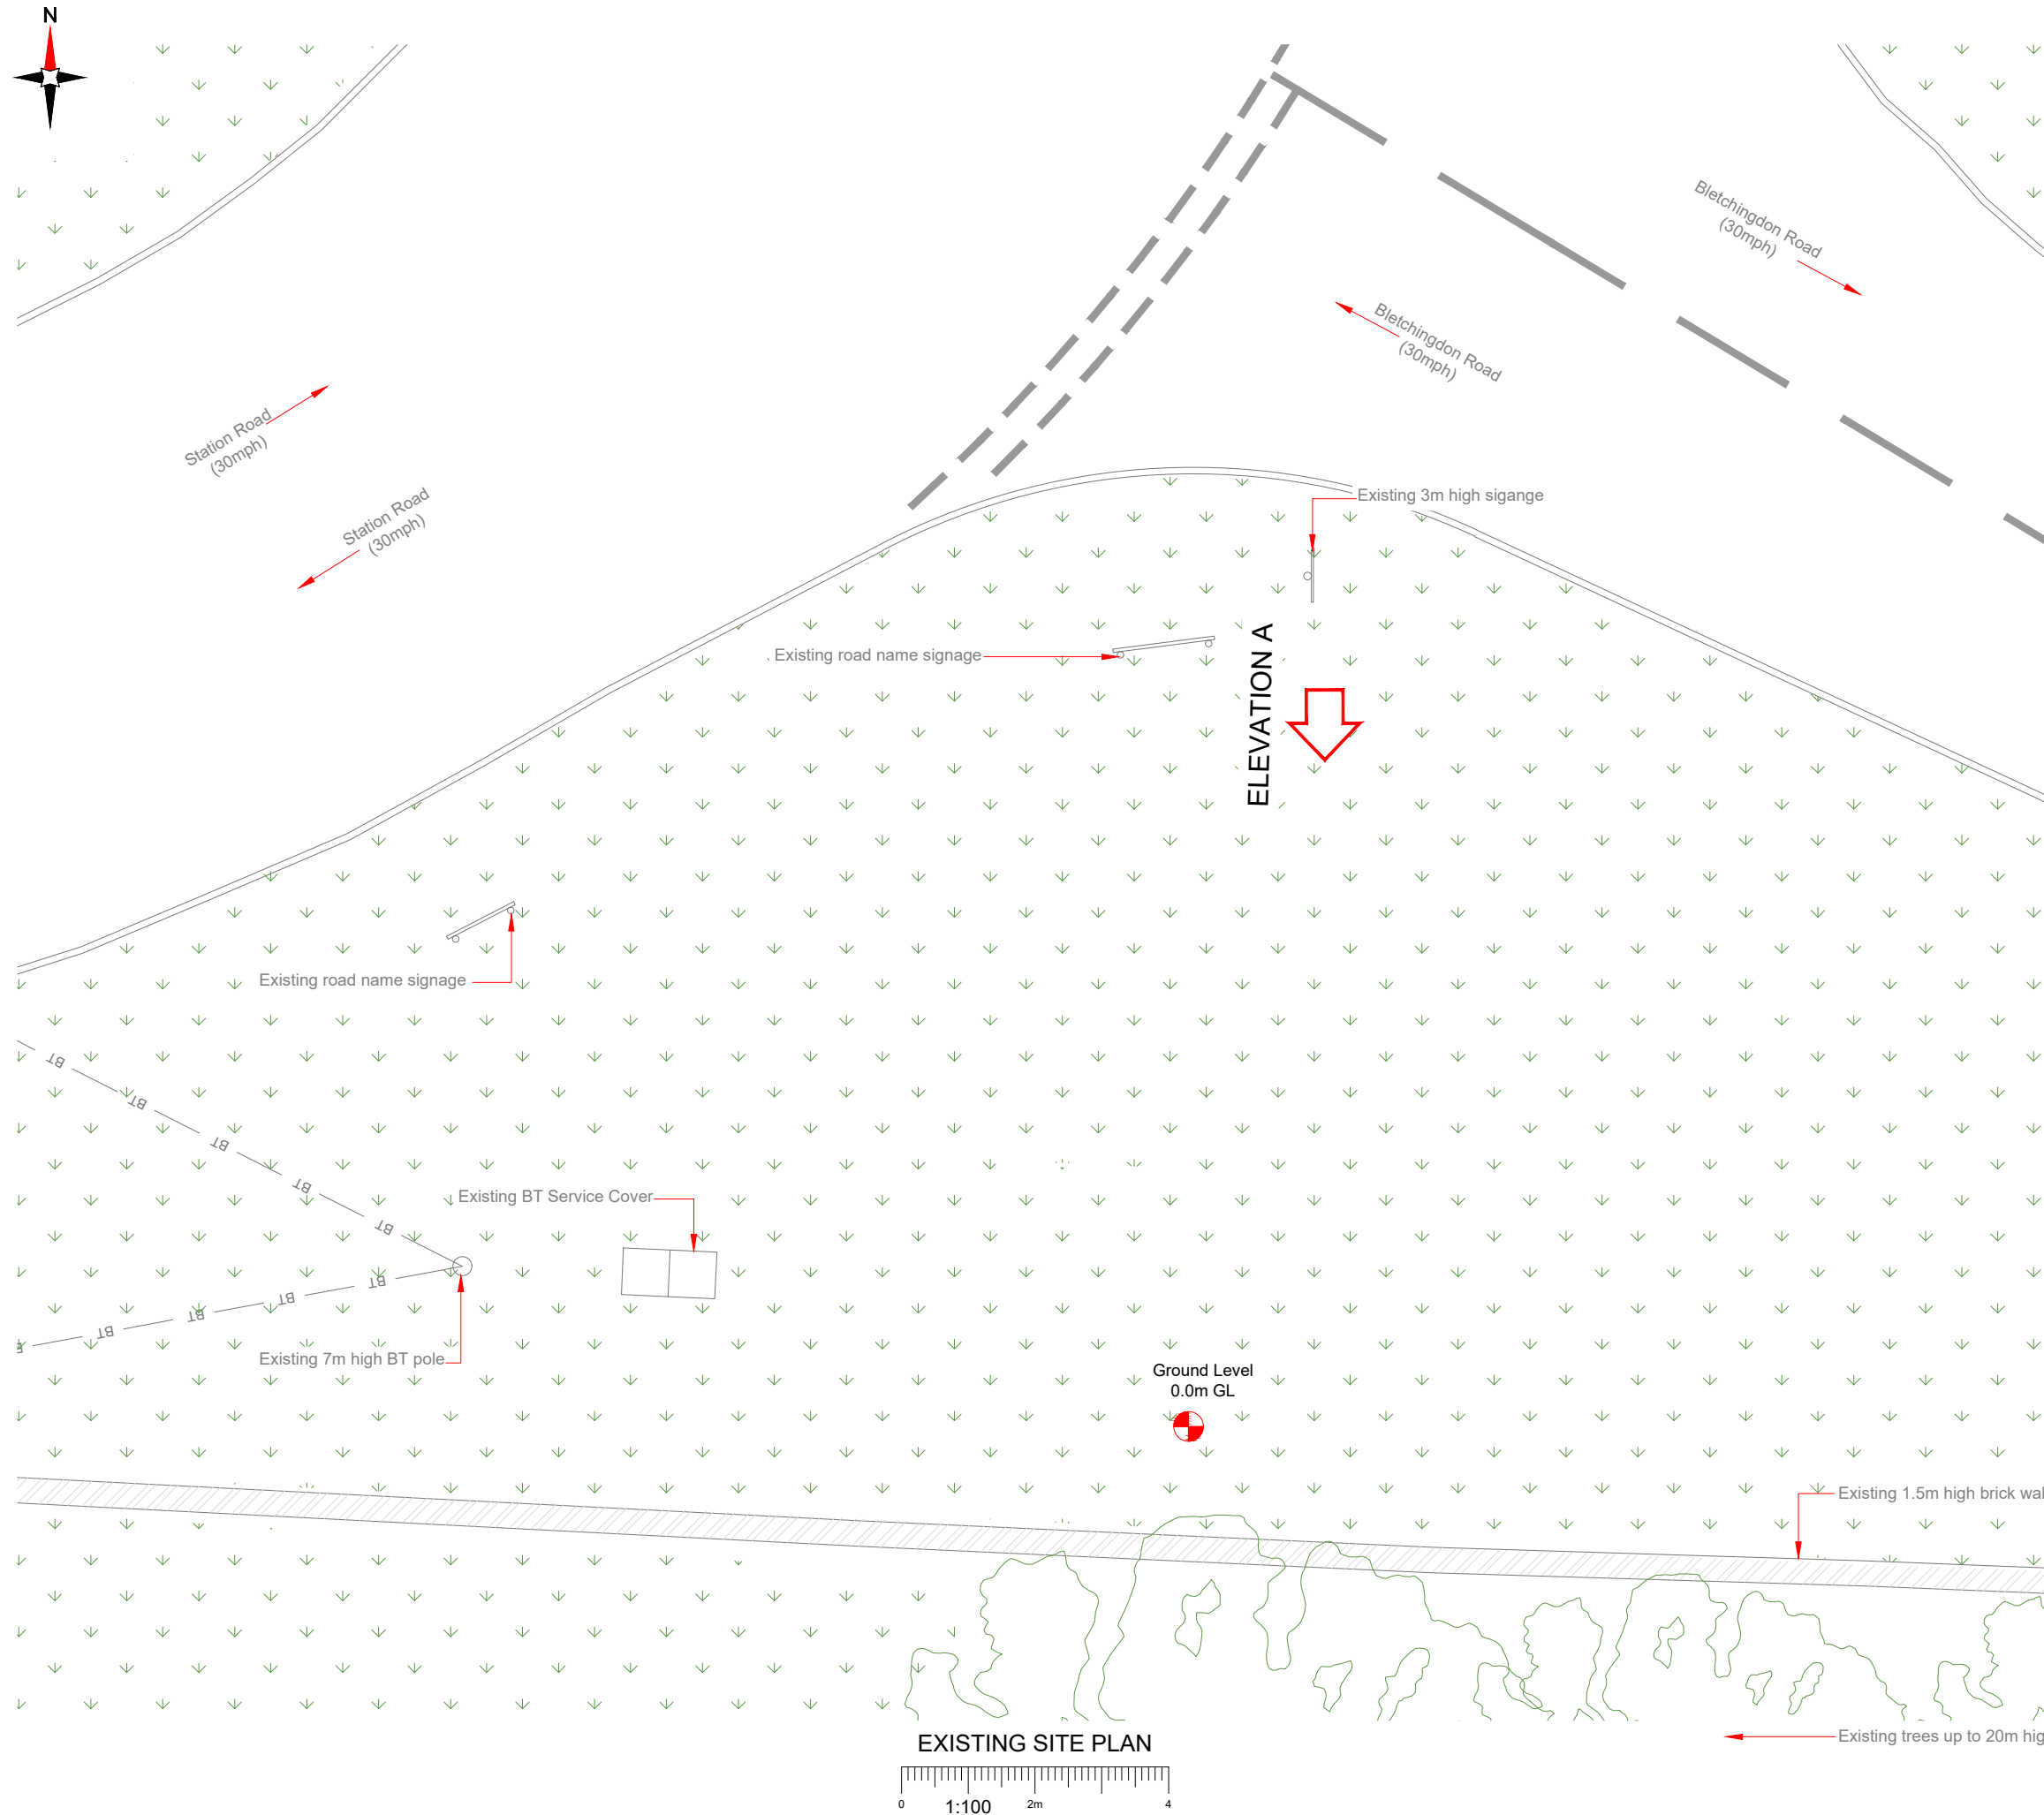

EXISTING SITE PLAN

 

NOTES:
1. ALL DIMENSIONS IN MM UNLESS OTHERWISE NOTED.

Master: M002	MBNL / EE: MBNL	Project: 3UK DNSW	Purpose of Issue: Planning	Issue: B
Date: 13/03/2023	Drawn: CDN	Revision / Upgrade Description: Pole type changed to Phase 9		
Checked: DH	Approved: SD			
Master: M001	MBNL / EE: MBNL	Project: 3UK DNSW	Purpose of Issue: Planning	Issue: A
Date: 07/09/2021	Drawn: CDN	Revision / Upgrade Description: First Issue - Site nomination dated: TBC		
Checked: DH	Approved: SD			

CK Hutchison Networks (UK) Limited
 Green Park
 450 Longwater Avenue
 Reading
 RG30 3UR

Design Consultant & Principal Contractor:



WHP Telecoms
 Unit 1 Maple Park,
 Low Fields Avenue, Leeds
 LS12 6HH
 Tel: 01133023550
 e-mail: info@whptelecoms.com

Site Name: **STATION ROAD SW**

Site ID: **CWL18719**

Address: **STATION ROAD, KIRTLINGTON, CHERWELL, OXFORDSHIRE, SOUTH EAST ENGLAND, ENGLAND, OX5 3EZ**

Title: **100 EXISTING SITE PLAN**

Project: **3UK DNSW**

Purpose of Issue: **PLANNING**

EE Cell ID: 82874	MBNL Cell ID: CWL124	Cell ID: OX0603
--------------------------	-----------------------------	------------------------

Master Drawing No: **CWL18719_M002** Issue: **B**



NOTES:
1. ALL DIMENSIONS IN MM UNLESS OTHERWISE NOTED.

Master:	MBNL / EE:	Project:	Purpose of Issue:	Issue:
M002	MBNL	3UK DNSW	Planning	B
Date:	13/03/2023	Revision / Upgrade Description:		
Drawn:	CDN	Pole type changed to Phase 9		
Checked:	DH			
Approved:	SD			
Master:	MBNL / EE:	Project:	Purpose of Issue:	Issue:
M001	MBNL	3UK DNSW	Planning	A
Date:	07/09/2021	Revision / Upgrade Description:		
Drawn:	CDN	First Issue - Site nomination dated: TBC		
Checked:	DH			
Approved:	SD			

CK Hutchison Networks (UK) Limited
Green Park
450 Longwater Avenue
Reading
RG30 3UR

Design Consultant & Principal Contractor:



WHP Telecoms
Unit 1 Maple Park,
Low Fields Avenue, Leeds
LS12 6HH
Tel: 01133023550
e-mail: info@whptelecoms.com

Site Name: **STATION ROAD SW**

Site ID: **CWL18719**

Address: **STATION ROAD,
KIRTLINGTON, CHERWELL,
OXFORDSHIRE,
SOUTH EAST ENGLAND,
ENGLAND,
OX5 3EZ**


Title: **150 EXISTING ELEVATION A**

Project: **3UK DNSW**

Purpose of Issue: **PLANNING**

EE Cell ID:	MBNL Cell ID:	Cell ID:
82874	CWL124	OX0603

 
Master Drawing No: **CWL18719_M002** Issue: **B**




Antenna Aperture ID	Proposed 4G/5G Bearing
A1	10°
B1	130°
C1	250°
A2	10°
B2	130°
C2	250°

NOTES:

- ALL DIMENSIONS IN MM UNLESS OTHERWISE NOTED.

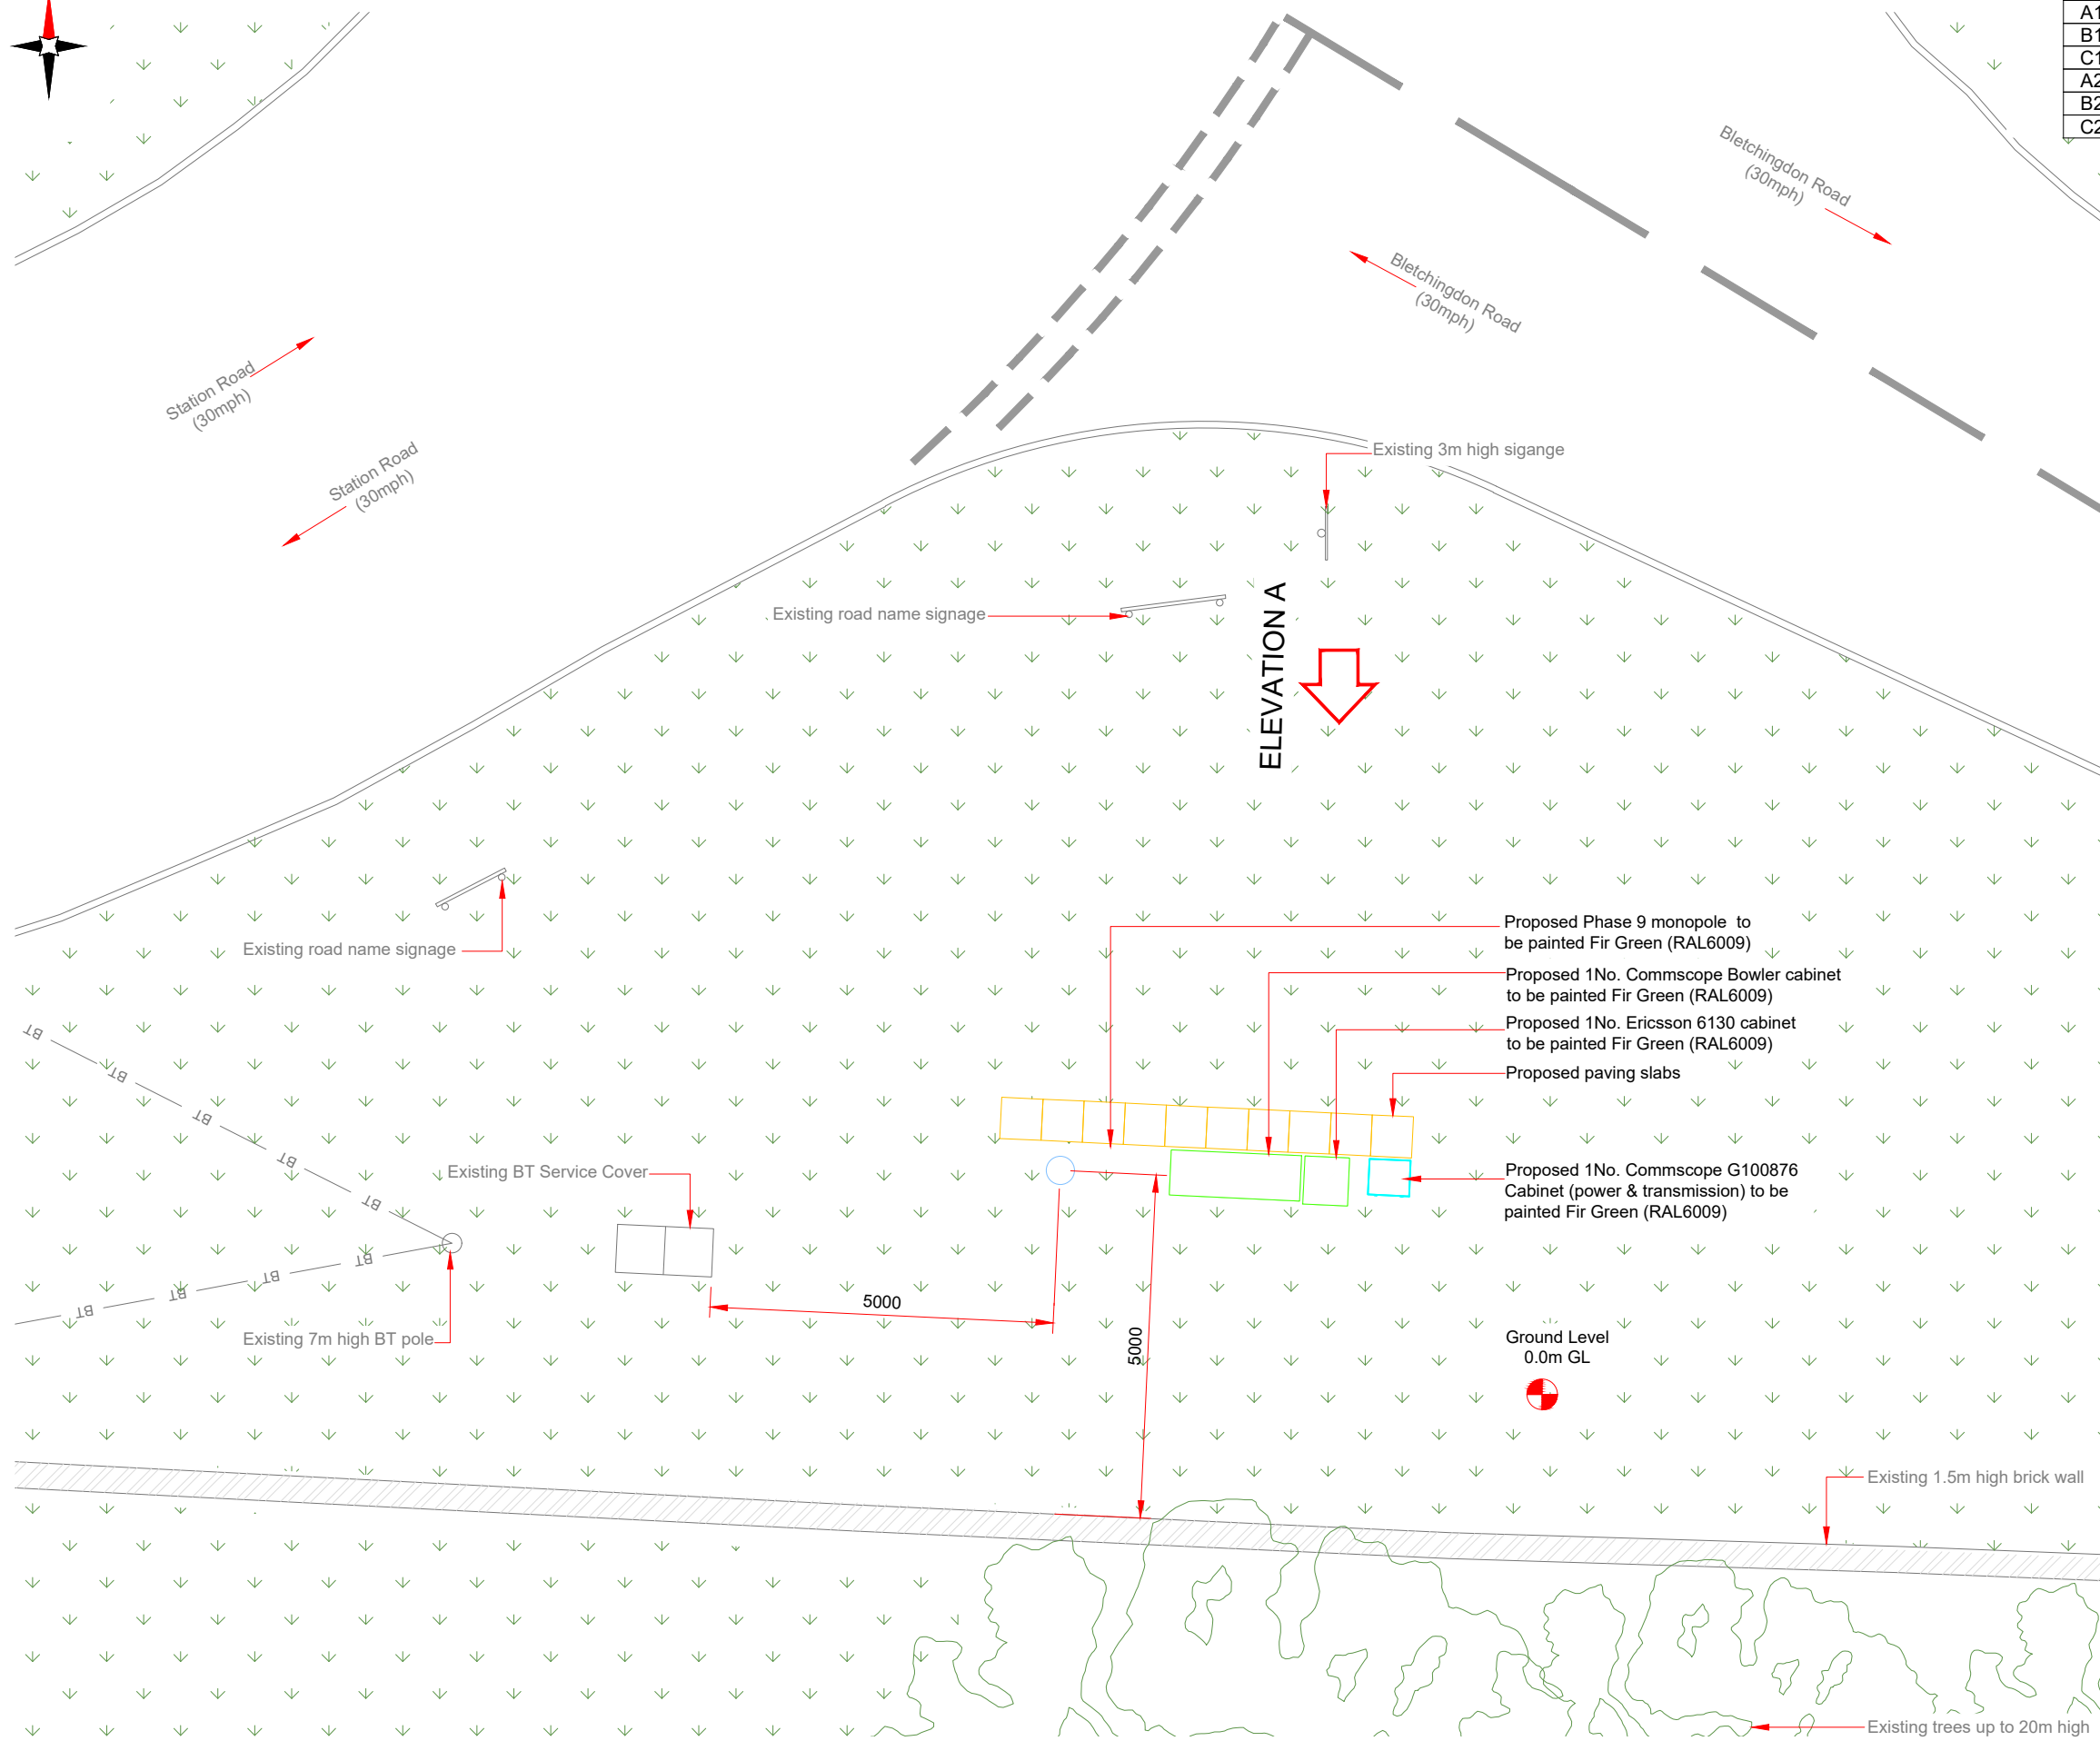

PROPOSED SITE PLAN

 

Master	MBNL / EE	Project	Purpose of Issue	Issue
M002	MBNL	3UK DNSW	Planning	B
Date:	13/03/2023	Revision / Upgrade Description: Pole type changed to Phase 9		
Drawn:	CDN			
Checked:	DH			
Approved:	SD			
Master	MBNL / EE	Project	Purpose of Issue	Issue
M001	MBNL	3UK DNSW	Planning	A
Date:	07/09/2021	Revision / Upgrade Description: First Issue - Site nomination dated: TBC		
Drawn:	CDN			
Checked:	DH			
Approved:	SD			

CK Hutchison Networks (UK) Limited

Green Park
450 Longwater Avenue
Reading
RG30 3UR

Design Consultant & Principal Contractor:



WHP Telecoms
Unit 1 Maple Park,
Low Fields Avenue, Leeds
LS12 6HH

Tel: 01133023550
e-mail: info@whptelecoms.com

Site Name: **STATION ROAD SW**

Site ID: **CWL18719**

Address: **STATION ROAD,
KIRTLINGTON, CHERWELL,
OXFORDSHIRE,
SOUTH EAST ENGLAND,
ENGLAND,
OX5 3EZ**

Title: **210 PROPOSED SITE PLAN**

Project: **3UK DNSW**

Purpose of Issue: **PLANNING**


EE Cell ID: 82874	MBNL Cell ID: CWL124	Cell ID: OX0603
-----------------------------	--------------------------------	---------------------------

Master Drawing No: CWL18719_M002	Issue: B
--------------------------------------------	--------------------


100mm
150mm
10mm

Antenna Aperture ID	Proposed 4G/5G Bearing
A1	10°
B1	130°
C1	250°
A2	10°
B2	130°
C2	250°

NOTES:
1. ALL DIMENSIONS IN MM UNLESS OTHERWISE NOTED.

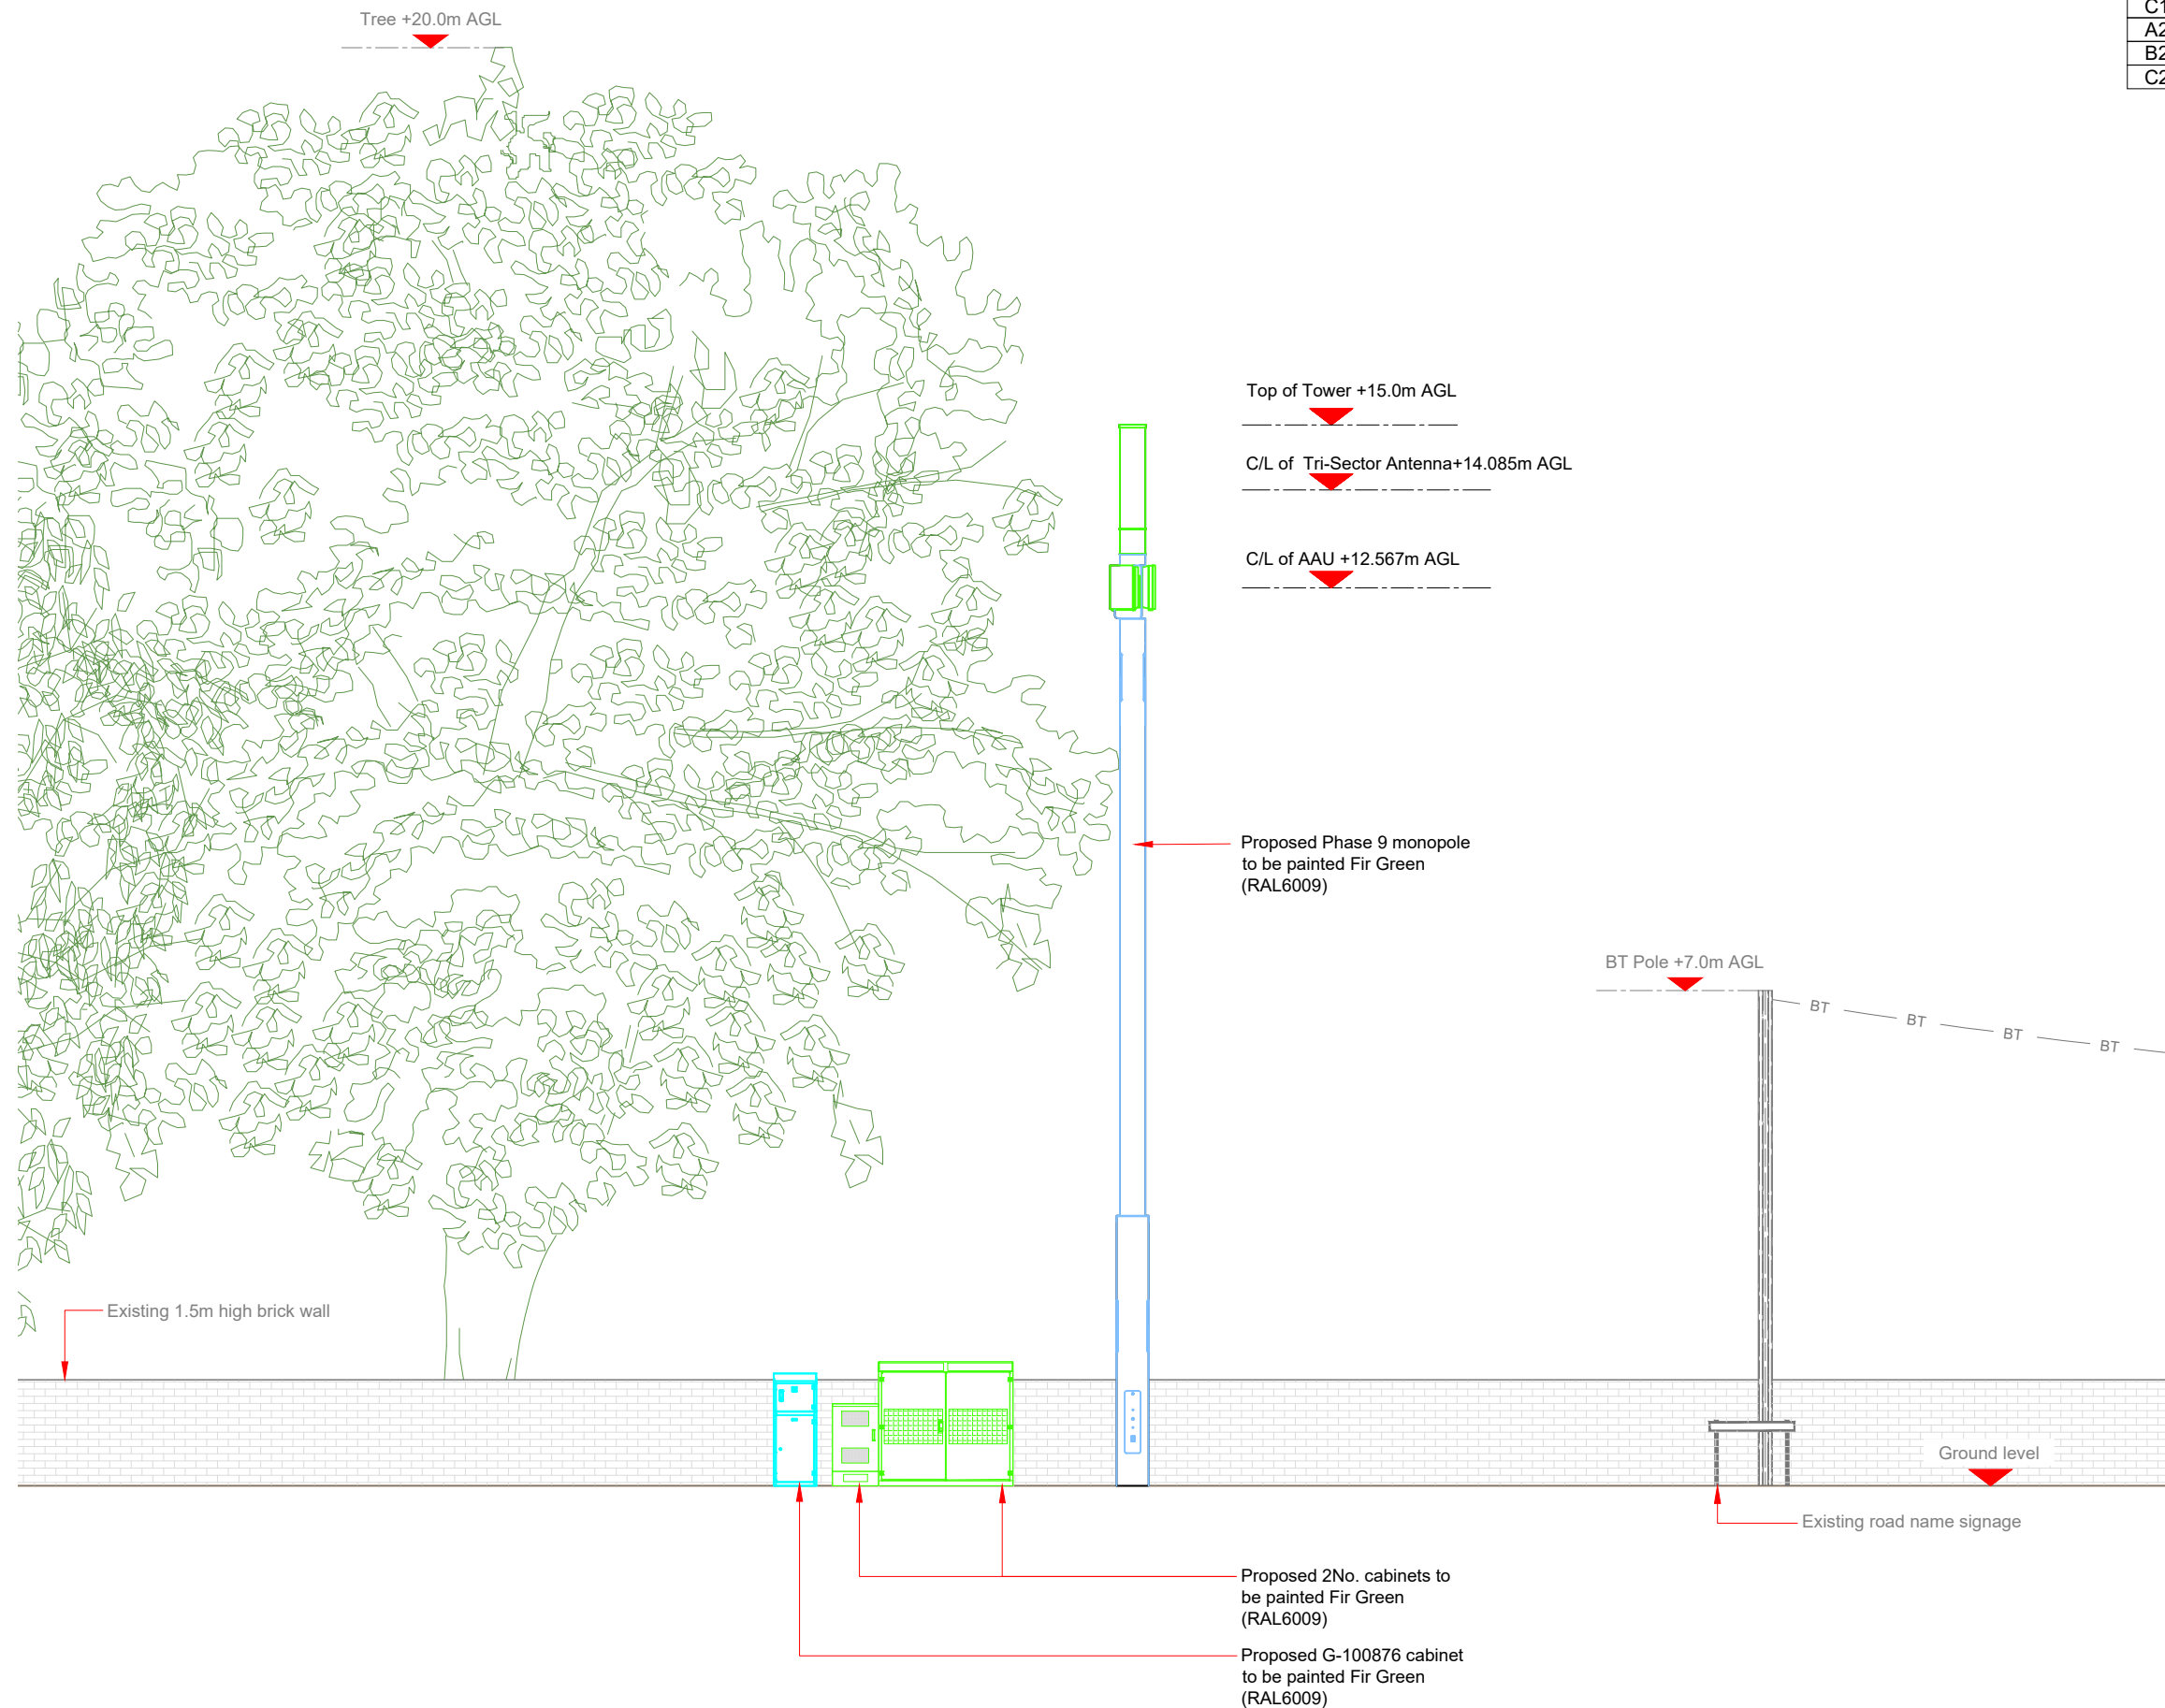

PROPOSED ELEVATION

 

Master	MBNL / EE	Project	Purpose of Issue	Issue
M002	MBNL	3UK DNSW	Planning	B
Date:	13/03/2023	Revision / Upgrade Description: Pole type changed to Phase 9		
Drawn:	CDN			
Checked:	DH			
Approved:	SD			
Master	MBNL / EE	Project	Purpose of Issue	Issue
M001	MBNL	3UK DNSW	Planning	A
Date:	07/09/2021	Revision / Upgrade Description: First Issue - Site nomination dated: TBC		
Drawn:	CDN			
Checked:	DH			
Approved:	SD			

CK Hutchison Networks (UK) Limited

Green Park
450 Longwater Avenue
Reading
RG30 3UR

Design Consultant & Principal Contractor:



WHP Telecoms
Unit 1 Maple Park,
Low Fields Avenue, Leeds
LS12 6HH

Tel: 01133023550
e-mail: info@whptelecoms.com

Site Name:	STATION ROAD SW		
Site ID:	CWL18719		
Address:	STATION ROAD, KIRTLINGTON, CHERWELL, OXFORDSHIRE, SOUTH EAST ENGLAND, ENGLAND, OX5 3EZ		
Title:	260 PROPOSED ELEVATION		
Project:	3UK DNSW		
Purpose of Issue:	PLANNING		
EE Cell ID:	82874	MBNL Cell ID:	CWL124
		Cell ID:	OX0603
Master Drawing No:	CWL18719_M002		Issue:
			B