


Rev	Date	By	Description
A	09/09/2021	AZ	Photovoltaic panels indicated as per comments received from the Client.
B	17/09/2021	AA	PV Panels updated to 18% commitment.
C	24/09/2021	AA	Comments received on drawings from Arup on 22/09/21.
D	06/10/2021	AA	General comments following design review with Arup.
E	28/10/2021	JMS	Revised as per meeting with TSL on 27/10/2021.
F	23/11/2021	AZ	Drawing revised as per email received from Client on 22/11/2021.
G	23/03/2022	JMS	Roof area figures updated and notation clarified.

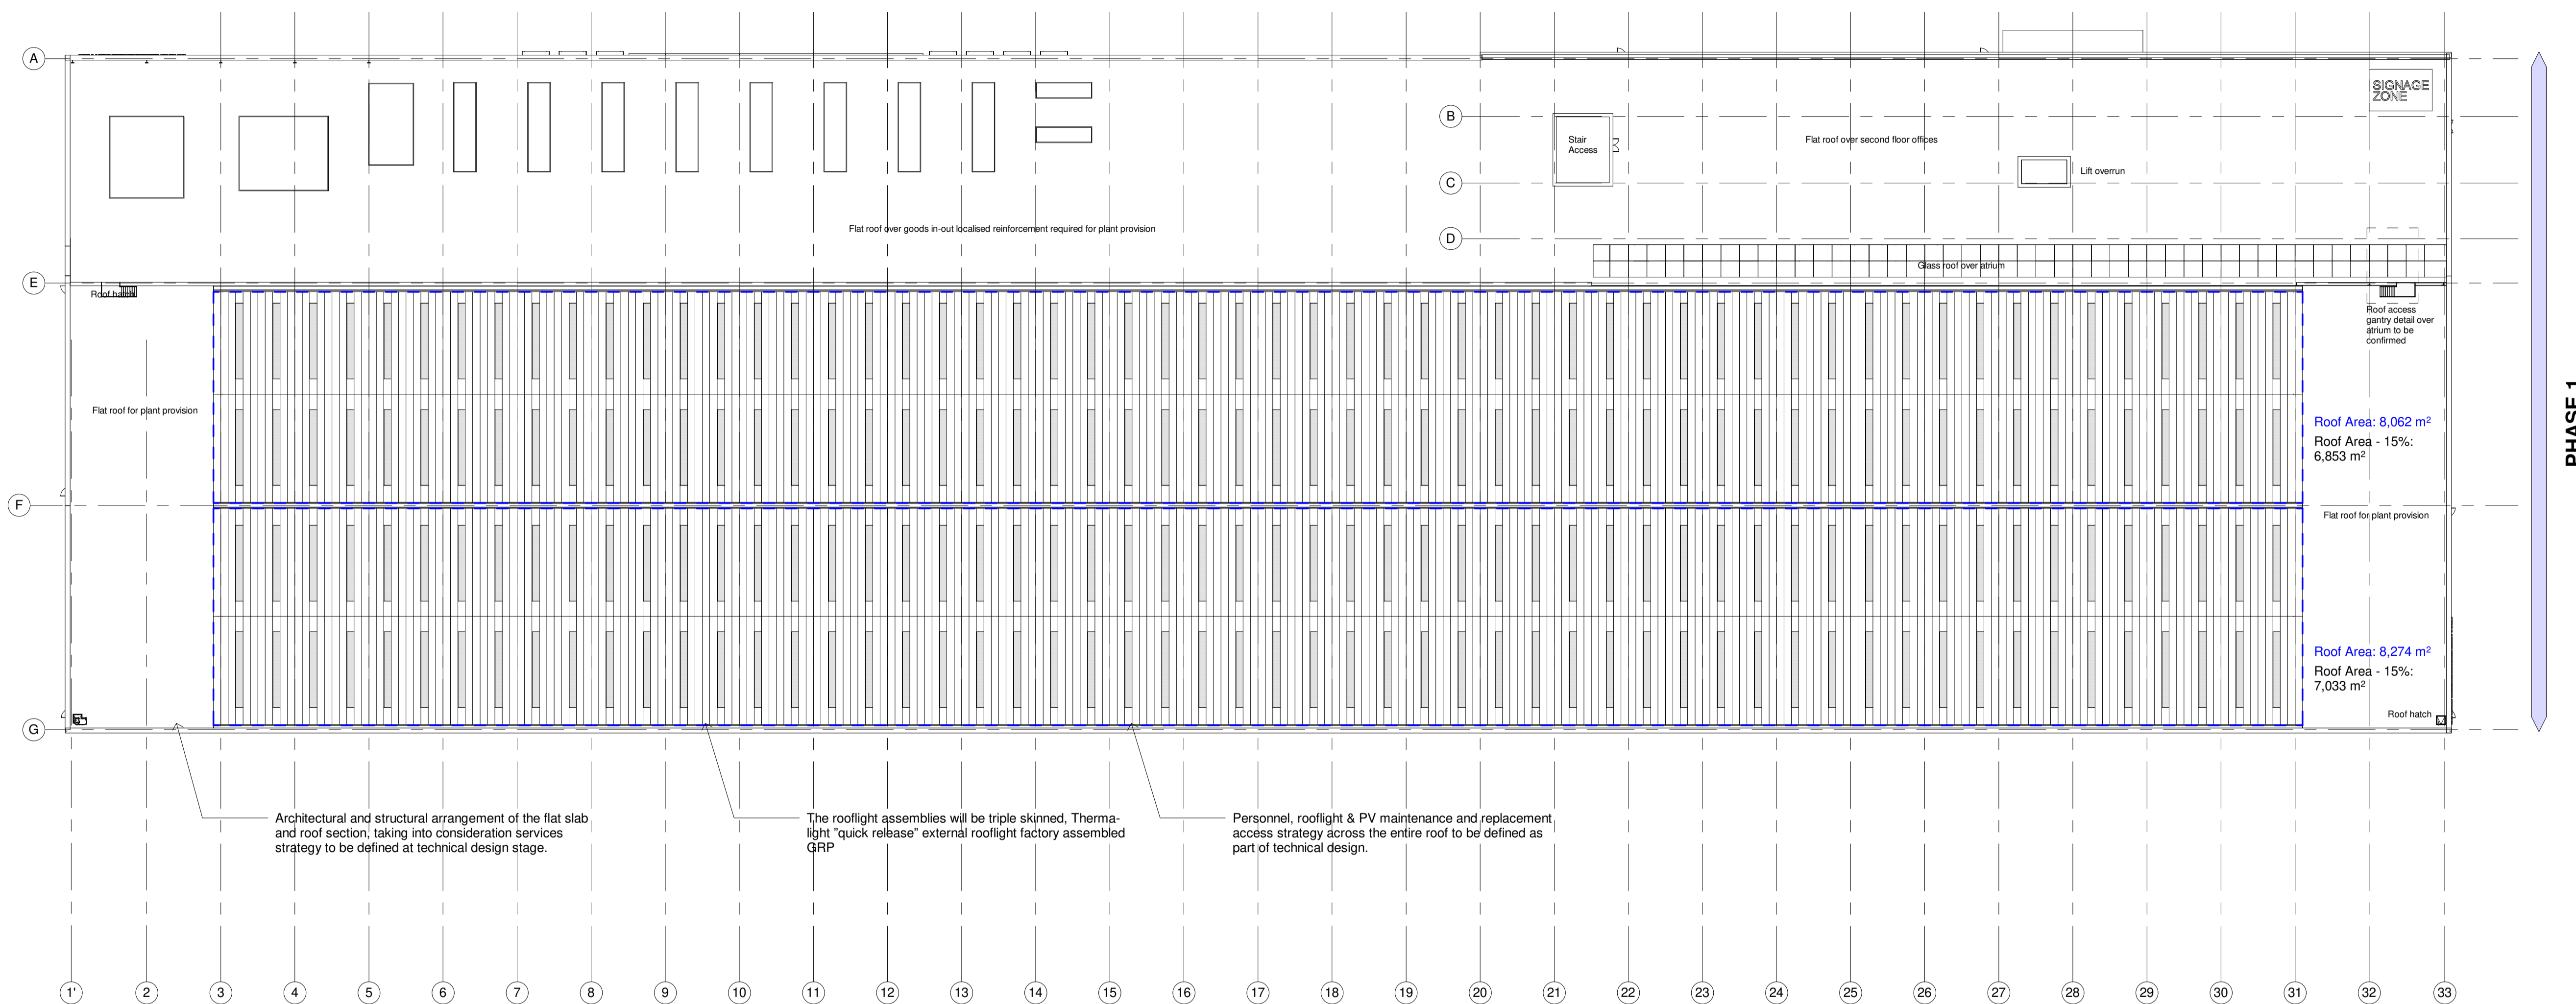

Architectural and structural arrangement of the flat slab and roof section, taking into consideration services strategy to be defined at technical design stage.

The rooflight assemblies will be triple skinned, Thermo-light "quick release" external rooflight factory assembled GRP


Personnel, rooflight & PV maintenance and replacement access strategy across the entire roof to be defined as part of technical design.

**1** Production Area Roof  
1 : 500

Total Area of Pitched Roof: 16,336 m<sup>2</sup>  
Usable Area of Roof Space available for PVs, Access and Signage: 13,886 m<sup>2</sup> (equal to total area of pitched roof less 15% rooflight area)

Consent sought for PV provision on 100% of useable roof space. Committed PV Array is equal to 18% of useable roof space.

Area of unusable roof for PV panels:  
- Rooflights  
- Access for signage  
- Areas required to gain access to roof safely  
- Eaves and Valley Gutter areas

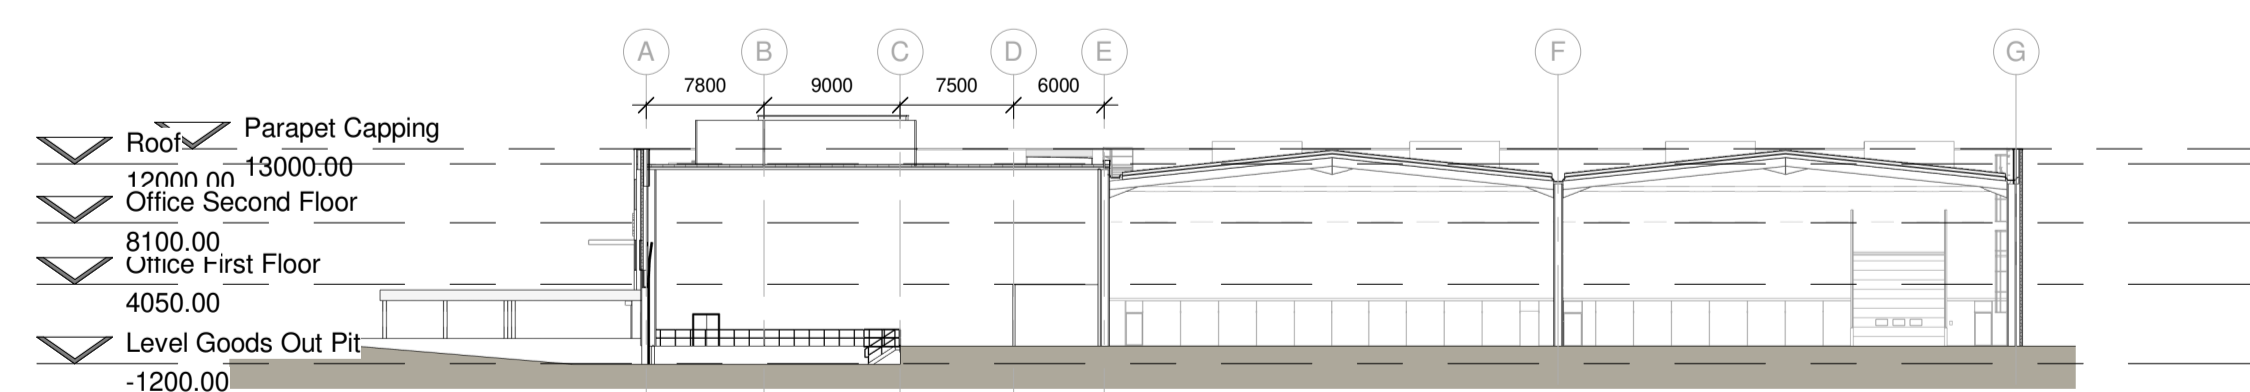

**2** Planning Production Area Section CC 1\_500  
1 : 500



A TRITAX BIG BOX COMPANY



Architects + Masterplanners

Waterfront House  
2a Smith Way  
Grove Park  
Enderby  
Leicester LE19 1SX

t: +44 (0)116 247 0557

[www.stephengeorge.co.uk](http://www.stephengeorge.co.uk)

Oxford North  
M40 J9

Drawing Name:  
ENHANCED - Phase 1 - Roof Plan

Drawing Stage: **Planning**

Status: **S0**

SGP File Ref: 131300

13-222 09/09/2021 AA MMS 1:500 @ A1 G

SGP Project No: Date: Drawn: Team: Scale: Rev:

Drawing Number:

13-222-SGP-ZZ-ZZ-DR-A- 131109

Project Code Originator Volume Level Type Role Number

