



ALL LEVELS ARE IN METRES DERIVED FROM GPS TRANSFORMATION.
 GRID COORDINATES ARE ORDNANCE SURVEY OSG36 GRID DERIVED FROM GPS
 TRANSFORMATION. (NO SCALE FACTOR APPLIED)
 PLOT SCALE ACCURACY OF 1:100.
 TREE SPECIES TO BE CONFIRMED BY A SPECIALIST IF ESSENTIAL TO THE SURVEY.
 SERVICE COVERS UNDER STRUCTURES/VEHICLES OR ONES THAT ARE BURIED MAY BE
 OMITTED FROM THE SURVEY. PIPE DETAILS SURVEYED FROM SURFACE ONLY.
 BROKEN COVERS AND COVERS WITHIN BUSY HIGHWAYS WILL NOT BE LIFTED.
 OVERHEAD CABLE POSITIONS/HEIGHTS SHOULD BE TREATED AS APPROXIMATE AND
 ARE LIABLE TO SEASONABLE CHANGE.
 COPYRIGHT AND FULL RIGHTS REMAIN WITH CRYFIELD SURVEYS LTD.

- TEXT KEY -
- av - air valve
 - bl - telecom
 - cabv - cable television
 - cb fence - closeboard fence
 - cbbox - control box
 - d - cover level
 - cz - cable riser
 - dp - depth
 - ep - electric pole
 - er - earthing rod
 - fh - fire hydrant
 - fl - floor level
 - fs - fire switch
 - g - gully
 - gv - gas valve
 - h - height
 - ic - inspection cover
 - il - invert level
 - lp - lamp post
 - mh - manhole
 - mkr - marker
 - p & r fence - post & rail fence
 - re - rodding eye
 - rs - road sign
 - rw - rain water pipe
 - sl - spot light
 - sv - stop valve
 - sw - soil vent pipe
 - tbn - temporary bench mark
 - thl - threshold level
 - tl - service light
 - toc - top of cap
 - top - top of pipe
 - tot - top of tank
 - tp - telecom pole
 - us - underside
 - ul - unable to lift
 - vp - vent pipe
 - wfc - water filled chamber
 - wm - water meter
 - wo - wash out
 - wp - waste pipe

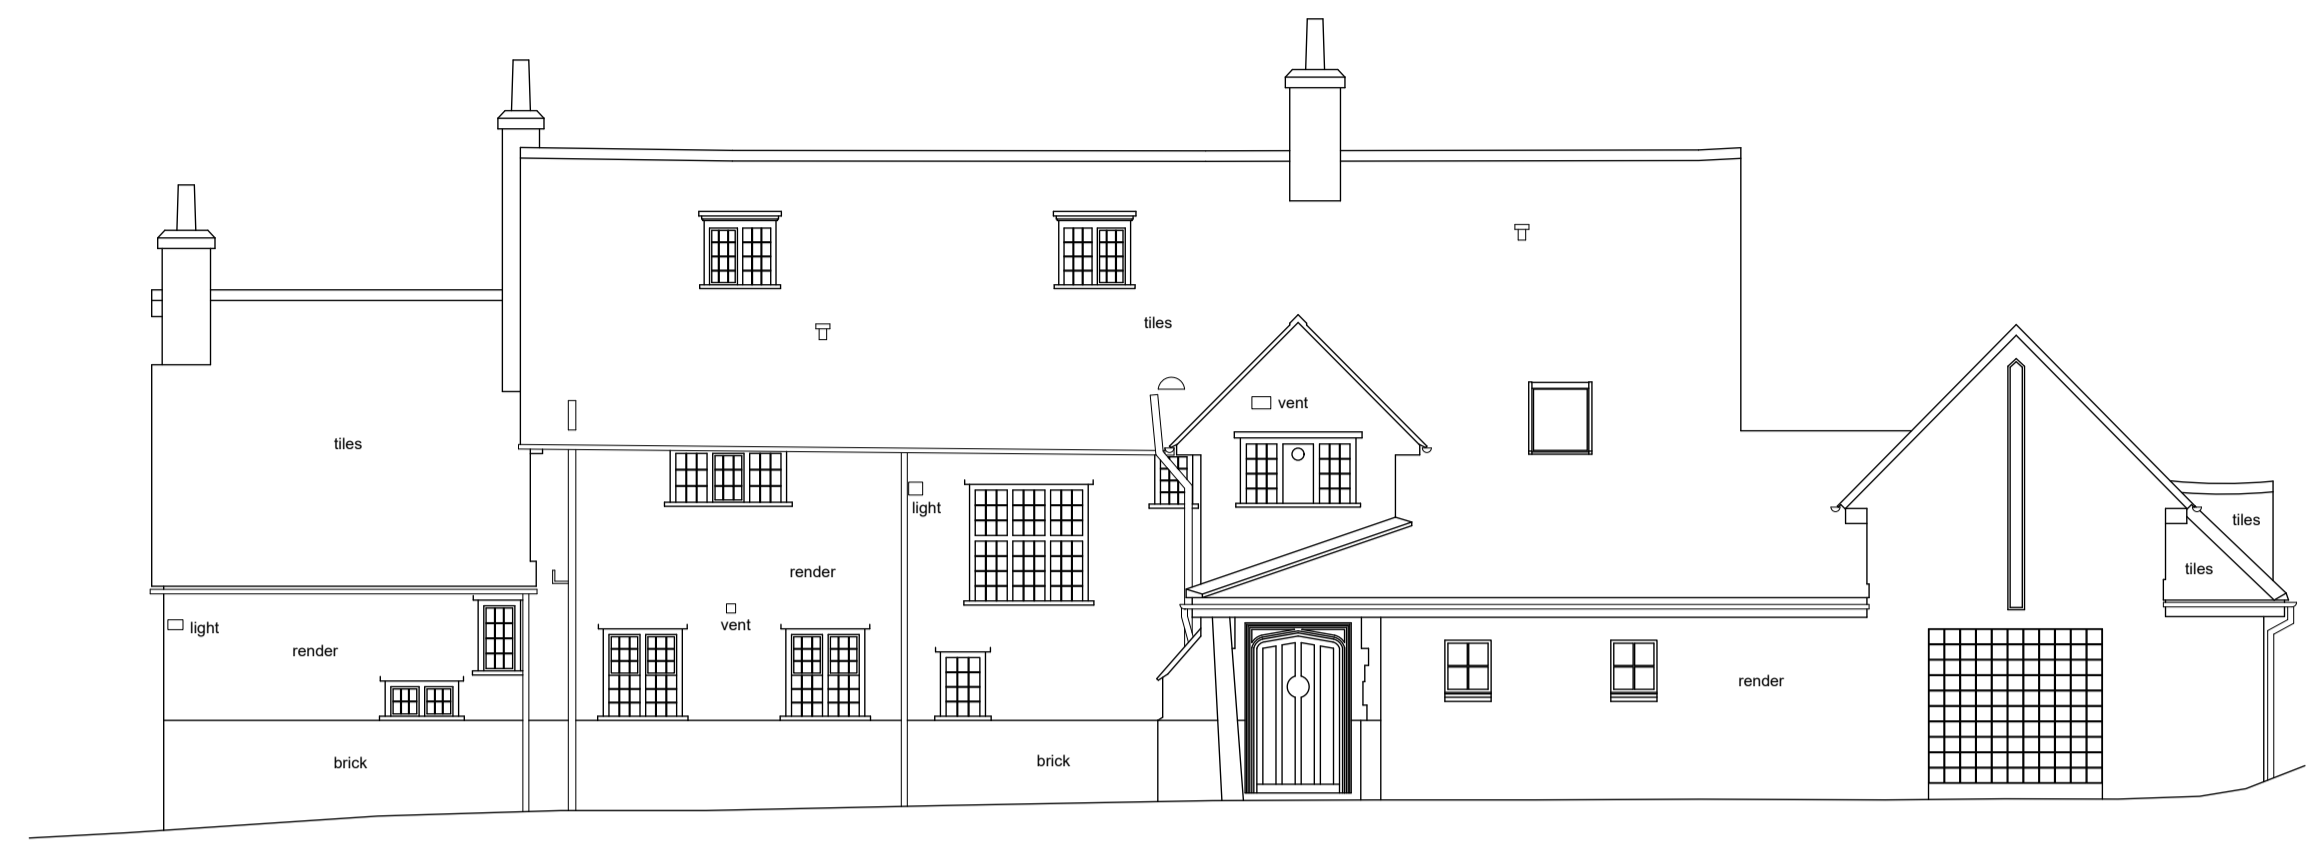


Datum 105.00m NORTH ELEVATION

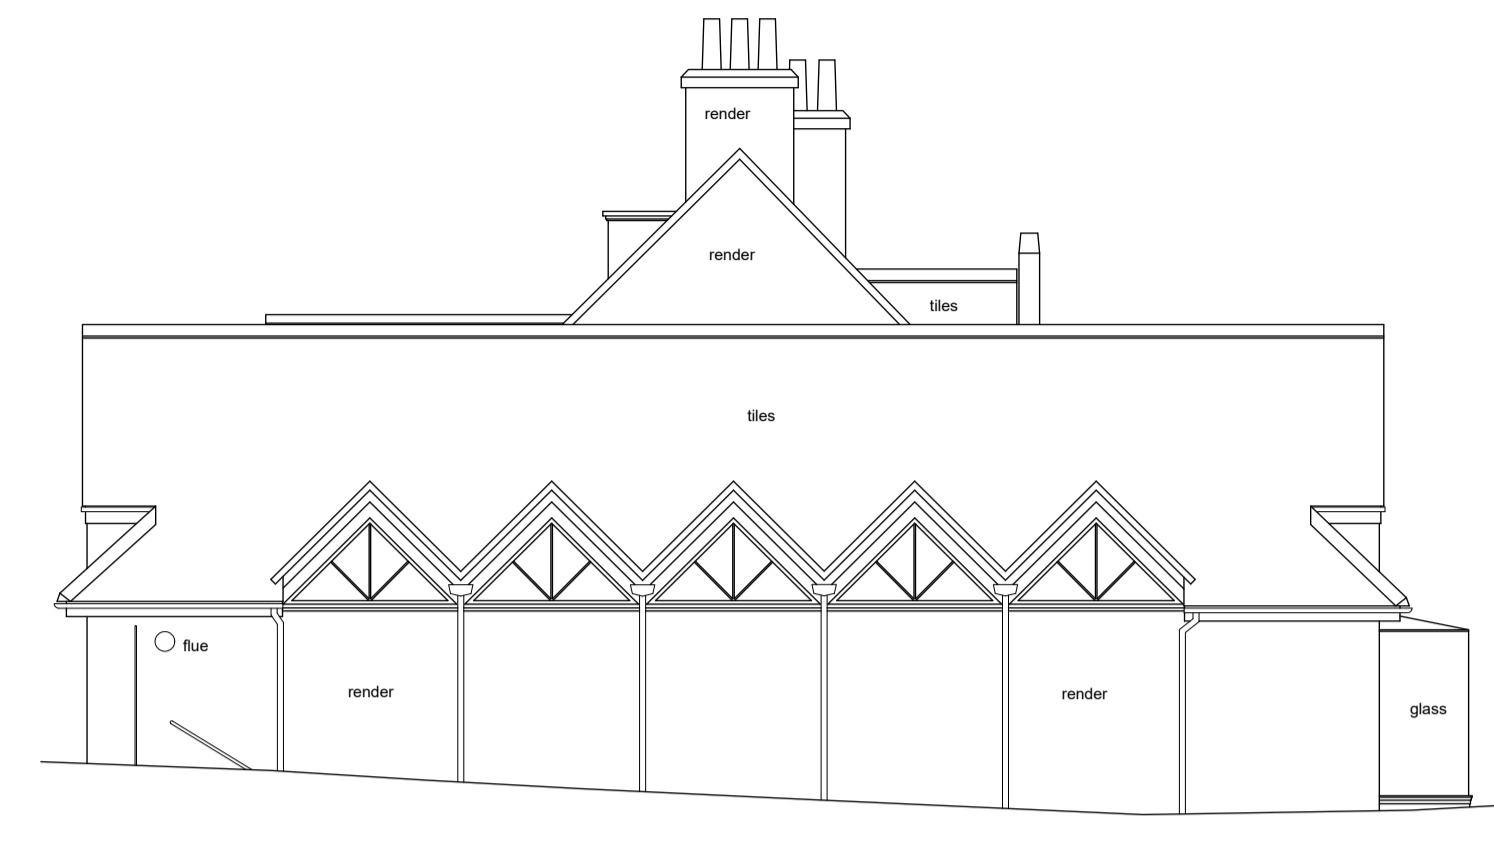


Datum 105.00m WEST ELEVATION




Datum 105.00m SOUTH ELEVATION

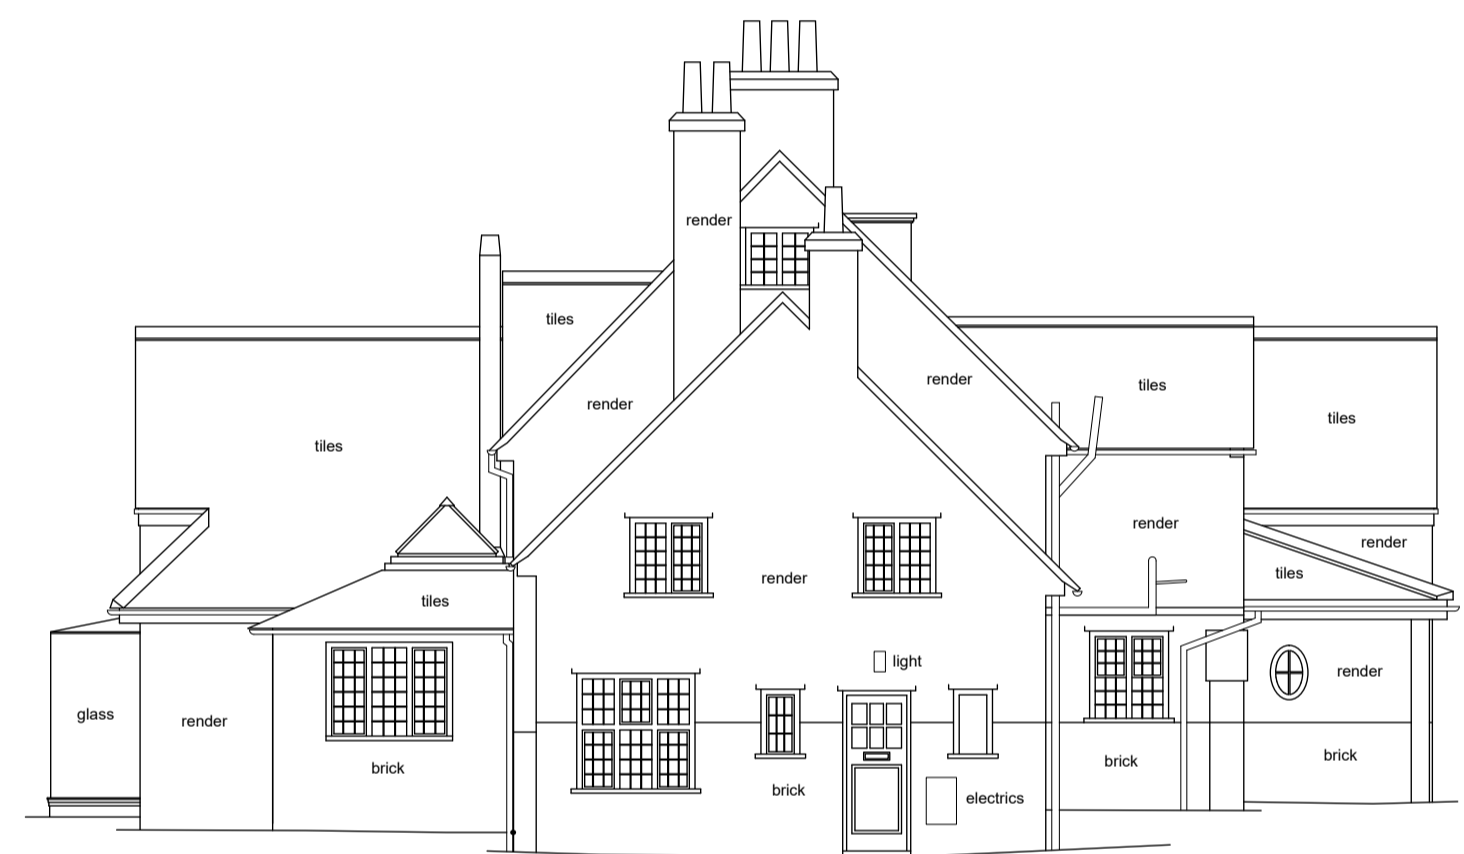


Datum 105.00m EAST ELEVATION

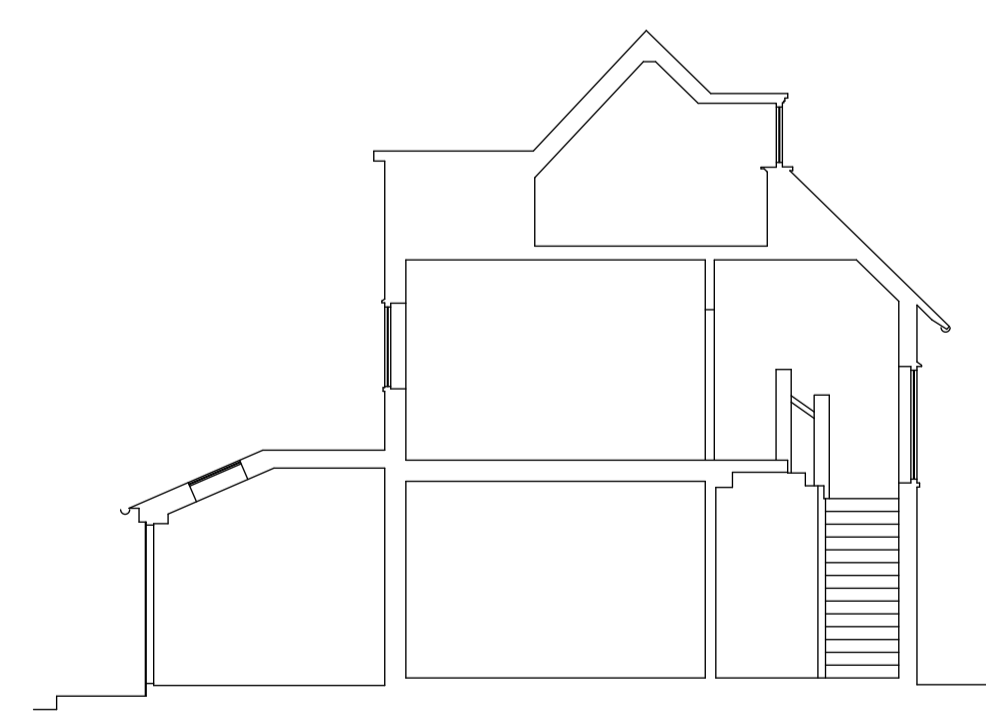

Datum 105.00m SECTION A-A

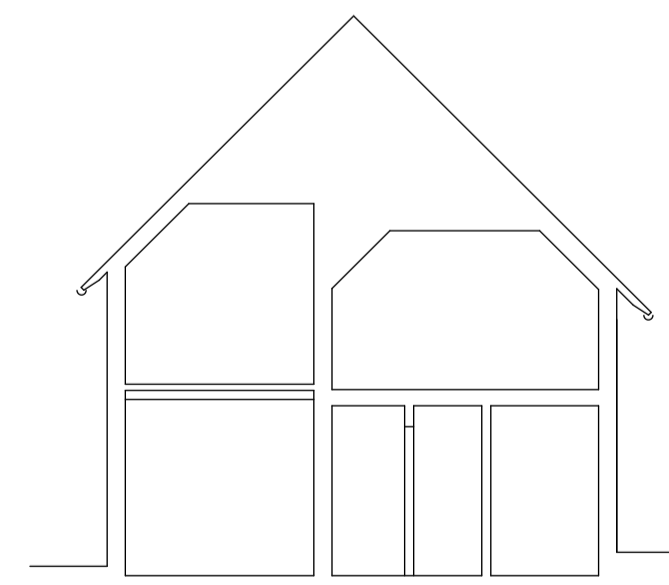

Datum 105.00m SECTION B-B

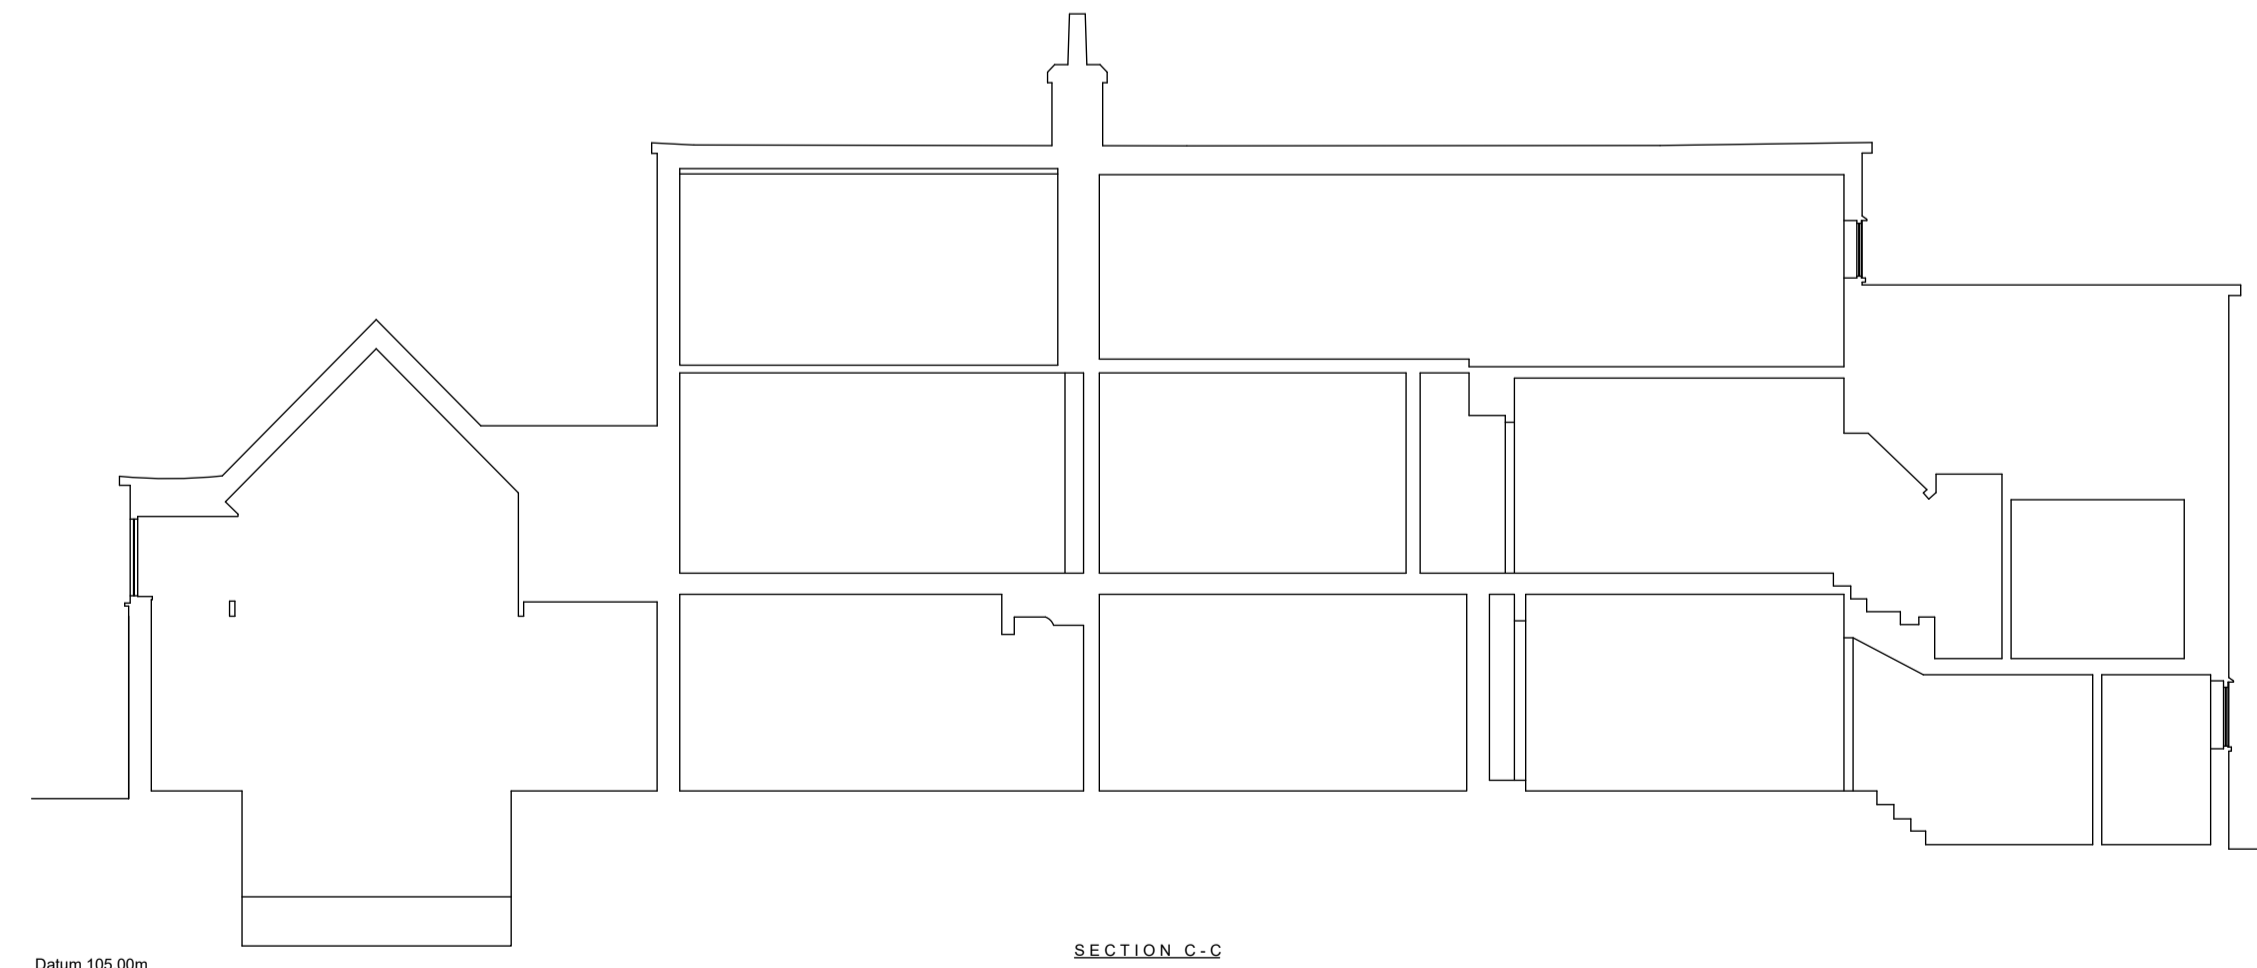

Datum 105.00m SECTION C-C

PROJECT			
THE BEECHES, HEYFORD ROAD, STEEPLE ASTON, OX25 4SN			
DRAWING TITLE			
ELEVATIONS & SECTIONS			
CLIENT			
STUDIO DB LIMITED			
SURVEY DATE	SHEET SIZE	SURVEYOR	CHECKED
NOV'23	A1	SJF	VCB
DRAWING NUMBER		SCALE	
1444-04		1:100	