


- NOTES**
- Contractors must check all dimensions on site. Only figured dimensions are to be worked from. Discrepancies must be reported to the Architect or Engineer before proceeding. © This drawing is copyright.
 - Reproduced from OS Sitemap © by permission of Ordnance Survey on behalf of The Controller of Her Majesty's Stationery Office. © Crown copyright 2008. All rights reserved. Licence number 100007124.
 - Until technical approval has been obtained from the relevant authorities, all drawings are issued as preliminary and not for construction. Should the Contractor commence site work prior to approval being given it is entirely at their own risk.
 - Woods Hardwick cannot accept liability for any discrepancies in terms of coordinates or any other information deciphered from dwgs.
 - The exact location and level of all existing sewers, drains and services to be confirmed on site prior to the commencement of any works.

SAFETY, HEALTH AND ENVIRONMENTAL

There are no exceptional risks associated with these works. Refer to the Designers Risk Assessment for the full assessment of risks.

It is assumed that all works will be carried out by a competent Contractor, where appropriate, to an approved method statement.

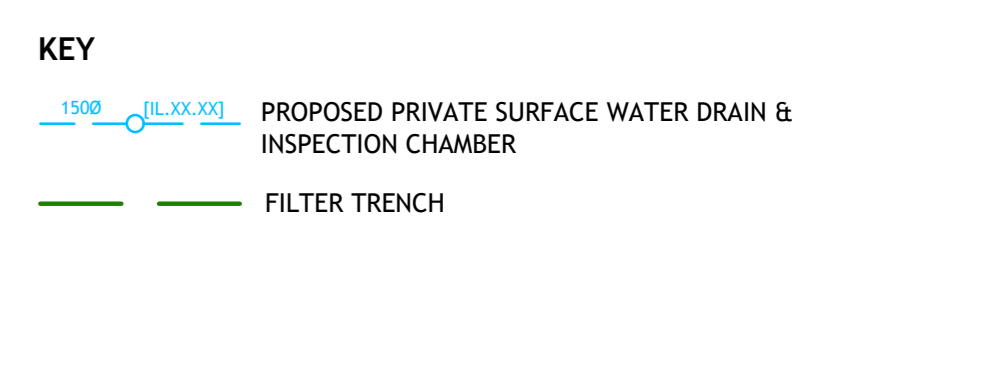

REV	DESCRIPTION	DRN	CHD	DATE	
<input type="checkbox"/>	PRELIMINARY	<input type="checkbox"/>	INFORMATION	<input type="checkbox"/>	TENDER
<input type="checkbox"/>	CONSTRUCTION	<input type="checkbox"/>	AS BUILT		

SCALE: 1:200 @ A0 DATE: JANUARY 2020

DRAWN: DH CHK: MDF

DRAWING NO: 18671-LPBA-5-SK001 REV

TITLE: LONGFORD PARK, BODICOTE, BANBURY - PHASE 3

DETAILS: MUGA & NEAP DRAINAGE LAYOUT

Woods Hardwick
Architecture | Engineering | Planning | Surveying

BEDFORD : HEAD OFFICE
15-17 Goldington Road
Bedford MK40 3NH
T: +44 (0) 1234 268862
ONLINE: mail@woodshardwick.com | woodshardwick.com

BIRMINGHAM
Fort Dunlop, Fort Parkway
Birmingham B24 9FE
T: +44 (0) 121 6297784

PLEASE CONSIDER THE ENVIRONMENT BEFORE PRINTING THIS DRAWING

