


FOR CONTINUATION
SEE DWG 7254

MATCH LINE

MATCH LINE
FOR CONTINUATION
SEE DWG 7256

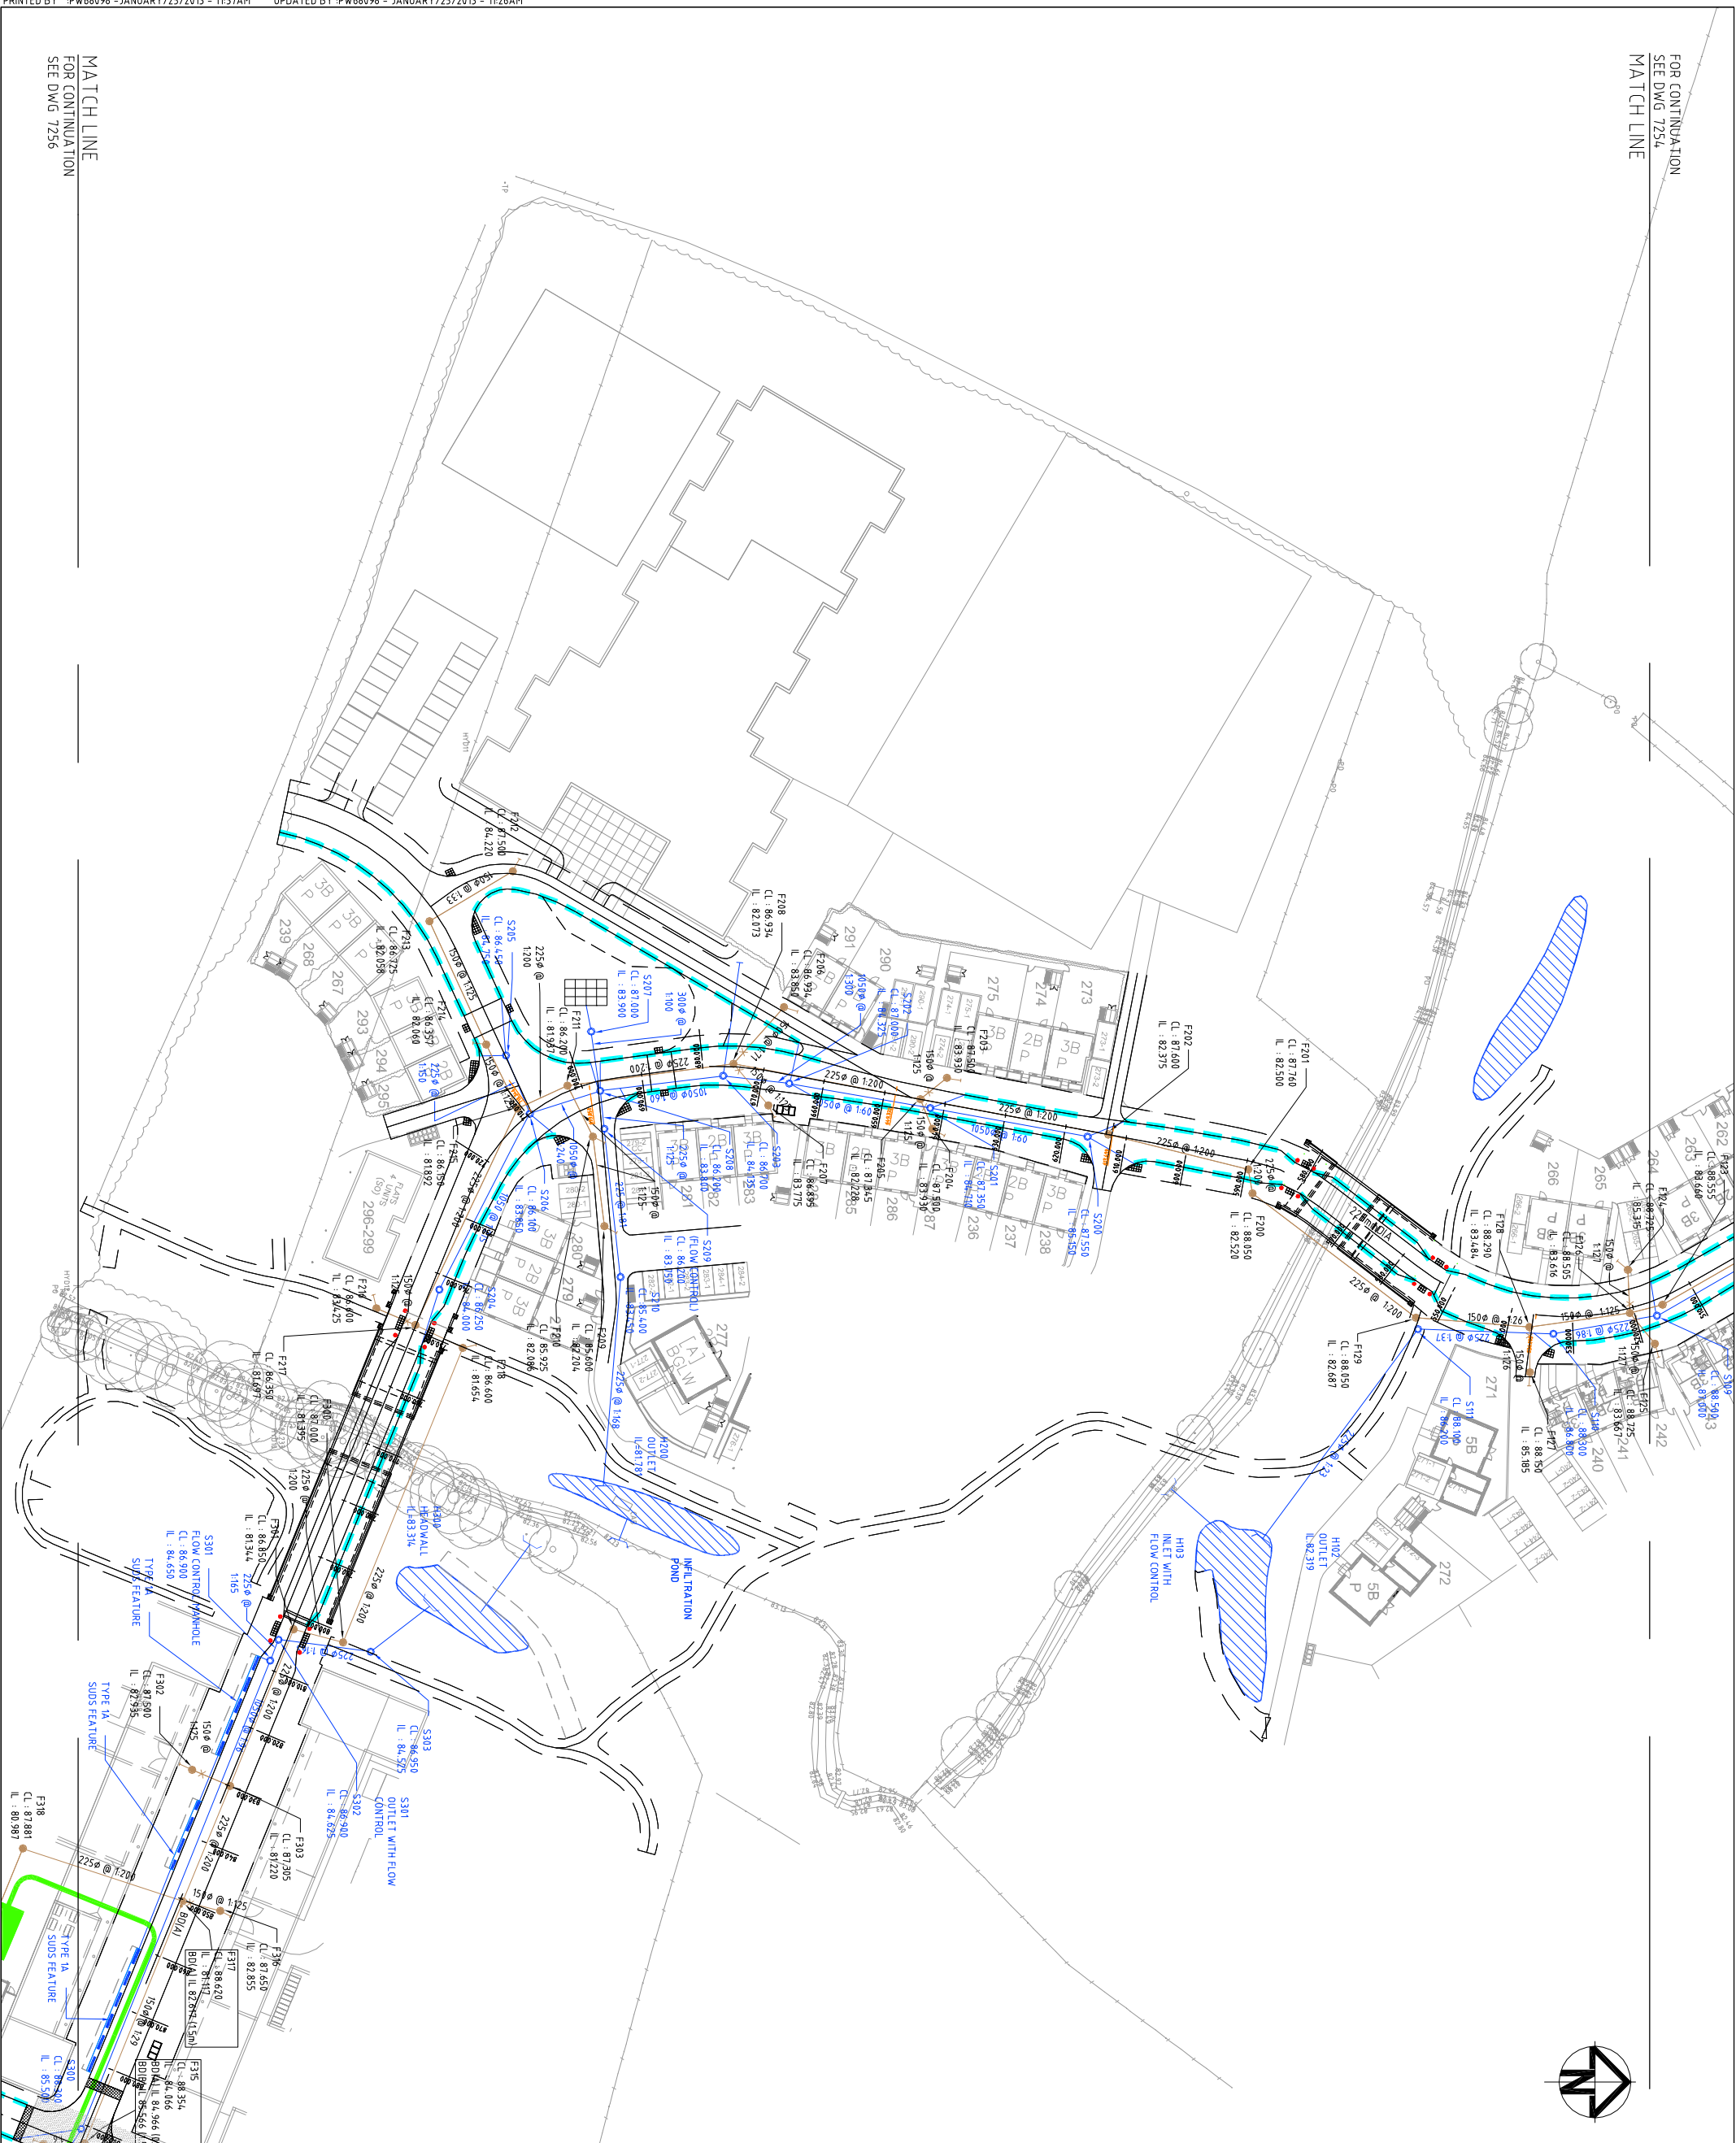

KEY

	SURFACE WATER DRAINAGE
	150mm DIA PIPE FOUL WATER DRAINAGE
	ROADSIDE SUDS FEATURE
	KERB DRAINAGE (HYDROKERB)
	FOUL PUMPING MAN
	MANHOLE WITH BACKDROP
	HEADWALL
	POND
	BASIN
	SWALE
	CELLULAR STORAGE

NOTES:
1. SCHEME TO BE LIT IN ACCORDANCE WITH OCC SPECIFICATIONS
2. AND IN LINE WITH OCC CARBON FOOTPRINT LIGHTING PRACTICES
3. OCC TO PROVIDE SCHEME LIGHTING LAYOUT AND DETAILS

1. DO NOT SCALE FROM THIS DRAWING. USE FIGURED DIMENSIONS ONLY.
2. ALL DRAWINGS TO BE CHECKED BY THE CONTRACTOR PRIOR TO CONSTRUCTION OR MANUFACTURE. ANY DISCREPANCIES TO BE REPORTED TO THE ENGINEER.
3. ALL WORKS TO BE UNDERTAKEN IN ACCORDANCE WITH MCHW - SPECIFICATION FOR HIGHWAY WORKS, SEWERS FOR ADOPTION AND OCC DETAILS AND SPECIFICATION.

11	DRAINAGE NOTE REMOVED	21/01/13
10	HIGHWAY BOUNDARY AND DRAINAGE REVISED	06/11/12
09	GENERAL REVISIONS	19/10/12
08	MASTERPLAN REVISED	05/10/12
07	DESIGN REVISED	21/07/12
06	DESIGN REVISED	22/06/12
05	DESIGN REVISED	MAR 12
04	POND CONNECTIONS REVISED	21.10.11
03	DRAINAGE CHECK ISSUE	05.10.11
02	DESIGN REVISED	JULY 11

Status	DRAFT
--------	-------

Scales	1:500	Author	MILTEWELIN
Original Size	A1	Checker	S.A.DAVIES
Height	0.5	Approver	S.A.DAVIES
Grid	0.5	Copyright reserved	

Client: **azdominion**
Files: 7253-7256-UA001881-UP21D-S38-12-SPINE ROAD DRAINAGE.DWG

Hyder Consulting (UK) Limited
28, Bressenden Place
London
SW1E 6DZ
Tel: +44 (0)870 000 3006
Fax: +44 (0)870 000 3006

Project	BICESTER ECO DEVELOPMENT EXEMPLAR SITE
Title	EXEMPLAR SITE (S38) FOUL AND SURFACE WATER DRAINAGE SHEET 3 OF 4
Drawing No	7255
Project No	UA001881
Issue	11