

DO NOT SCALE


This drawing is the property of Digi Design Co Architecture Ltd. Copyright is reserved by them and the drawing is issued on the condition that it is not used, copied, reproduced, retained or disclosed either wholly or in part, by or to any unauthorised persons, without previous consent in writing of Digi Design Co Architecture Ltd.

PLEASE CHECK ALL DIMENSIONS ON SITE PRIOR TO COMMENCING PROJECT

NOTES




West Elevation Scale 1:100

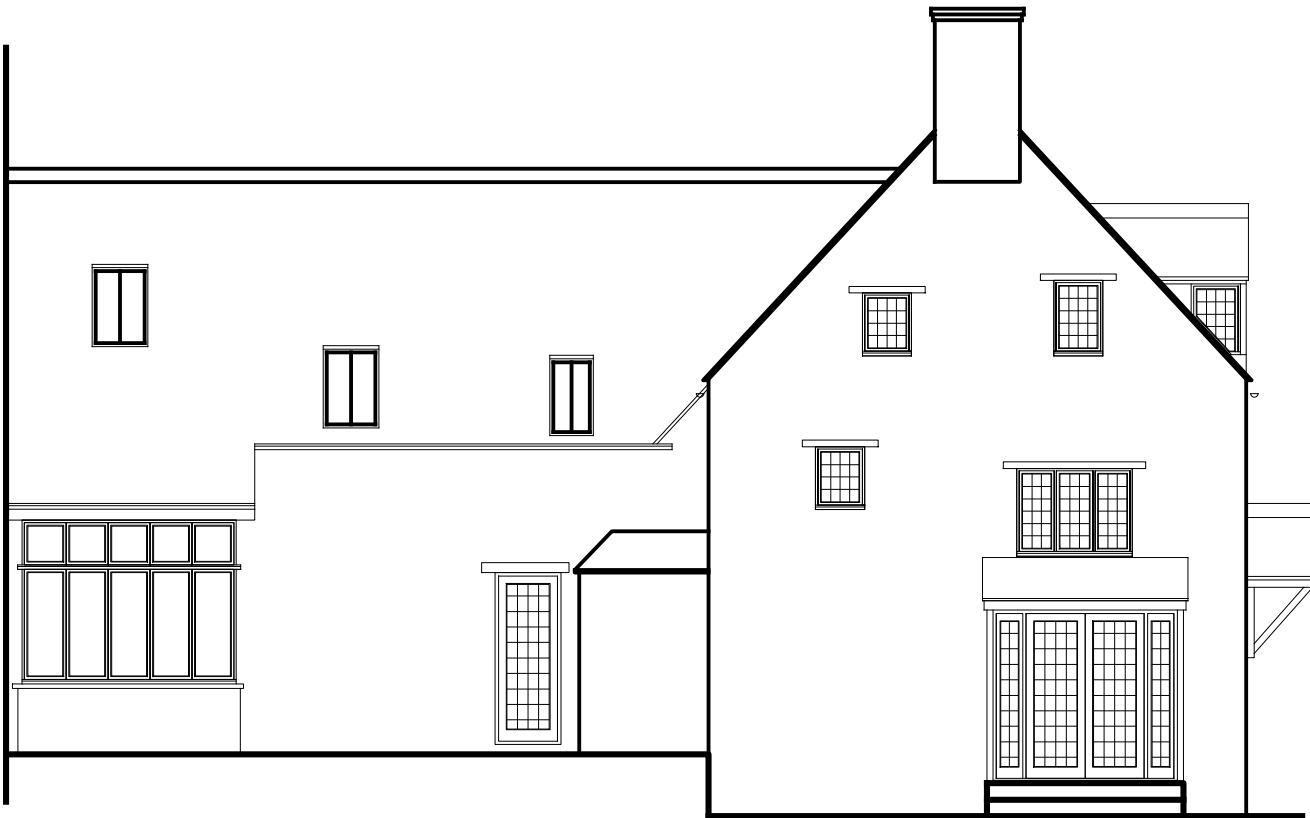


South Elevation Scale 1:100




East Elevation Scale 1:100

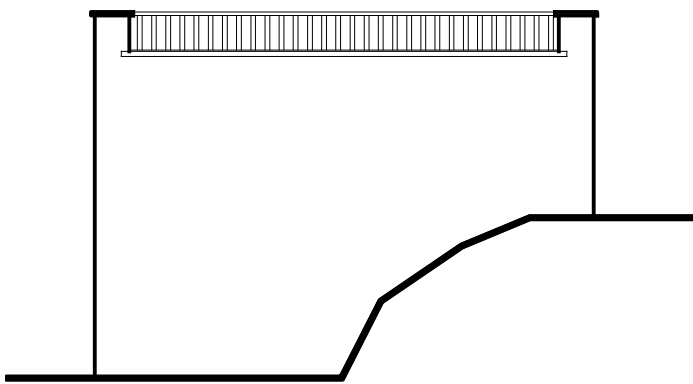


Garage East Elevation Scale 1:100

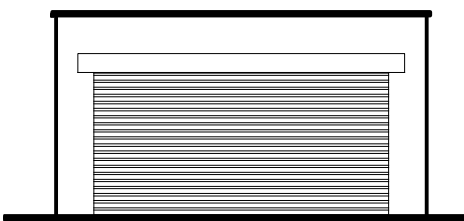


Garage North Elevation Scale 1:100

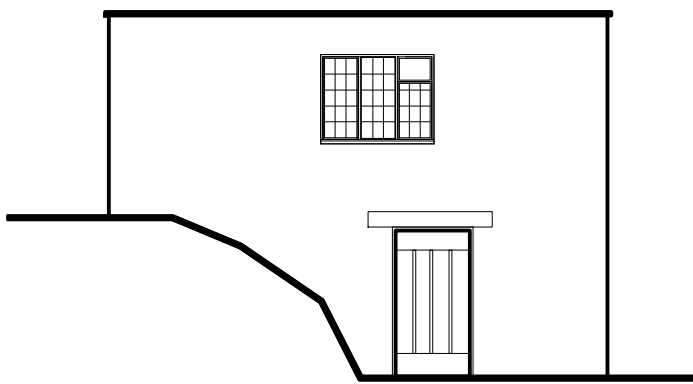


Garage West Elevation Scale 1:100

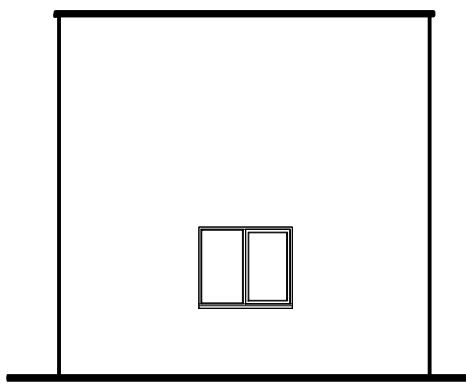


Garage South Elevation Scale 1:100

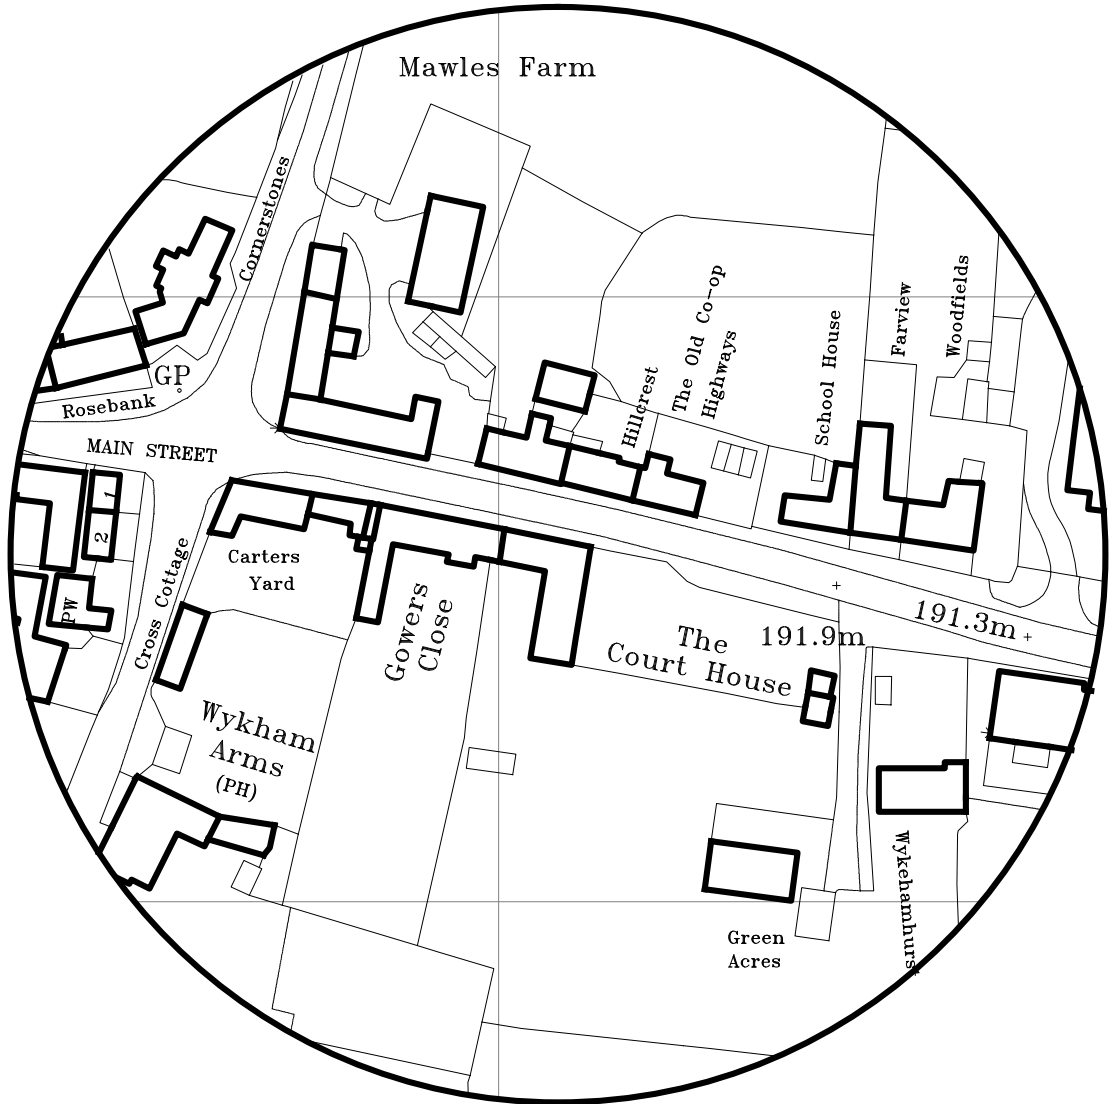

Location Plan Scale 1:1250

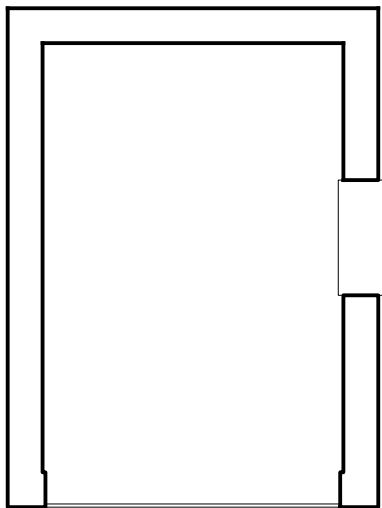

Garage Scale 1:100

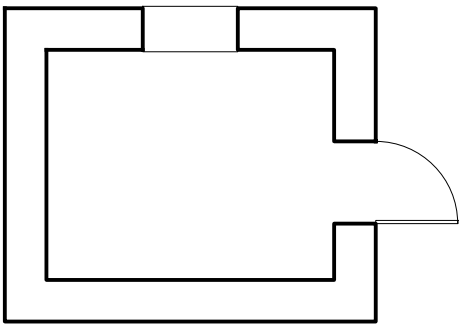

Garage Store Scale 1:100

Revisions		
Client		
Mrs S Thomas		
Project		
The Court House High Street Sibford Ferris Banbury Oxon OX15 5RW		
Drawing		
Survey - House & Garage Plans & Elevations		
Project Ref	Date	Drawing Number
DDC-2013-308	October 2013	001
Scale	Sheet Size	
AS SHOWN	A1	