

 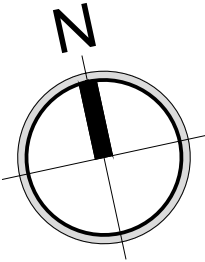


do not scale

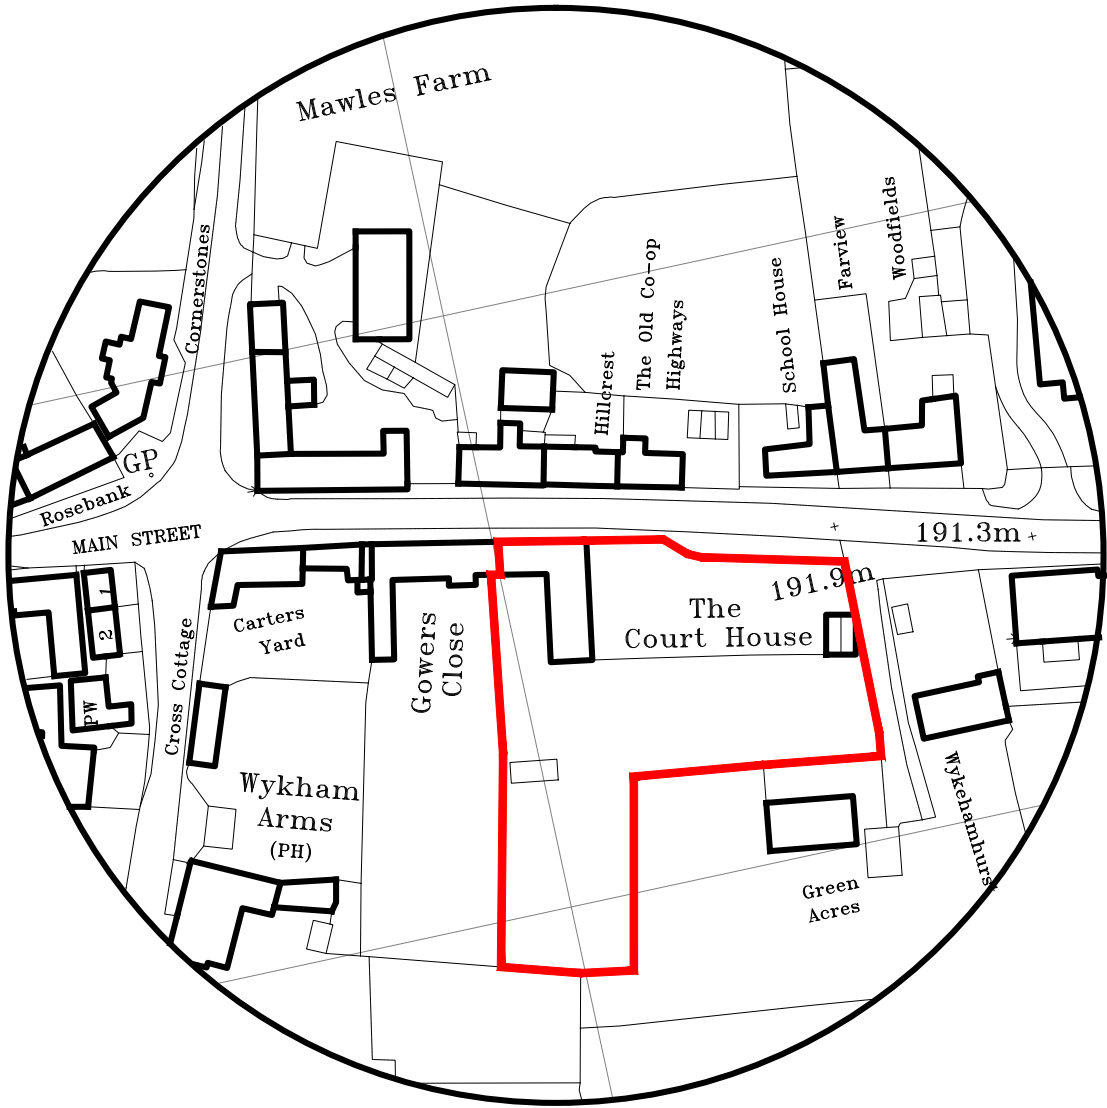

Location Plan Scale 1:1250



DIGI·DESIGN·CO
Architecture Ltd

5 Church Farm Court, Tysoe, Warwickshire. CV35 0TE.
T: +44 (0)1295 688182 M: +44 (0)7748 402723 F: +44 (0)8717 336037 <http://www.digidesignco.com>

drawing number
008

AS SHOWN @ A4
Scale
October 2013
job no
DDC-2013-308

The Court House, High Street, Sibford Ferris, Banbury, Oxon. Mrs S Thomas.
Garage Location Plan.

This drawing is the property of Digi Design Co Architecture Ltd. Copyright is reserved by them and the drawing is issued on the condition that it is not used, copied, reproduced, retained or disclosed either wholly or in part, by or to any unauthorised persons, without previous consent in writing of Digi Design Co Architecture Ltd.