


General Notes.

- Do not scale this drawing.
- This drawing is to be read in conjunction with all other relevant Engineers, Architects and specialist design drawings and details.
- All dimensions are in metres unless noted otherwise. All levels are in metres unless noted otherwise.
- Any discrepancies noted on site are to be reported to the Engineer immediately.
- The Contractor shall establish exact levels of the existing foul and surface water sewers, and/or proposed level at discharge point, prior to the commencement of any drainage works.
- The Contractor must ensure that the gradients indicated on the longitudinal sections are checked between the levels shown, prior to laying pipes. At no times must the contractor proceed with pipe laying by dialling the gradient shown into a laser without checking. Any discrepancy in this respect must be reported to the engineer prior to pipe laying.
- The Contractor shall check his pipe gradients by means of profiles and traveller to verify the laser gradients.
- In the event of the above procedures not being followed, the client will accept no responsibility whatsoever for any consequential loss or damage.
- The Contractor is responsible for ensuring that all works are to the satisfaction of the Engineer and shall be deemed to have included within his rates for any necessary testing.
- All pipes shall be laid with soffits level, unless otherwise specified.
- For highway and drainage layout refer to drawing no. 20488\_02\_015 - 021.

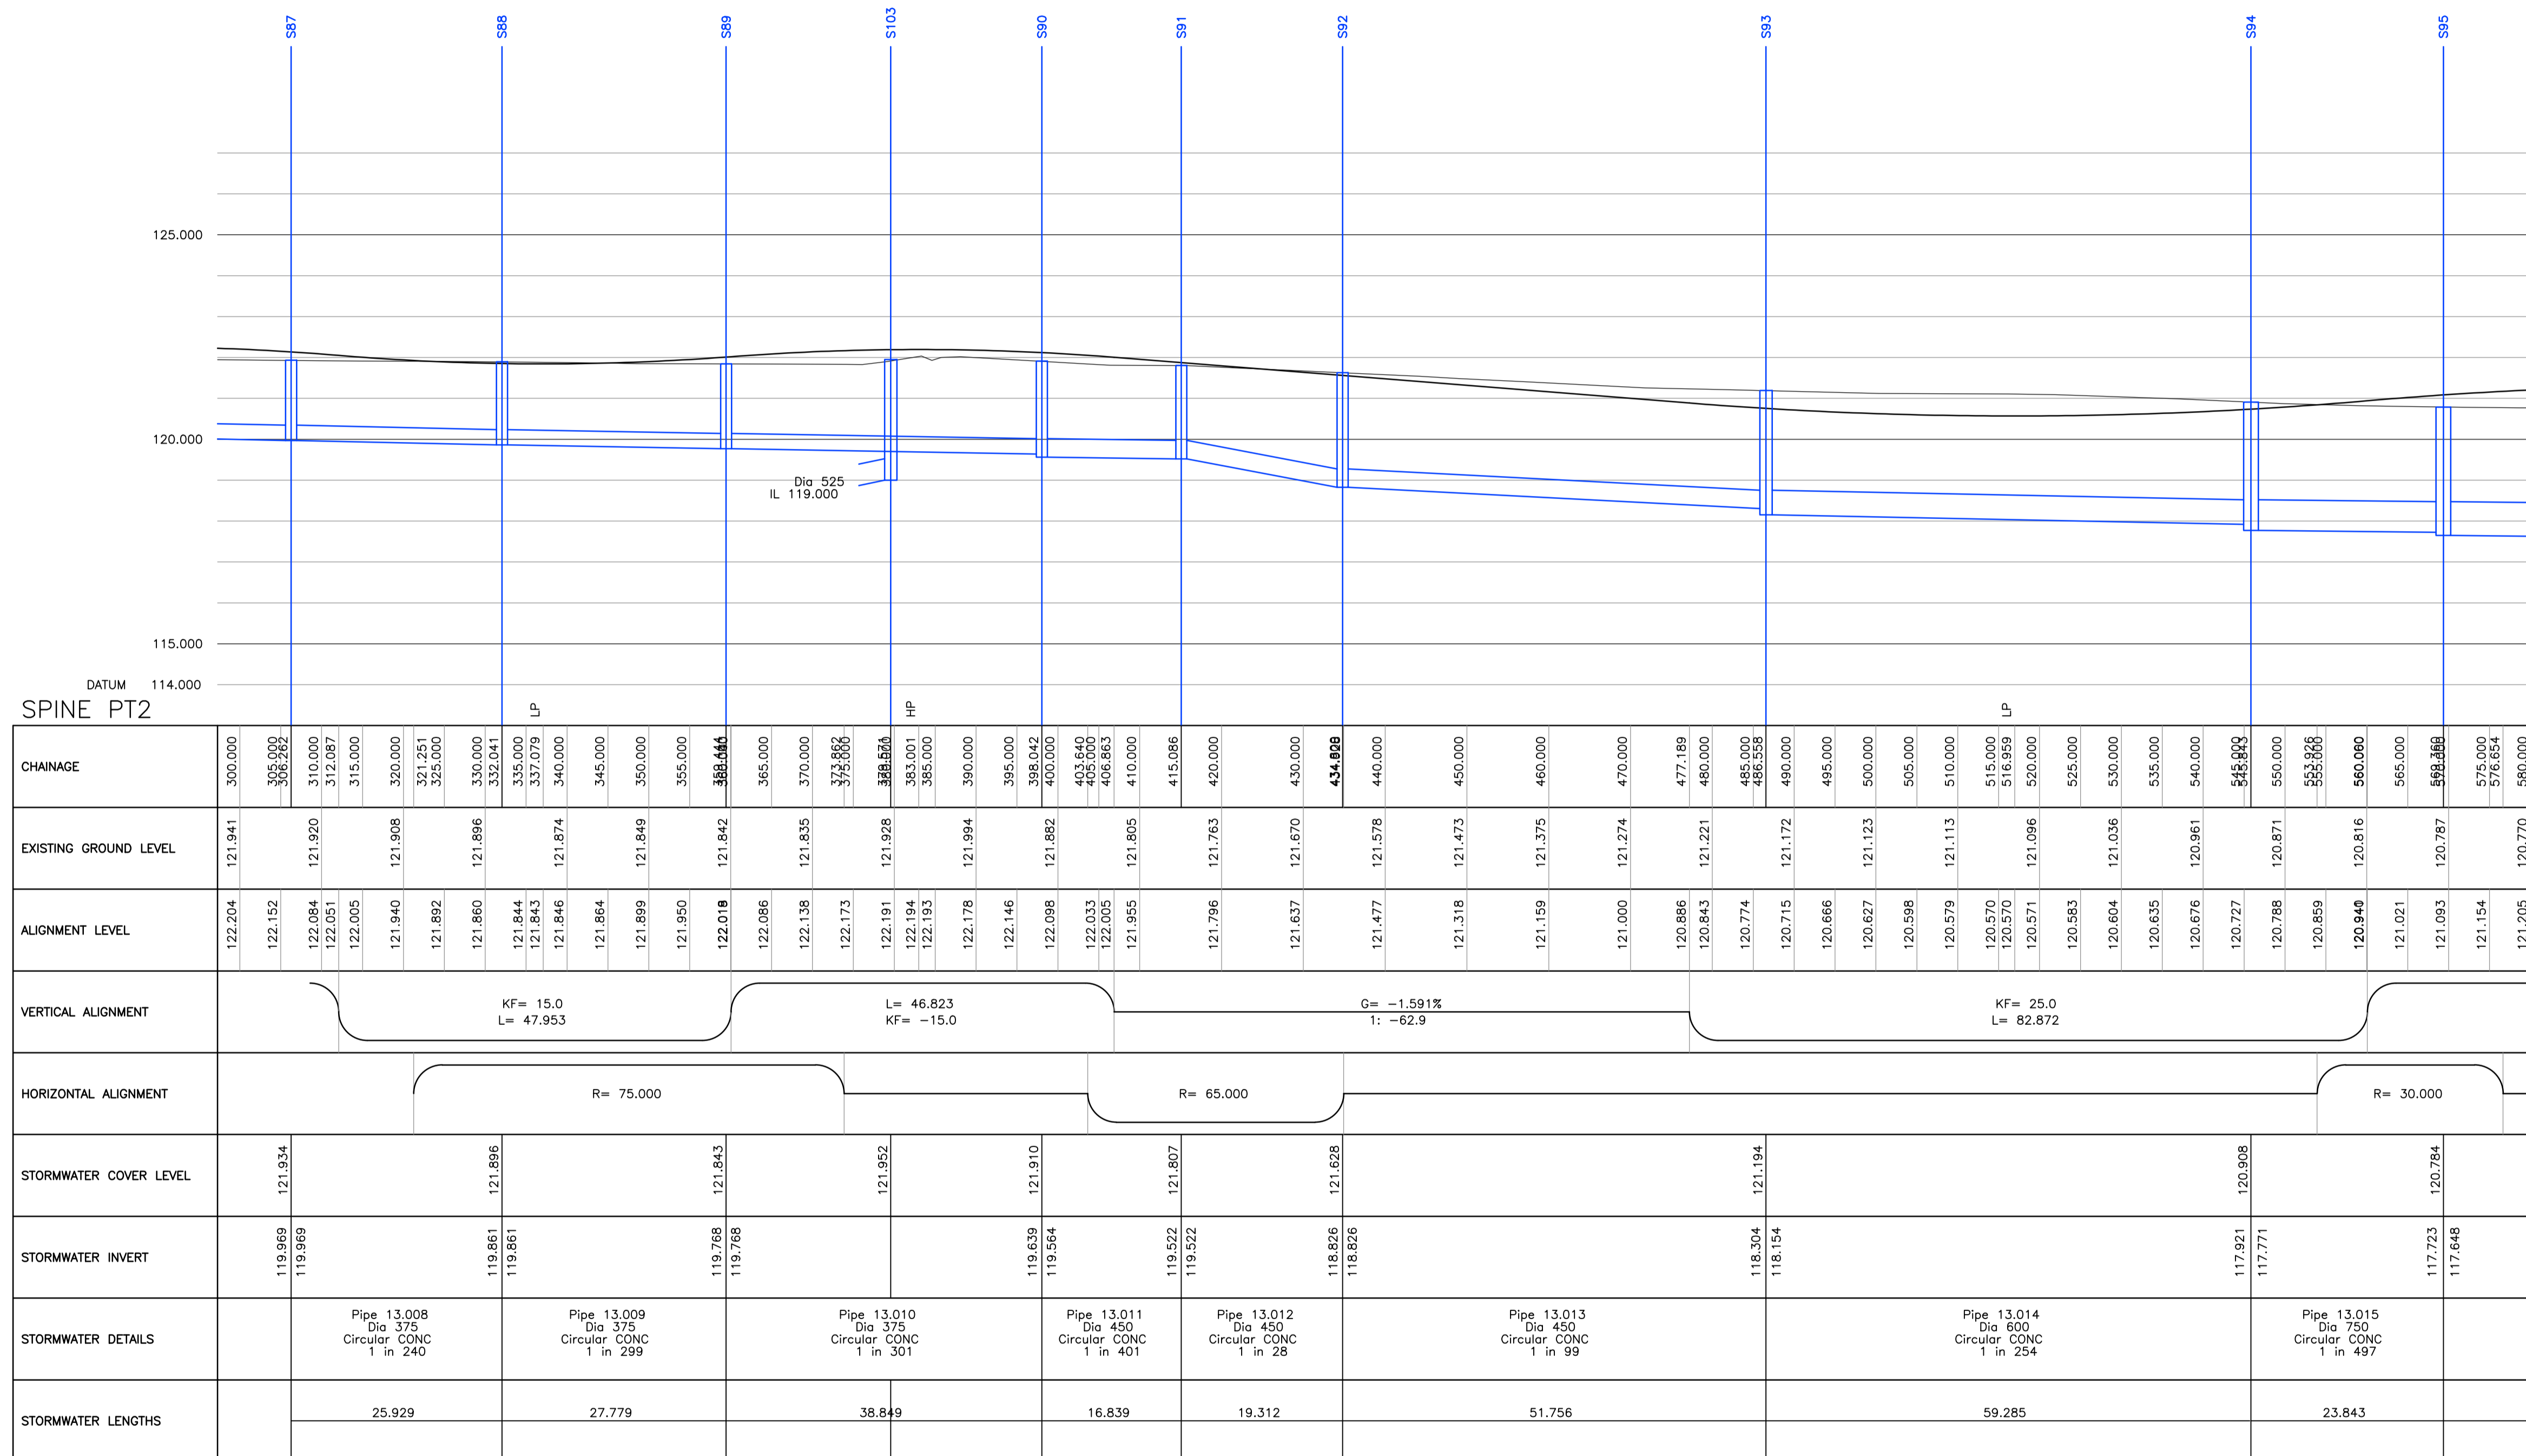

REV.	AMENDMENTS:	DRN.	CHK.	DATE.
PROJECT: LONGFORD PARK BODICOTE BANBURY				
DRAWING TITLE: SPINE ROAD PROFILES CHAINAGE 300.00 TO 580.000 SHEET 2 OF 3				
CLIENT: BARRATT HOMES, BOVIS HOMES TAYLOR WIMPEY				
DRAWING NUMBER: 20488_02_047				
REVISION: -	SHEET SIZE: A1	DATE: 03.03.14		
DRAWN BY: KA	CHECKED BY: DWM	SCALE: 1:500H, 1:100V		