 
 
 

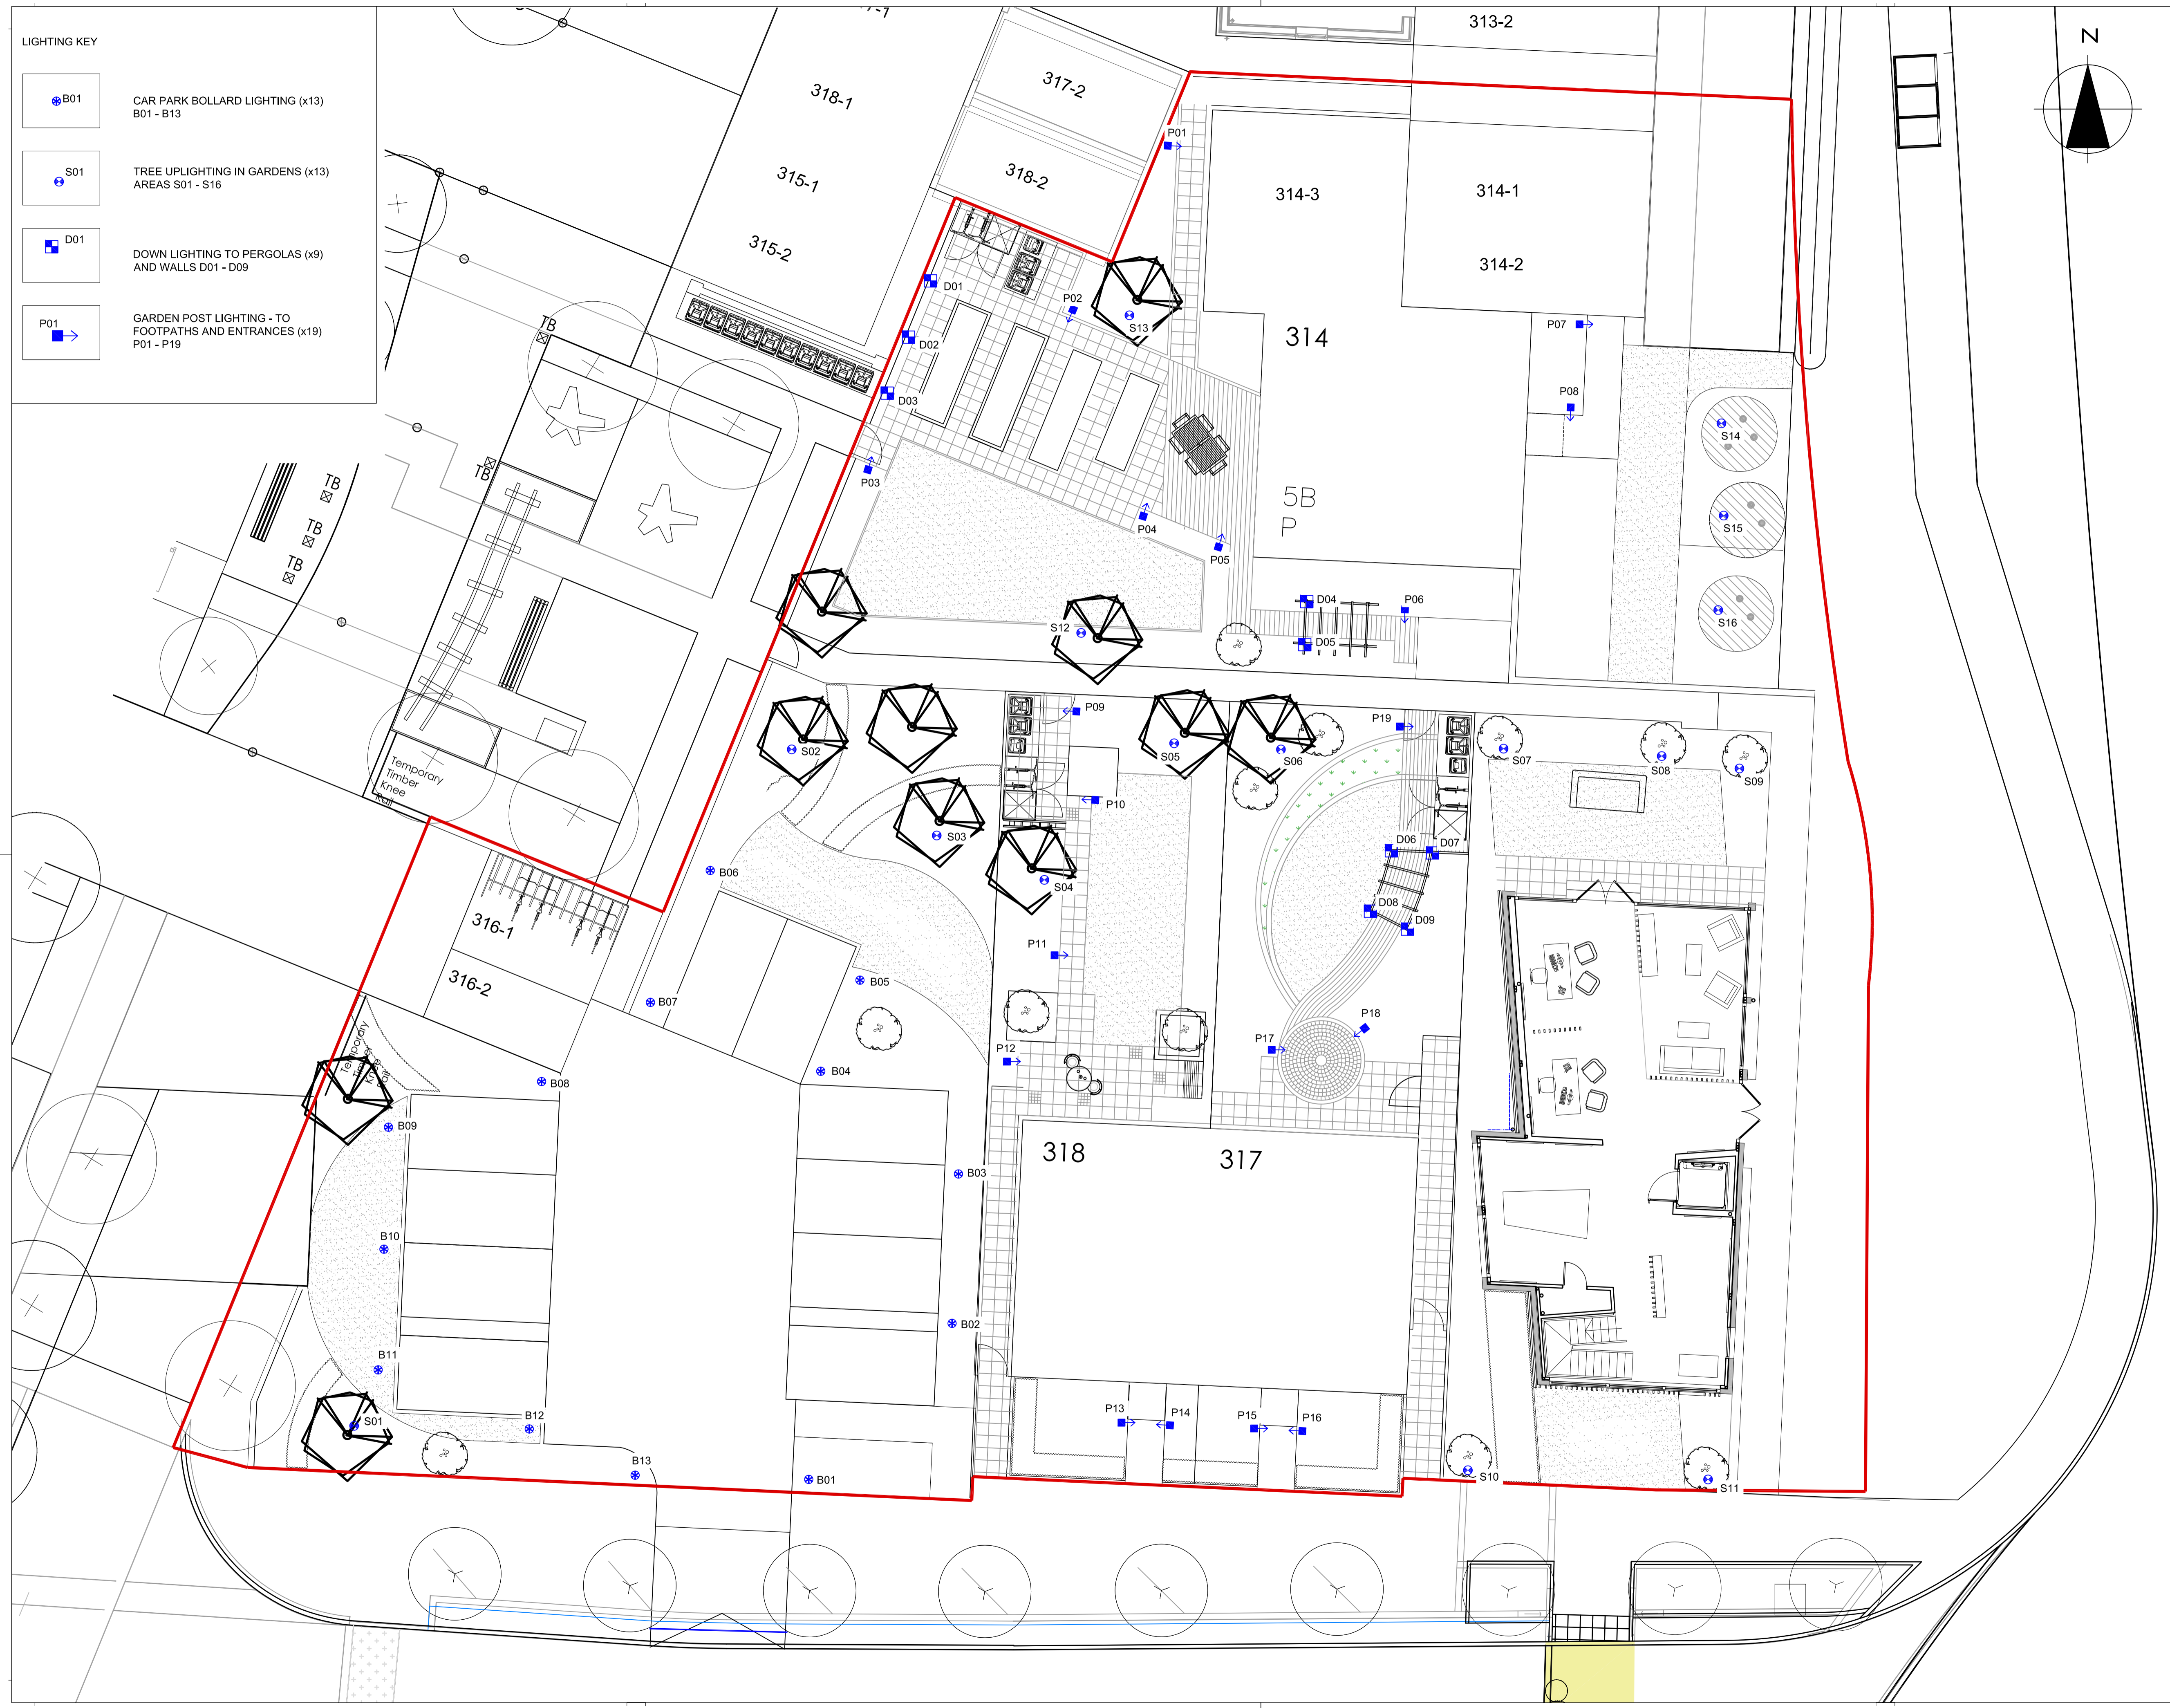


LIGHTING KEY

-  CAR PARK BOLLARD LIGHTING (x13)  
B01 - B13
-  TREE UPLIGHTING IN GARDENS (x13)  
AREAS S01 - S16
-  DOWN LIGHTING TO PERGOLAS (x9)  
AND WALLS D01 - D09
-  GARDEN POST LIGHTING - TO  
FOOTPATHS AND ENTRANCES (x19)  
P01 - P19



All dimensions to be verified on site. Plotted dimensions to take precedence to those scaled. Any areas indicated on this drawing are for guidance only, no responsibility is taken for their accuracy.  
This drawing is the property of Applied Landscape Design Limited. Copyright is reserved by them and the drawing is issued on the condition that it is not copied, reproduced, related or disclosed to any unauthorised person, either wholly or in part without the written consent in writing of Applied Landscape Design Limited.

© 2015 Applied Landscape Design Limited. All rights reserved.

- CDM/H&S:  
CDM RISKS  
The works illustrated on this drawing have been reviewed against the Design CDM Risk Register and significant risks are noted as:
- Construction:
- Contact with electrical fittings
- Maintenance:
- Contact with electrical fittings
- Demolition:
- Contact with electrical fittings
- Information on fittings and lamps to be provided to operator and future occupier

NOTES / KEY:  
NOTE: See Lighting Proposal Document ALD654\_RP903 for lighting fixture and fitting proposals

Buried or ducted cable requirements to M+E consultant specifications

REFERENCE DRAWINGS/DOCUMENTS	
ALD654_RP903	Lighting Proposal Document

REVISIONS		
no.	issued	date
P01	Tender	23.01.15

CLIENT:  
**A2DOMINION**

LANDSCAPE ARCHITECT:  
**ALD** applied landscape design  
The Threshing Barn, Bignell Park  
Barns, Chesterton, Nr. Bicester,  
Oxfordshire OX26 1TD  
Tel: 01869 243776  
Fax: 01869 327513  
Email: mail@appliedlandscape.co.uk

PROJECT:  
**BICESTER ECO TOWN  
EXEMPLAR SITE**

DRAWING TITLE:  
**SHOW HOME / MARKETING SUITE  
LIGHTING PLAN**

drawn: AF	checked: OM
scale: 1:100 @A1	date: 23.01.2014
status: Tender	xref file ref: ALD654_MPbaseshowhome
PROJECT NO. ALD654	DRAWING NUMBER: LL301
	REVISION: P01