


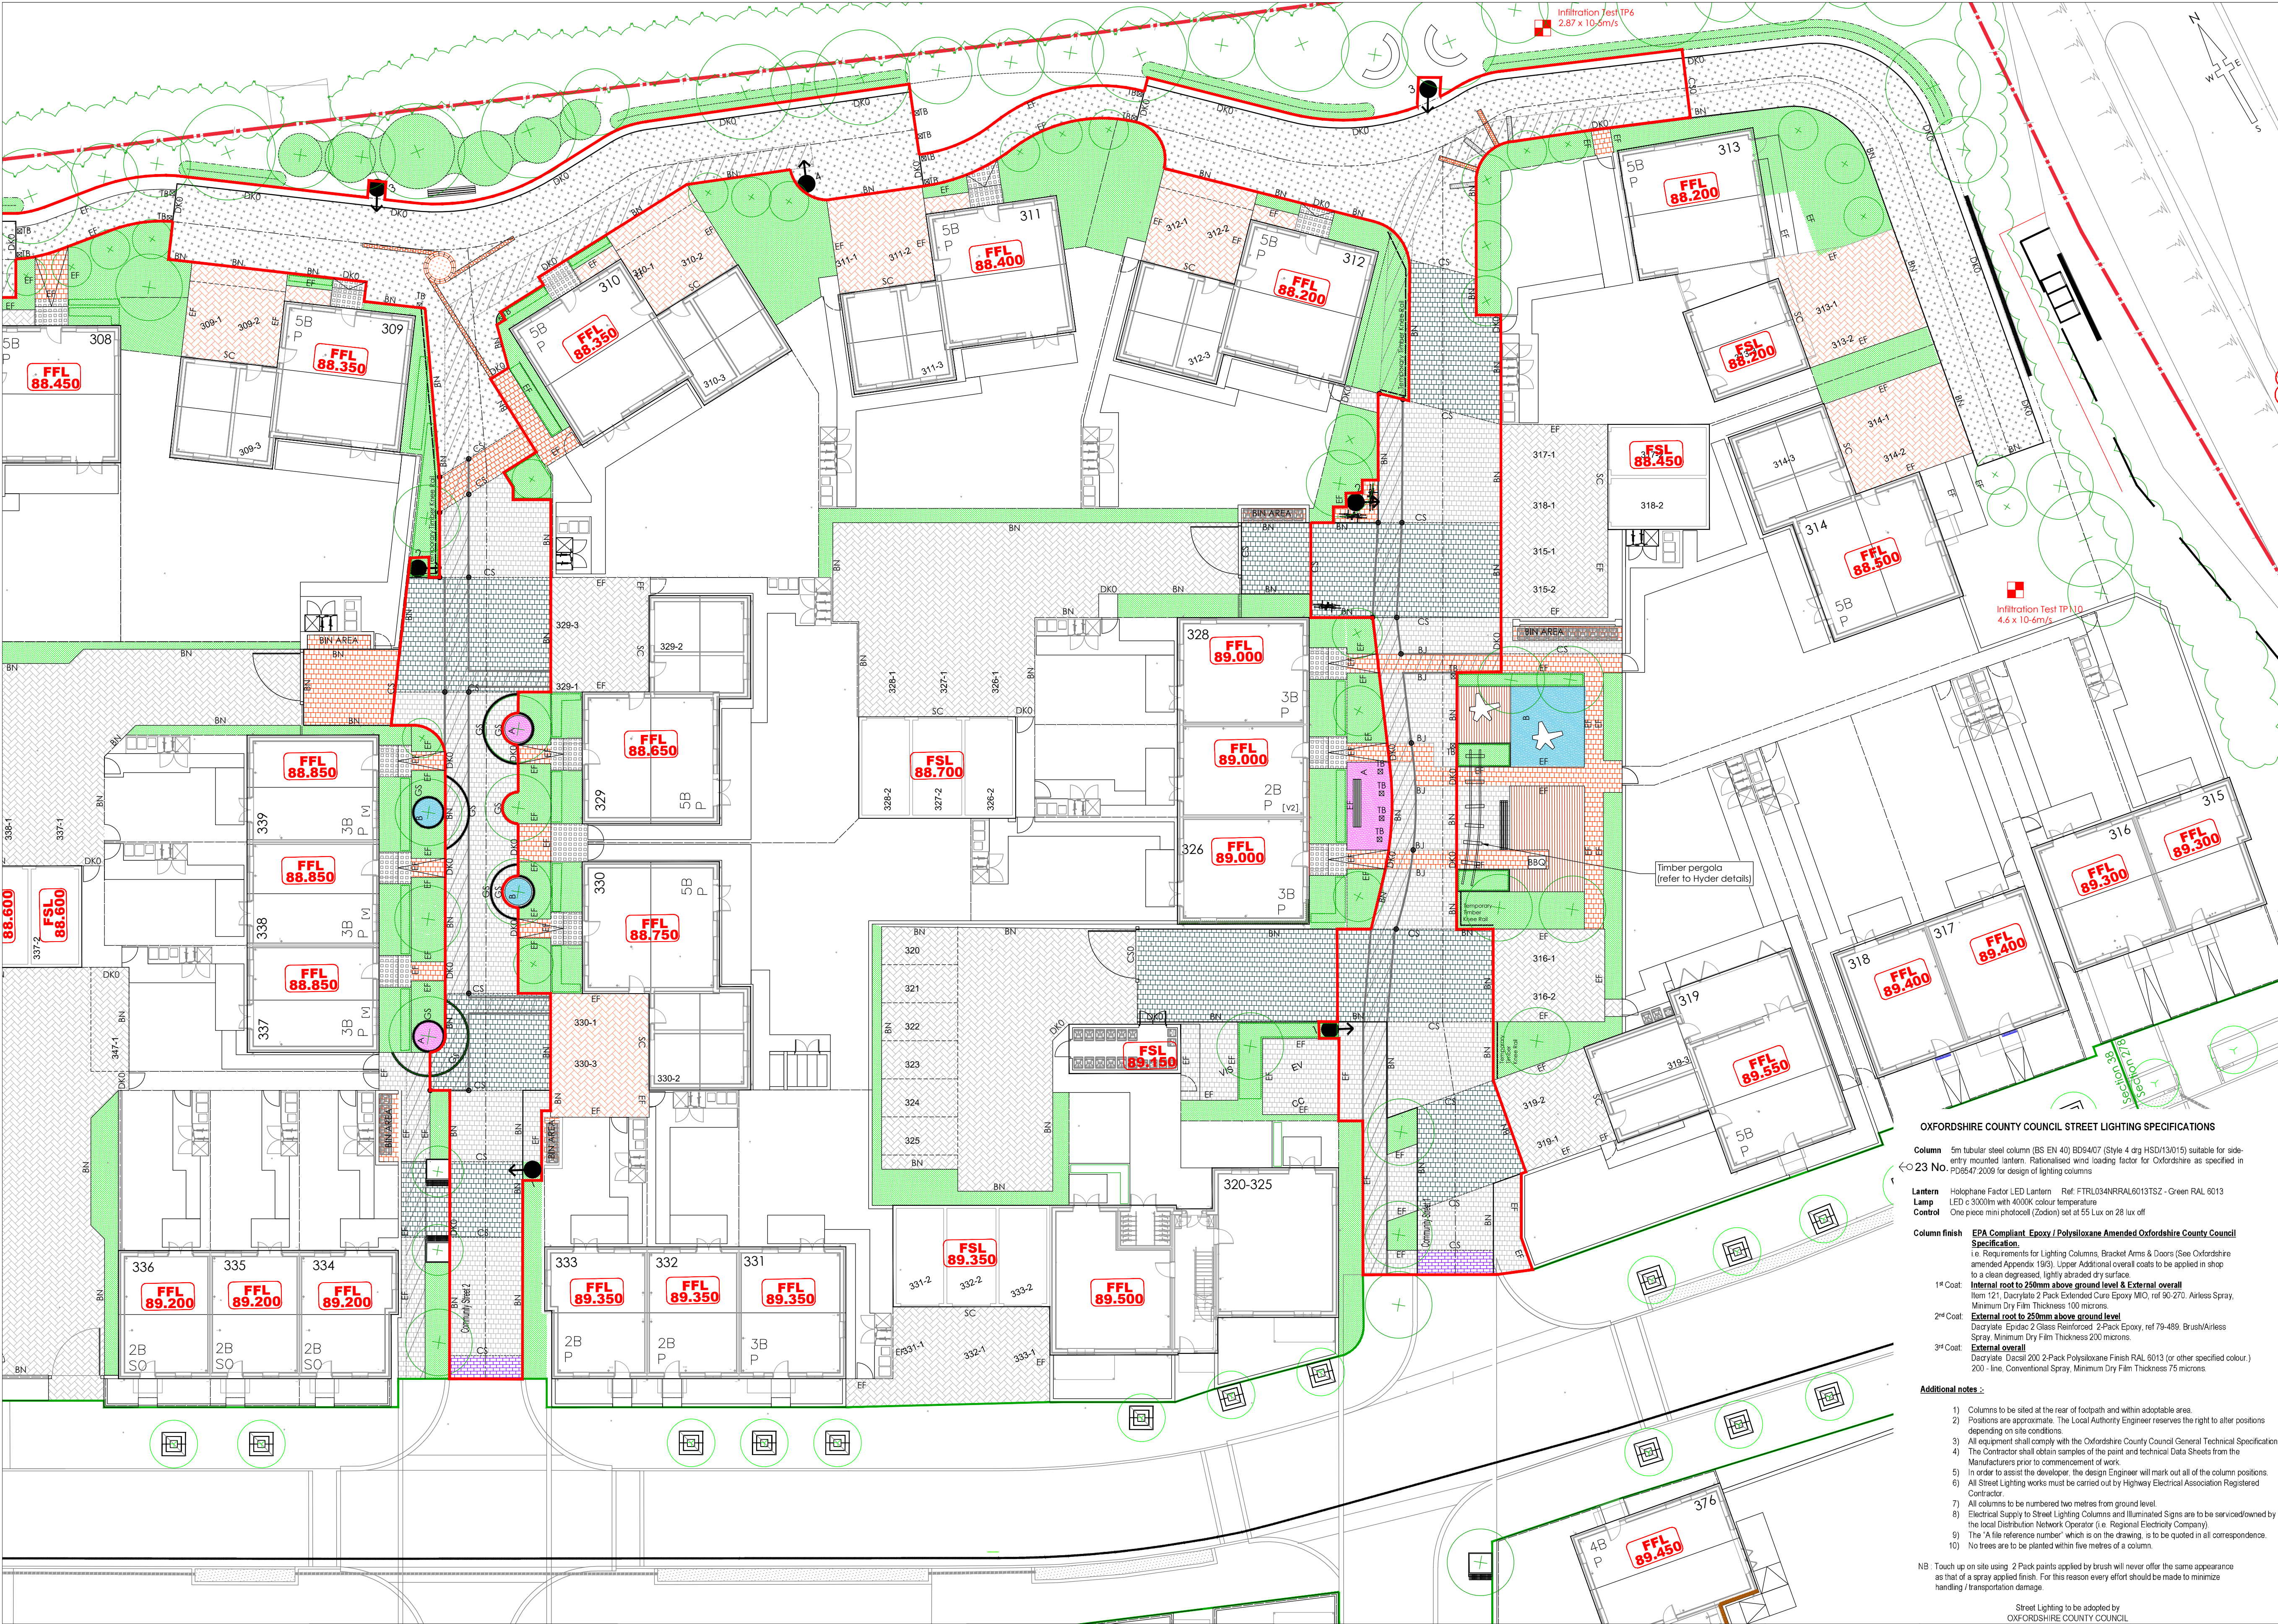

KERBING KEY	
HB2	- 125x255 HB2 kerbs (125mm face)
BN	- 125x150 BN15 dropped (15mm face)
DK 0	- 125x150 BN15 dropped (0mm face)
EF	- 50x150 EF edging (old flush)
T	- Dropper/infiltration kerb as required
CS	- square edged channel block
BJ	- Blocks Butt Jointed together
mb	- Highway marker block
TB	- Timber Bollard (OCC Approved)
CS	- Circle of Granite Setts
SC	- Stretcher Course

	Permeable Charcoal Andover Stratford Infilta Colour - Silver Grey (refer to drg 11-1196-20 - Detail B)
	Permeable Charcoal Woburn Rumble Infilta Colour - Rustic (refer to drg 11-1196-20 - Detail B)
	Permeable Charcoal Andover Stratford Infilta Colour - Charcoal (refer to drg 11-1196-21 - Detail A)
	Permeable Charcoal Infilta Colour - Grey (refer to drg 11-1196-21 - Detail A)
	Permeable Charcoal Infilta Colour - Burnt Oker (refer to drg 11-1196-21 - Detail A)
	Impermeable Charcoal Woburn Rumble Colour - Graphite (refer to drg 11-1196-21 - Detail B)
	Impermeable Natratex surfacing (with contrasting inset colour where noted on plans) (refer to drg 11-1196-20 - Detail A)
	Soft landscaping (refer to Hyder drawings)
	Ecadeck (refer to detail on drg 11-1196-20)
	Granite Setts (refer to detail on drg 11-1196-20)
	Impermeable Blocks to be used within designated areas
	Proposed Service Margin
	Resin bond gravel
	Brass stud or equivalent to denote the edge of the service margin
	Proposed Limit of O.C.C. Section 38 adoption To be agreed
	Limit of Phase 1 works - Refer to Hyder drawings for details of Spine Road
	Sureset Recycled Glass 6mm Aggregate set within granite setts sunk into ground Colour A=Wild Lavender, Colour B=Pacific (refer to detail on drg 11-1196-20)
	Timber Bollard with reflective strip (OCC approved)
	Extent of concrete wall to service trench
	Drainage channel

To be read in conjunction with drg 12-1196-07 Com 1 & Com 2
OCC Lighting Ref: A 4 2 3 6

OXFORDSHIRE COUNTY COUNCIL STREET LIGHTING SPECIFICATIONS

Column 5m tubular steel column (BS EN 40) 6054407 (Style 4 drg HSD13015) suitable for side-entry mounted lantern. Rationalised wind loading factor for Oxfordshire as specified in PD6547/2019 for design of lighting columns

Lantern Holophone Factor LED Lantern Ref: FTRL034NRRAL6013TSZ - Green RAL 6013
Lamp LED c 3000lm with 4000K colour temperature
Control One piece mini photocell (Zodion) set at 55 Lux on 28 lux off

Column finish EPA Compliant Epoxy / Polysiloxane Amended Oxfordshire County Council Specification.
i.e. Requirements for Lighting Columns, Bracket Arms & Doors (See Oxfordshire amended Appendix 19/3). Upper Additional overall coats to be applied in shop to a clean degreased, lightly abraded dry surface.
1st Coat: Internal root to 250mm above ground level & External overall Item 121, Dacrylate 2 Pack Extended Cure Epoxy MIO, ref 90-270, Airless Spray, Minimum Dry Film Thickness 100 microns.
2nd Coat: External root to 250mm above ground level Dacrylate Epidac 2 Glass Reinforced 2-Pack Epoxy, ref 79-489, Brush/Airless Spray, Minimum Dry Film Thickness 200 microns.
3rd Coat: External overall Dacrylate Dacal 200 2-Pack Polysiloxane Finish RAL 6013 (or other specified colour.) 200 - line, Conventional Spray, Minimum Dry Film Thickness 75 microns.

Additional notes:
1) Columns to be sited at the rear of footpath and within adoptable area.
2) Positions are approximate. The Local Authority Engineer reserves the right to alter positions depending on site conditions.
3) All equipment shall comply with the Oxfordshire County Council General Technical Specification. The Contractor shall obtain samples of the paint and technical Data Sheets from the Manufacturers prior to commencement of work.
4) In order to assist the developer, the design Engineer will mark out all of the column positions. All Street Lighting works must be carried out by Highway Electrical Association Registered Contractor.
5) All columns to be numbered two metres from ground level.
6) Electrical Supply to Street Lighting Columns and Illuminated Signs are to be serviced/downed by the local Distribution Network Operator (i.e. Regional Electricity Company).
7) The 'A' file reference number which is on the drawing, is to be quoted in all correspondence.
8) No trees are to be planted within five metres of a column.
NB Touch up on site using 2 Pack paints applied by brush will never offer the same appearance as that of a spray applied finish. For this reason every effort should be made to minimize handling / transportation damage.

Street Lighting to be adopted by OXFORDSHIRE COUNTY COUNCIL

WILLMOTT DIXON HOUSING	
REVIEWED	
PRELIMINARY	STATUS
FOR COMMENT	A
FOR CONSTRUCTION	B
SIGNED	C
DATE	

TITLE
Surface Finishes and Kerb Types
Sheet 2 of 4
Bicester Southfields Eco Village
Bicester
Oxon

DRAWING NUMBER
12-1196-04 Sheet 2 of 4 Rev C04

CLIENT	Rev	Drawn by	Chk'd by	Comments	Date	NOTES
	C01	NJ	TST	Issued for construction	23/09/14	1. All dimensions and levels are in metres unless otherwise noted
	C02	NJ	TST	Community street 2 service crossings relocated	08/11/14	2. This drawing is to be read in conjunction with the relevant Architect's/Engineer's drawings, specifications and CDM documentation
	C03	SNN	TST	Kerb types added to Parking areas & Driveways	27/02/15	3. This drawings has been produced electronically and may have been photo reduced or enlarged when copied. Work to figured dimensions only (DO NOT SCALE). All dimensions to be checked on site. Any errors or omissions to be reported to the engineer immediately.
	C04	NJ	TST	Key amended, refer to clouded area	02/07/15	4. This drawing contains coloured lines / information that may not be clear if reproduced in black and white.

Note
Lighting Column Installation
All columns must be installed within 1 metre of the design position on the lighting layout drawing, otherwise the lighting performance will be impaired.
Landscaping and Planting
Landscaping or planting around the column must be kept at a low level to avoid obstructing the luminaire and must be suitably maintained to avoid any future obstruction that may occur from the long term growth of plants. No account is taken for the blocking effect caused by buildings, trees etc.

DATE
10/01/2013
SCALE
1:200 @ A1
STATUS
CONSTRUCTION
DESIGNED BY
TST
0m 5m 10m
scale bar @ 1:200

Infrastruct CS Ltd

INFRASTRUCT CS LTD
Consulting Civil and Structural Engineers
26A High Street, Eynsham, Oxford, OX29 4HB
Tel: 01865 880909
Email: info@infrastructcs.co.uk
Web: www.infrastructcs.co.uk