
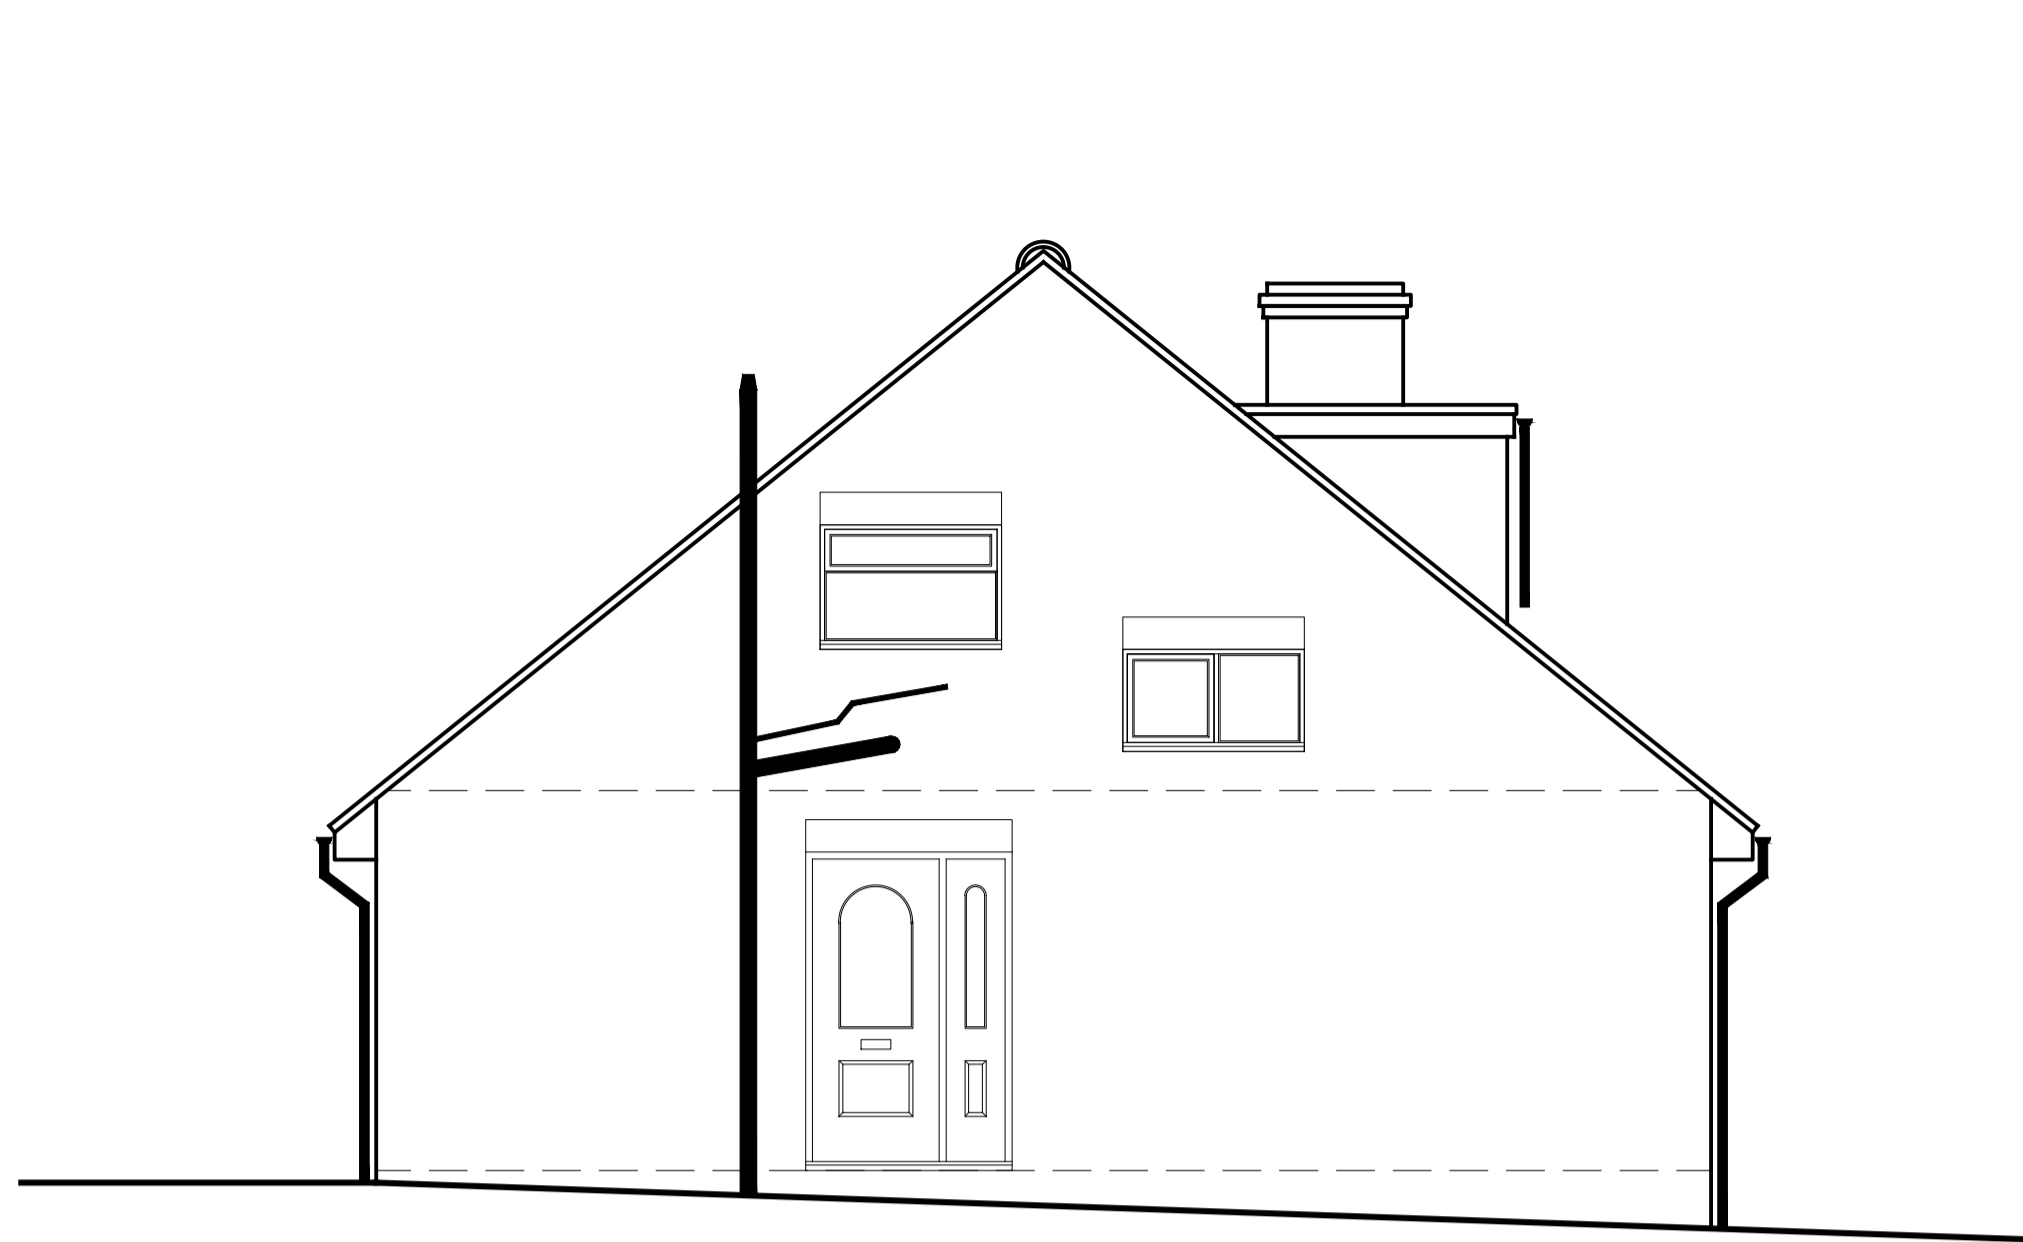


DO NOT SCALE


This drawing is the property of Digi Design Co Architecture Ltd. Copyright is reserved by them and the drawing is issued on the condition that it is not used, copied, reproduced, retained or disclosed either wholly or in part, by or to any unauthorised persons, without previous consent in writing of Digi Design Co Architecture Ltd.

PLEASE CHECK ALL DIMENSIONS ON SITE PRIOR TO COMMENCING PROJECT


NOTES

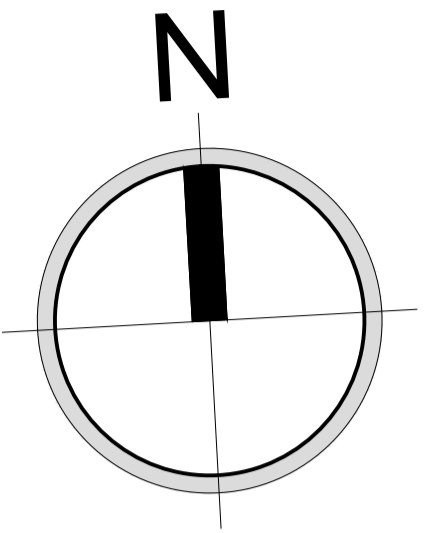


West Elevation Scale 1:50
0.0m 1.0m 2.0m 3.0m 4.0m 5.0m

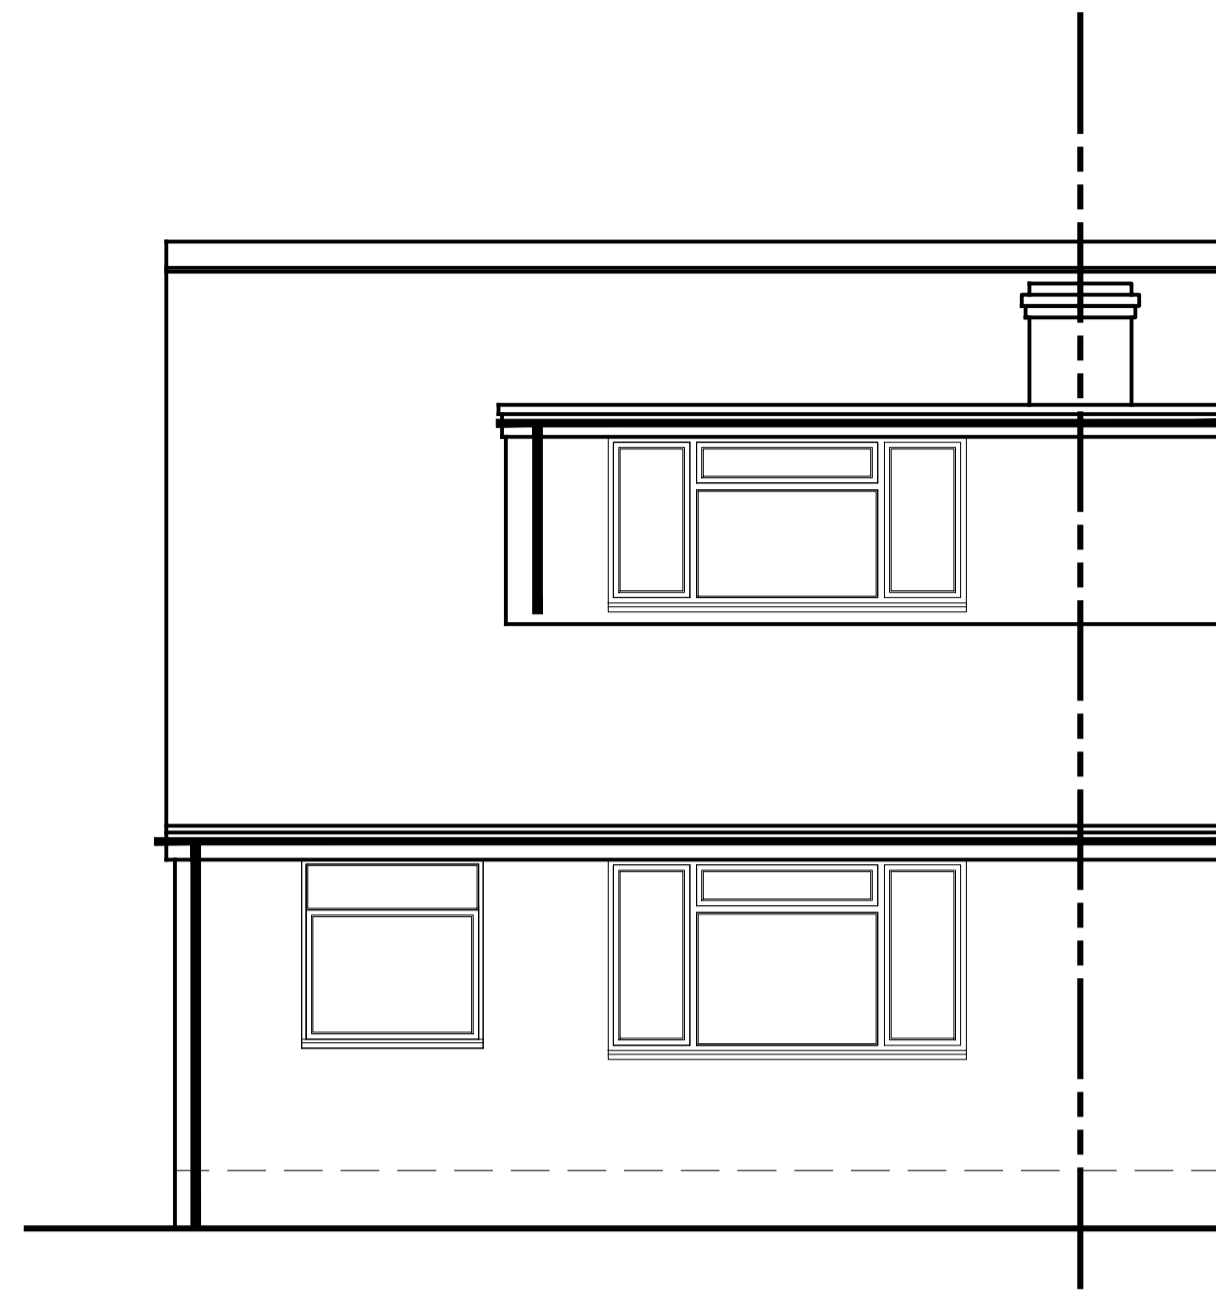


South Elevation Scale 1:50
0.0m 1.0m 2.0m 3.0m 4.0m 5.0m

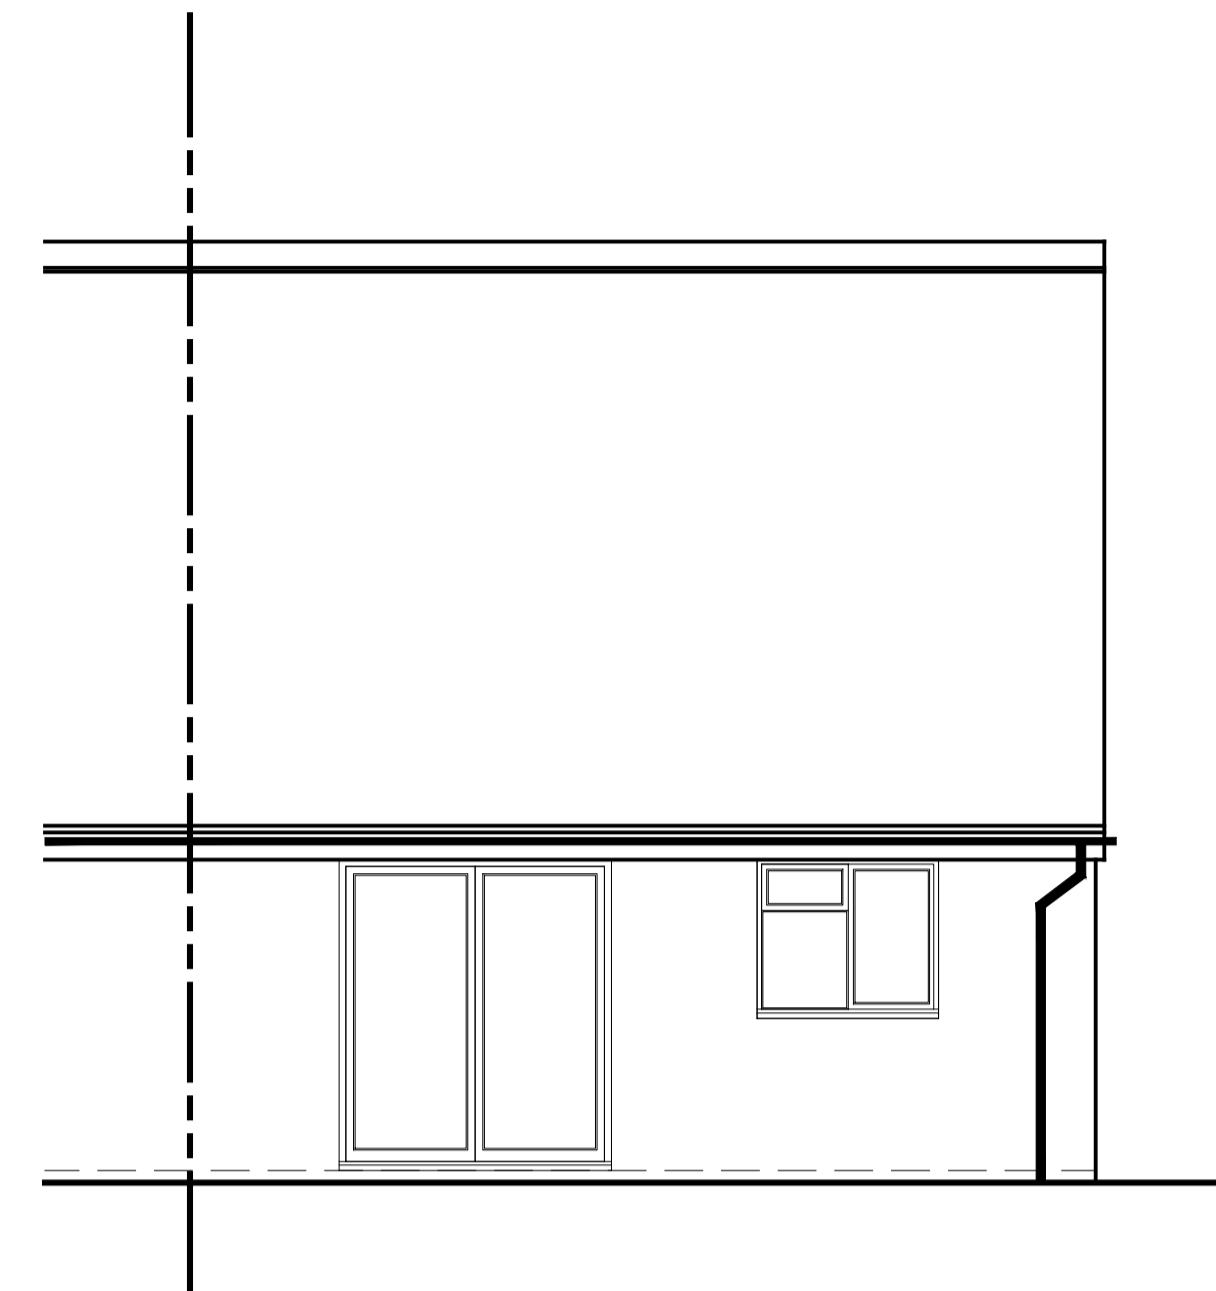


North Elevation Scale 1:50
0.0m 1.0m 2.0m 3.0m 4.0m 5.0m

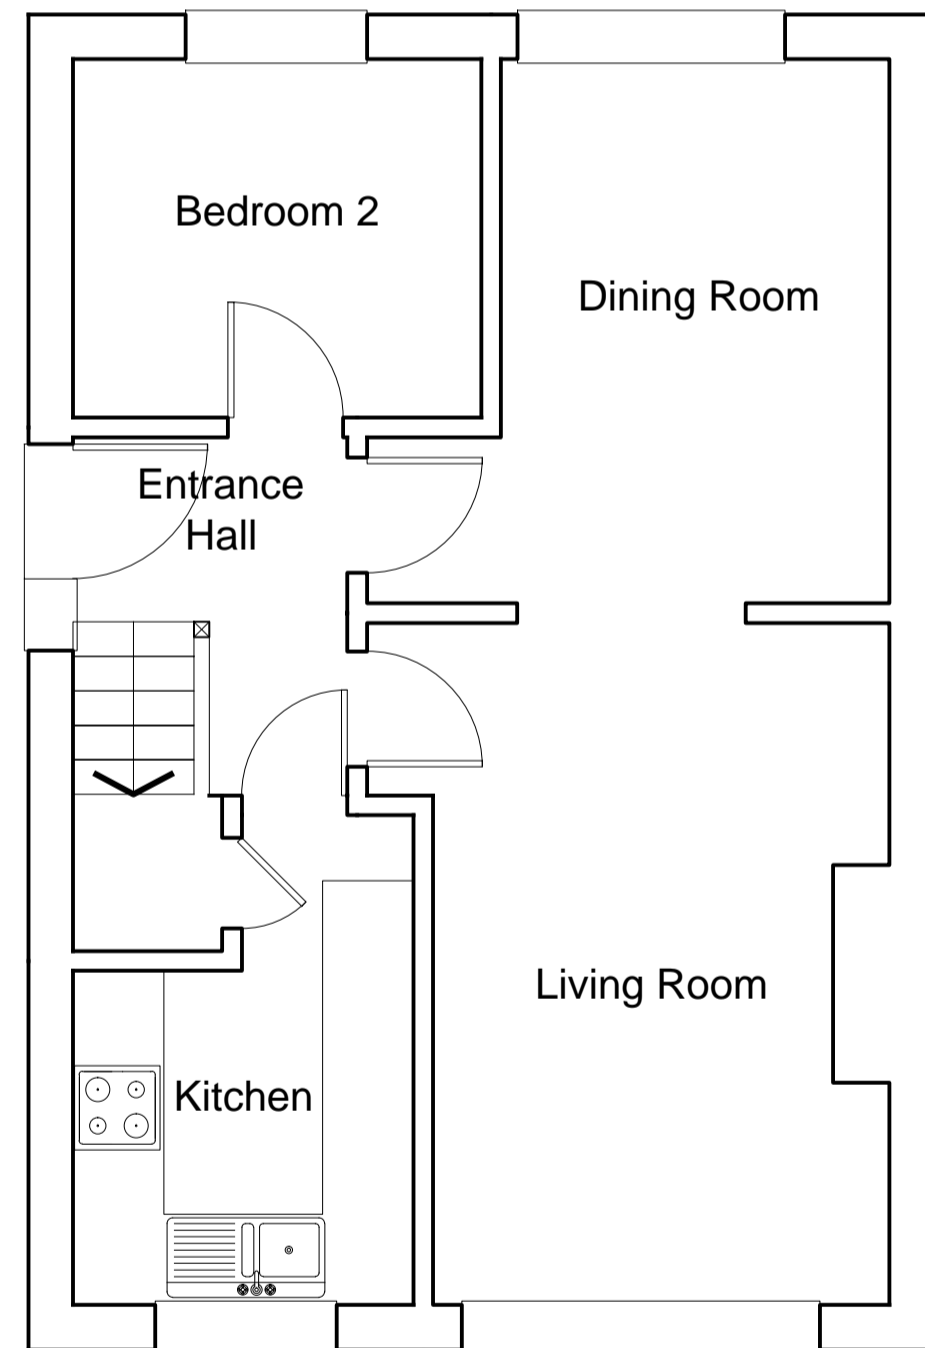


Ground Floor Plan Scale 1:50
0.0m 1.0m 2.0m 3.0m 4.0m 5.0m

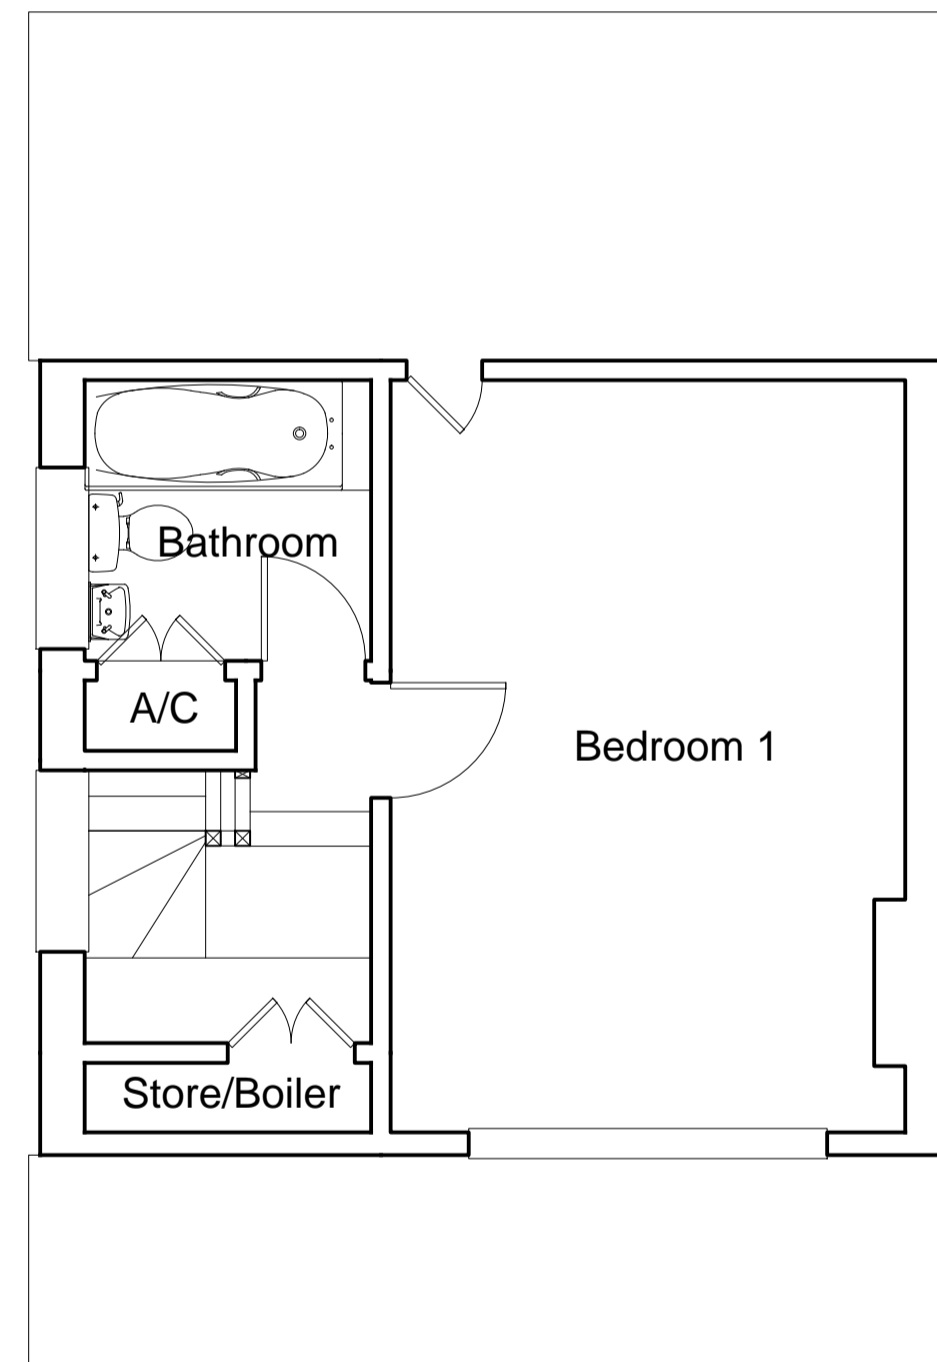

First Floor Plan Scale 1:50
0.0m 1.0m 2.0m 3.0m 4.0m 5.0m

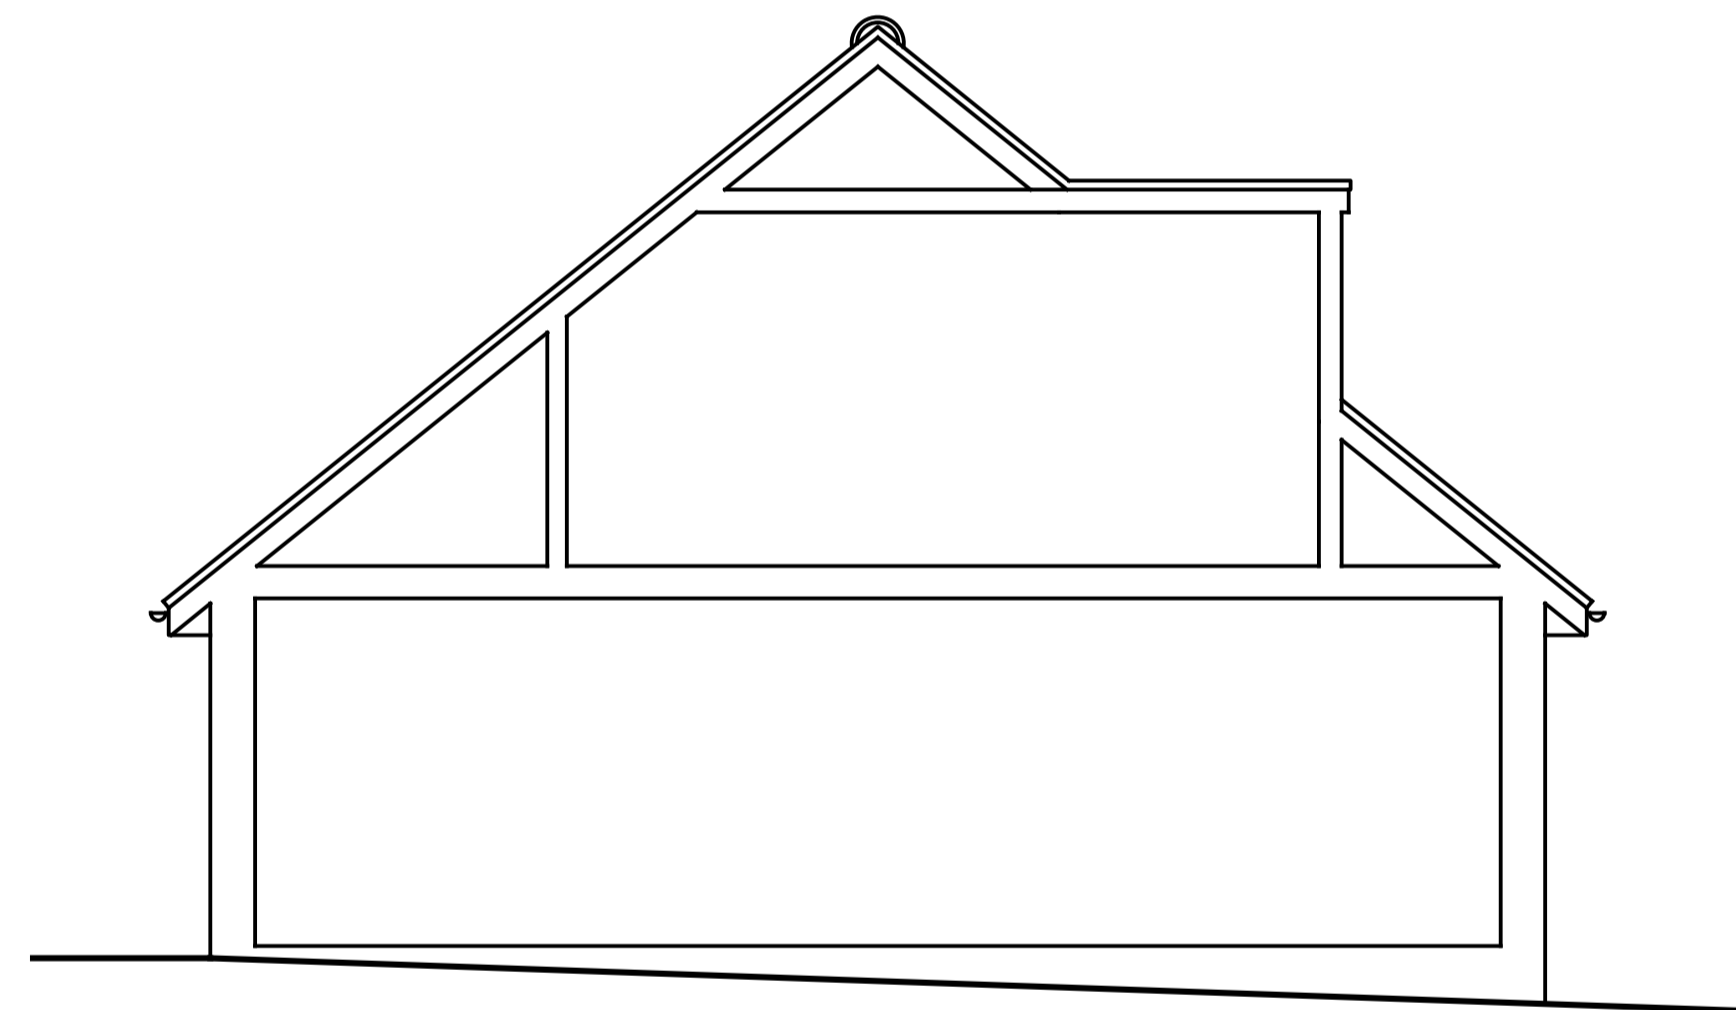

Cross Section Scale 1:50
0.0m 1.0m 2.0m 3.0m 4.0m 5.0m

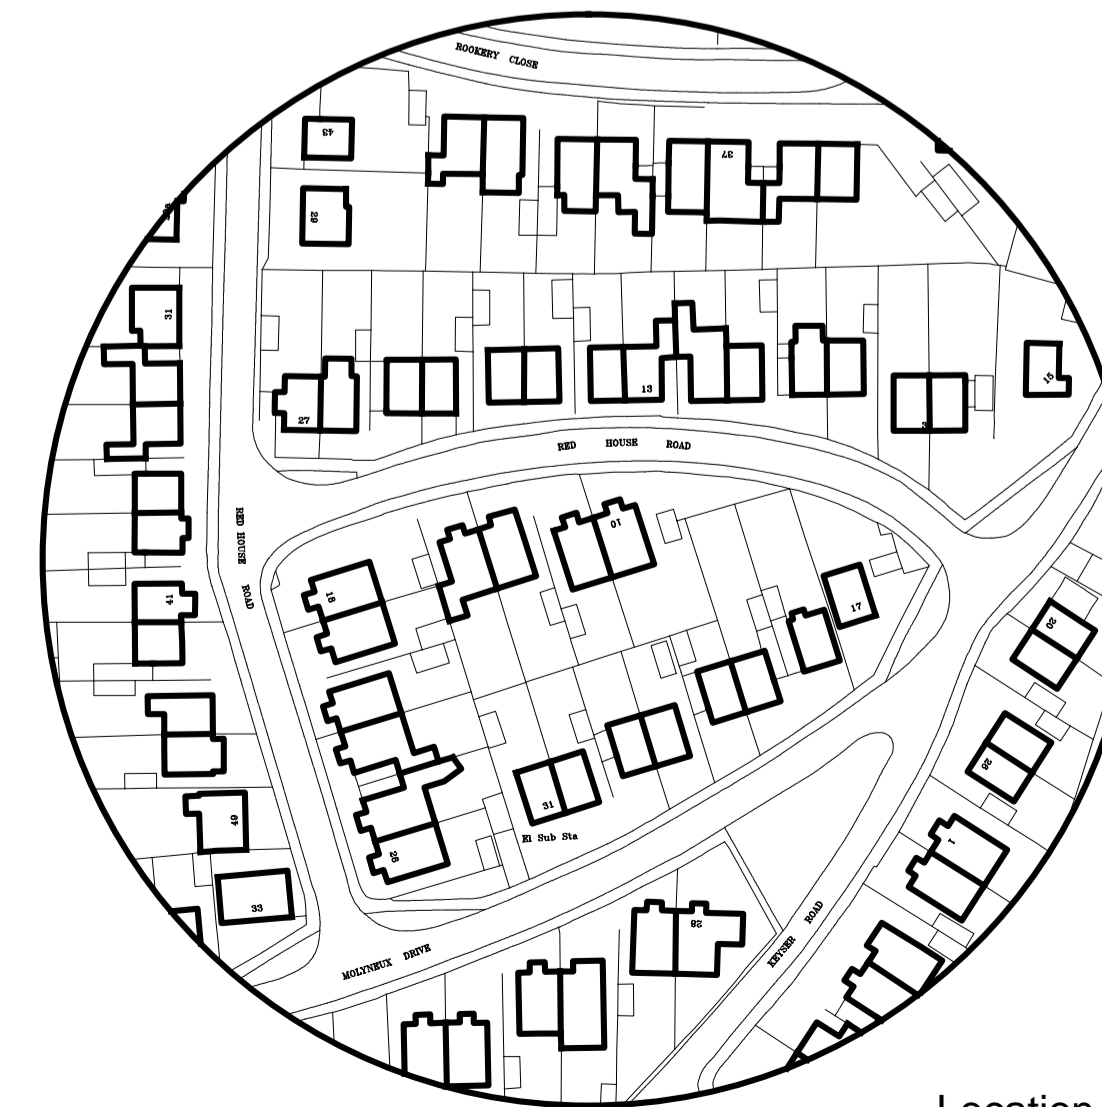

Location Plan Scale 1:1250
0.0m 10.0m 20.0m 30.0m 40.0m 50.0m

Revisions		
Client		
Ms N Bannister & Mr D Austin		
Project		
3 Red House Road Bodicote Banbury Oxon OX15 4BB		
Drawing		
Survey		
Plans, Elevations & Section		
Project Ref	Date	Drawing Number
DDC-2013-287	April 2013	001
Scale	Sheet Size	
AS SHOWN	A1	

DIGI·DESIGN·CO
Architecture Ltd
23 Hardwick Park,
Banbury, Oxon. OX16 1YE.
T: +44 (0)1295 259061 M: +44 (0)7748 402723
F: +44 (0)8717 336037
<http://www.digidesignco.com>