

 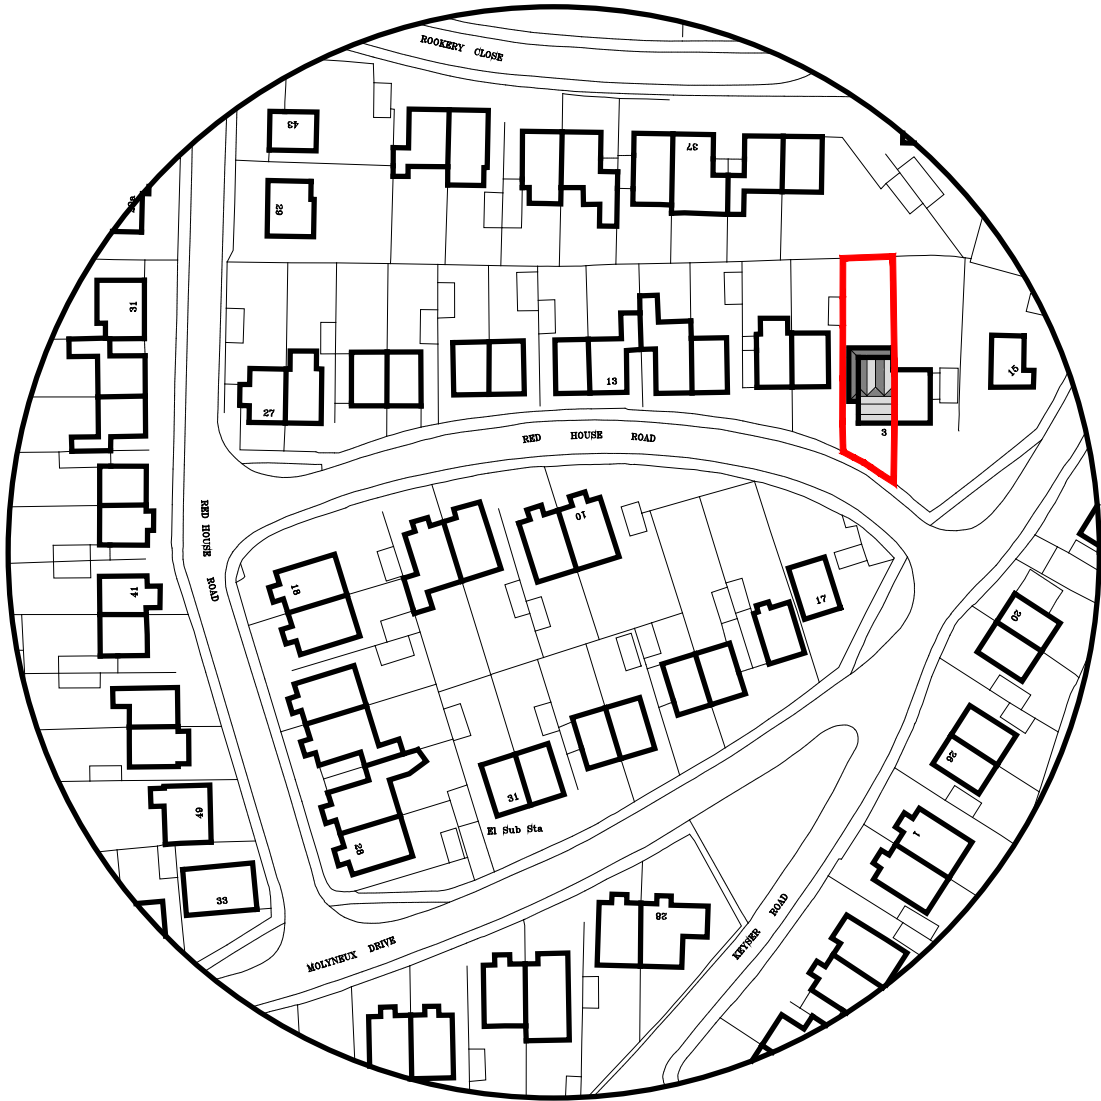


do not scale

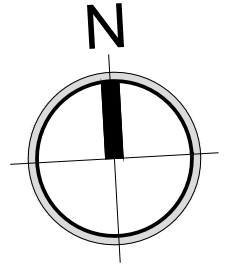

Scale 1:1250



23 Hardwick Park, Banbury, Oxon. OX16 1YE
T: +44 (0)1295 259061 M: +44 (0)7748 402723 F: +44 (0)8717 336037 <http://www.digidesignco.com>

Rev 'A' 12.06.15 Extension to rear amended

revisions



DIGI · DESIGN · CO
Architecture Ltd

drawing number
005A

AS SHOWN @ A4
scale
date
April 2013
job no
DDC-2013-287

3 Red House Road, Bodicote, Banbury, Oxon. OX15 4BB - Ms N Bannister & Mr D Austin.

project

drawing

Location Plan.