




do not scale

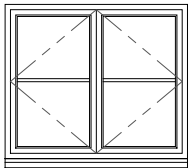


Master Bedroom
1020mmx1206mm
Scale 1:50

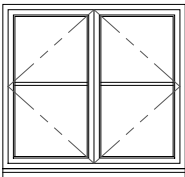


Bedroom 2
1082mmx1171mm
Scale 1:50

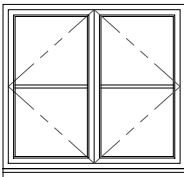

Bedroom 3
1086mmx1213mm
Scale 1:50

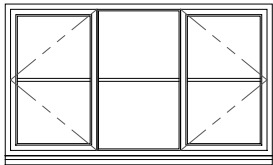


Dining Room
1026mmx1786mm
Scale 1:50

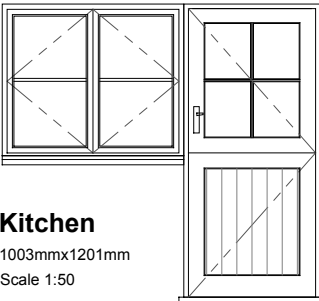


Kitchen
1003mmx1201mm
Scale 1:50


841mmx1908mm

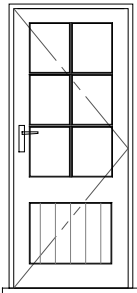

Porch
758mmx1848mm
Scale 1:50

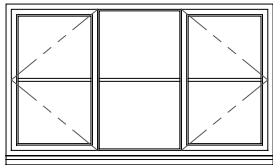


Living Room
1026mmx1786mm
Scale 1:50

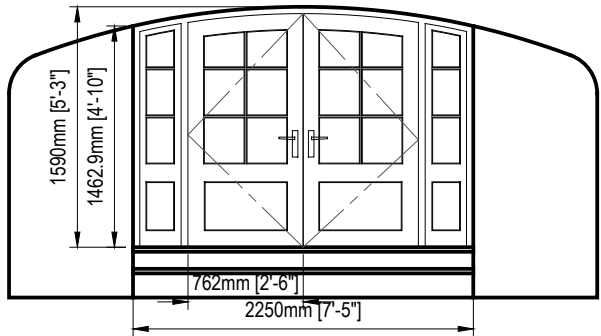

Basement
Scale 1:50

 All new windows & doors will be mahogany (painted in traditional colour) with 24mm double glazed units & traditional monkey tail ironmongery



DIGI·DESIGN·CO
Architecture Ltd

34 Farmfield Road, Banbury, Oxon. OX16 9AP.
T: +44 (0)1295 688182 M: +44 (0)7748 402723 <http://www.digidesignco.com>

005B

drawing number
AS SHOWN @ A4
date
May 2016
job no
DDC-2016-416

Stables Cottage, Main Street, Sibford Ferris, Oxon. OX15 5RE. Mr C Pennell.
Proposed Window and Door Schedule.

This drawing is the property of Digi Design Co Architecture Ltd. Copyright is reserved by them and the drawing is issued on the condition that it is not used, copied, reproduced, retained or disclosed either wholly or in part, by or to any unauthorised persons, without previous consent in writing of Digi Design Co Architecture Ltd.