



do not scale

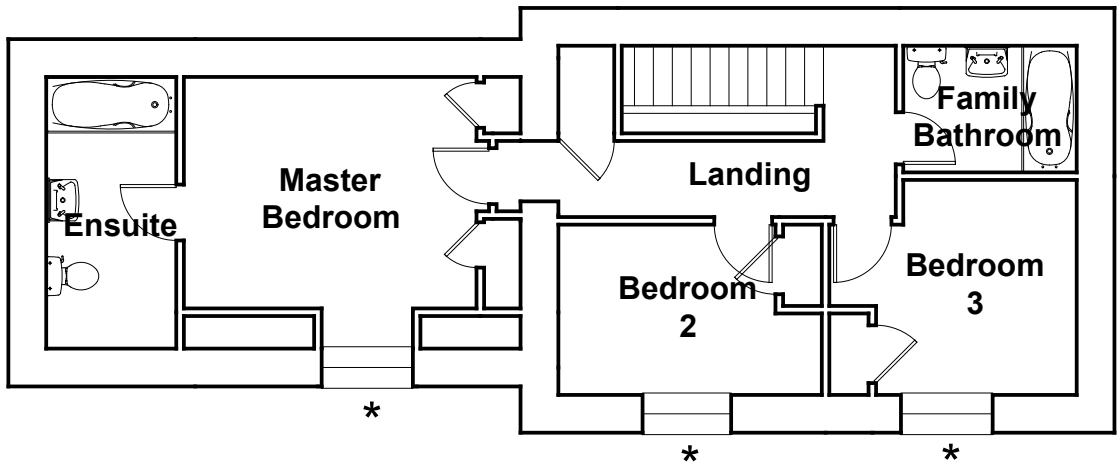

Proposed First Floor Plan Scale 1:100

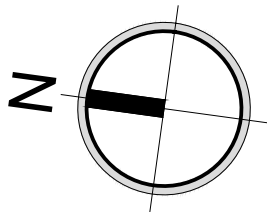

NOTE:

* Indicates windows to be replaced



DIGI·DESIGN·CO
Architecture Ltd

34 Farmfield Road, Banbury, Oxon. OX16 9AP.
T: +44 (0)1295 688182 M: +44 (0)7748 402723 <http://www.digidesignco.com>

003A

drawing number
AS SHOWN @ A4
date
May 2016
job no
DDC-2016-416

Stables Cottage, Main Street, Sibford Ferris, Oxon. OX15 5RE. Mr C Pennell.

Proposed First Floor Plan.