


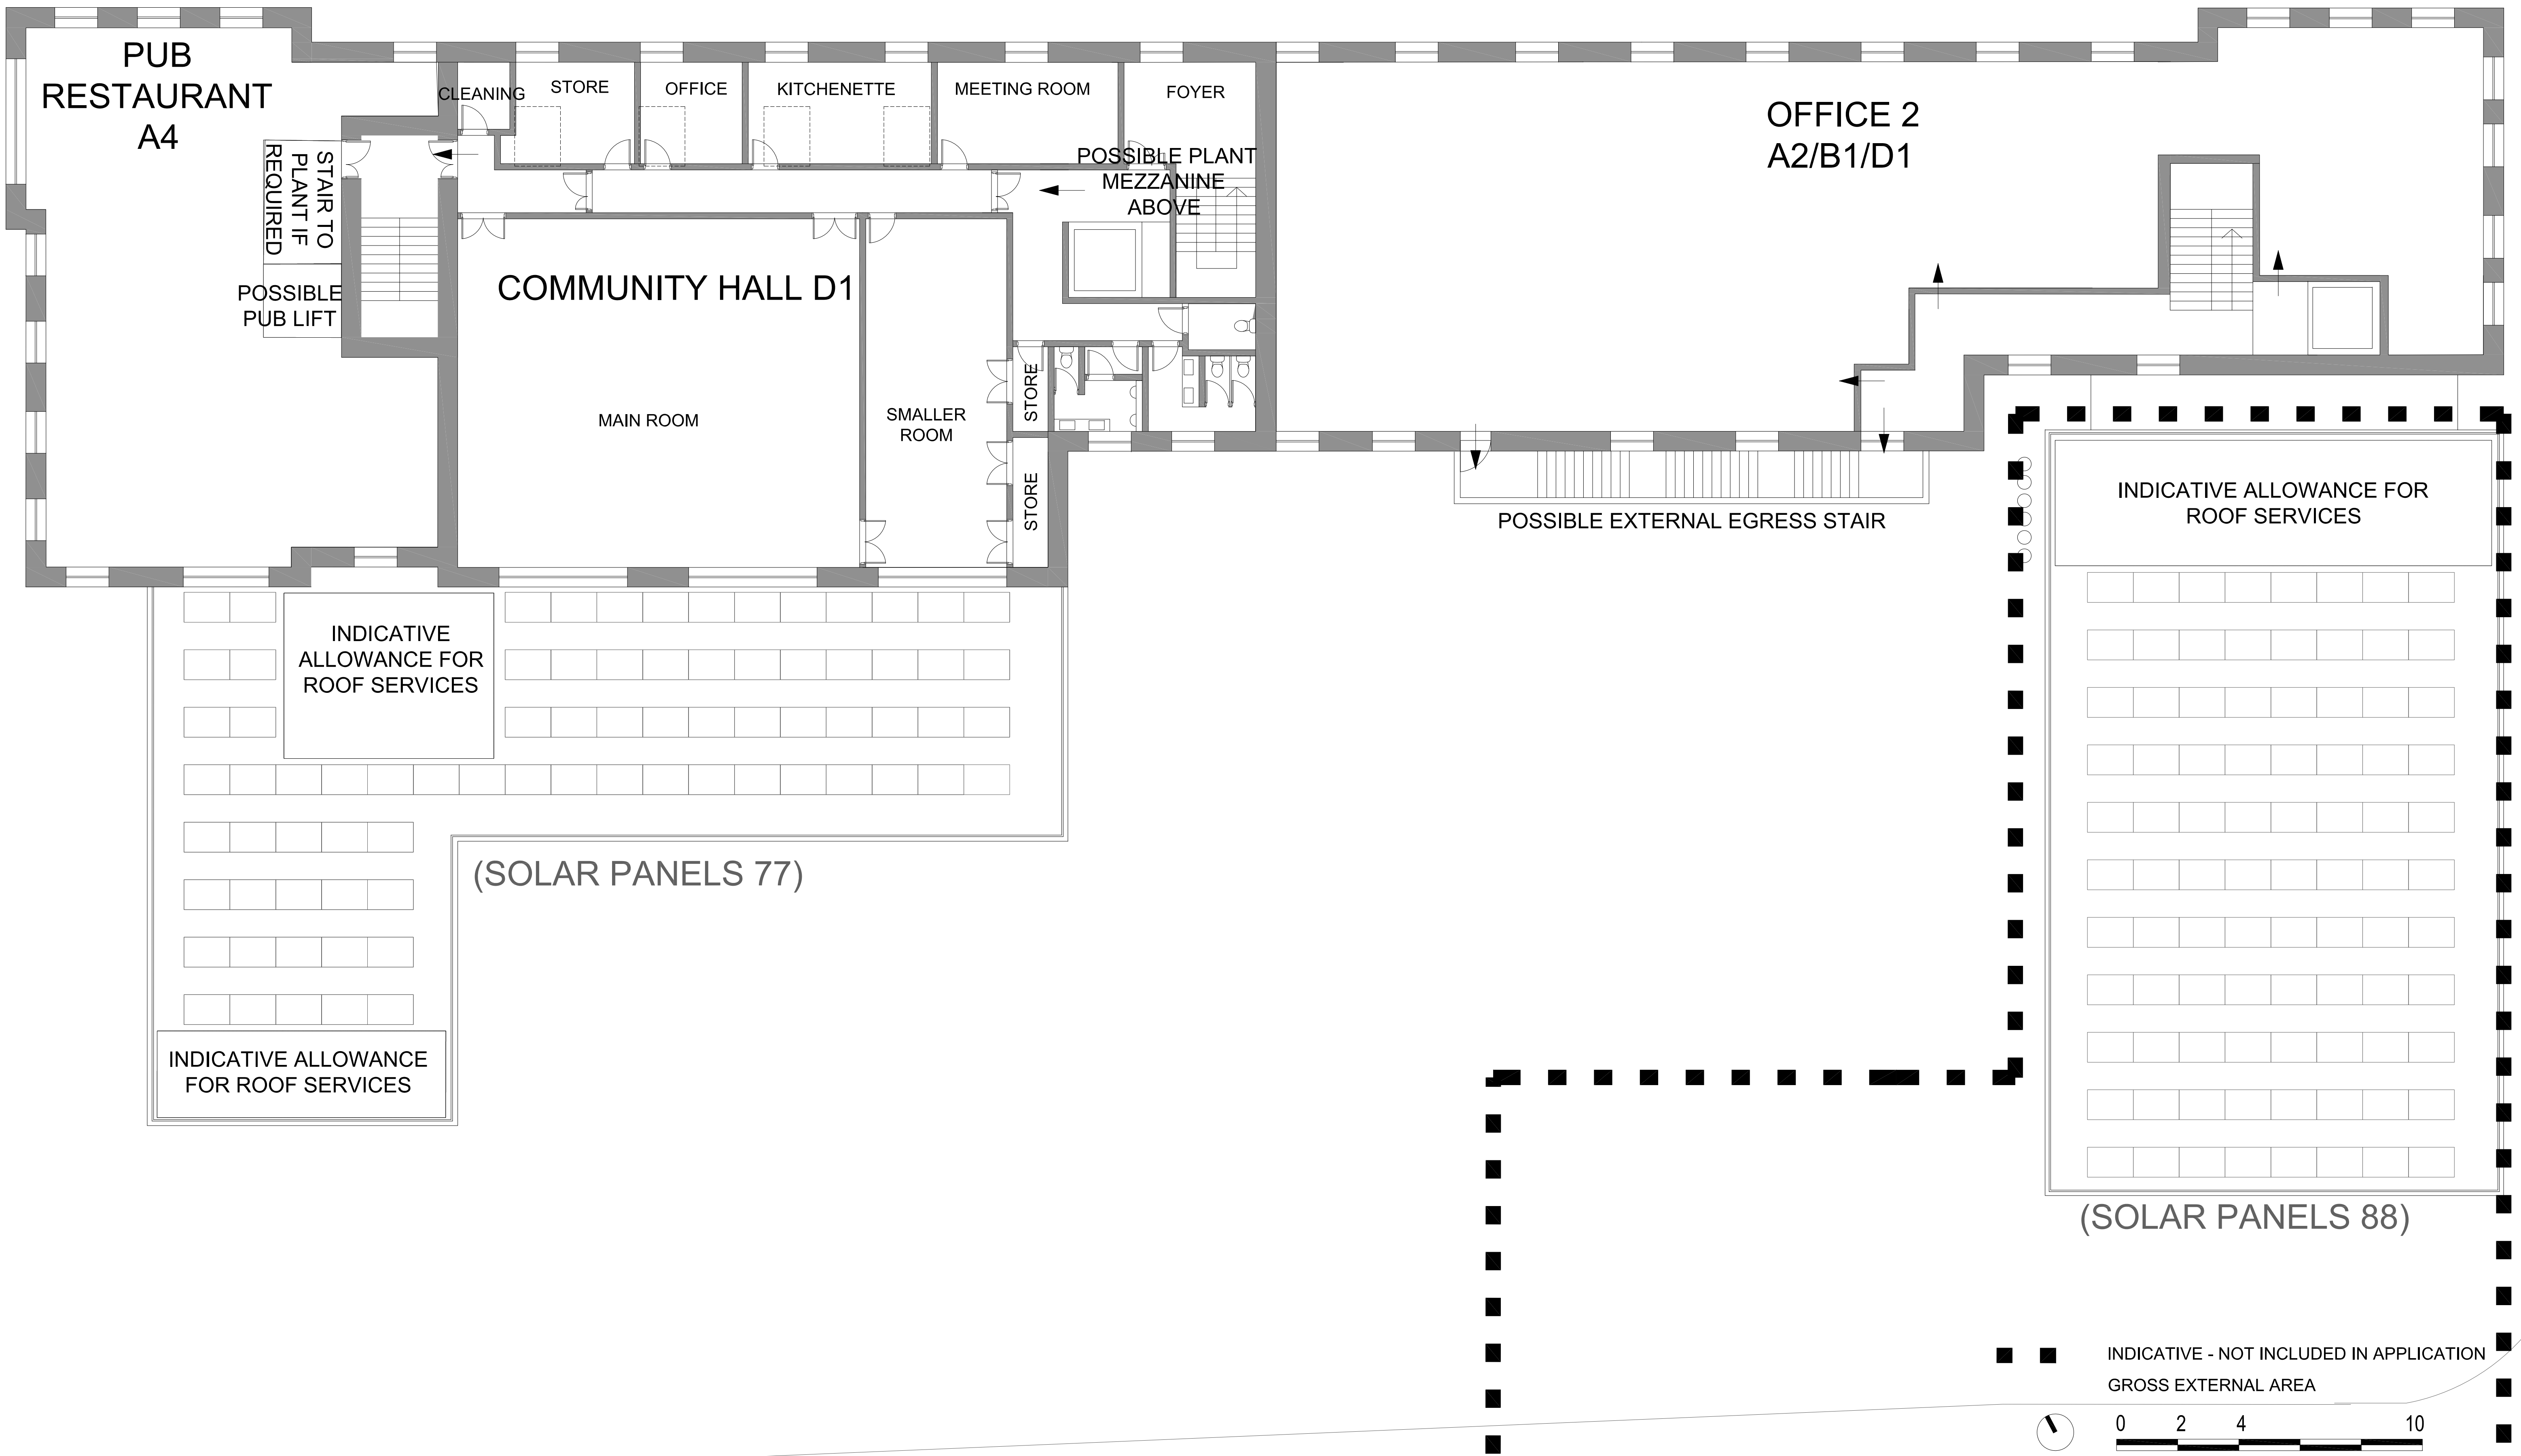

CLIENT	REVISIONS	DATE	STATUS	SCALE	PROJECT	DRAWING NAME	DRAWING NUMBER
	Rev A: 24 04 15	24 04 2015	PLANNING	1:100 @ A1 1:200 @ A3	NW BICESTER EXEMPLAR LOCAL CENTRE	SOUTH ARCADE - FIRST FLOOR PLAN	14058 (P) 114 RevA

HIGGS YOUNG

ARCHITECTS

HIGGS YOUNG ARCHITECTS LTD
54 BOSTON PLACE
LONDON NW1 6ER
Tel: 0044 (0)20 7724 9395
E-mail: info@higgscopy.com