

- KEY
- PROPOSED STORM DRAINAGE
 - PROPOSED RAIN WATER PIPE
 - PROPOSED ROAD GULLY
 - PROPOSED RODDING EYE
 - PROPOSED DRAINAGE CHANNEL
 - PROPOSED CELLULAR STORAGE/SOAKAWAY
 - PROPOSED LEVELS
 - PROPOSED DRAINAGE AREAS

Rev	Date	Description	By	Checked By
-----	------	-------------	----	------------


Project	Dwg Number	Rev.
OXFORD TECHNOLOGY PARK	12076/102	-

Scale @ A1 - 1:500	Date	FEB 2015
--------------------	------	----------

Title	PROPOSED DRAINAGE AREAS PLAN
-------	------------------------------

Drawn by	NMB	Checked by	NSB	Project Engineer	NSB
----------	-----	------------	-----	------------------	-----

Baynham Meikle Partnership
consulting structural + civil engineers
8 Meadow Road, Edgbaston, Birmingham B17 8BU
Telephone: 0121 434 4100 Fax: 0121 434 4073 Email: admin@bm-p.co.uk

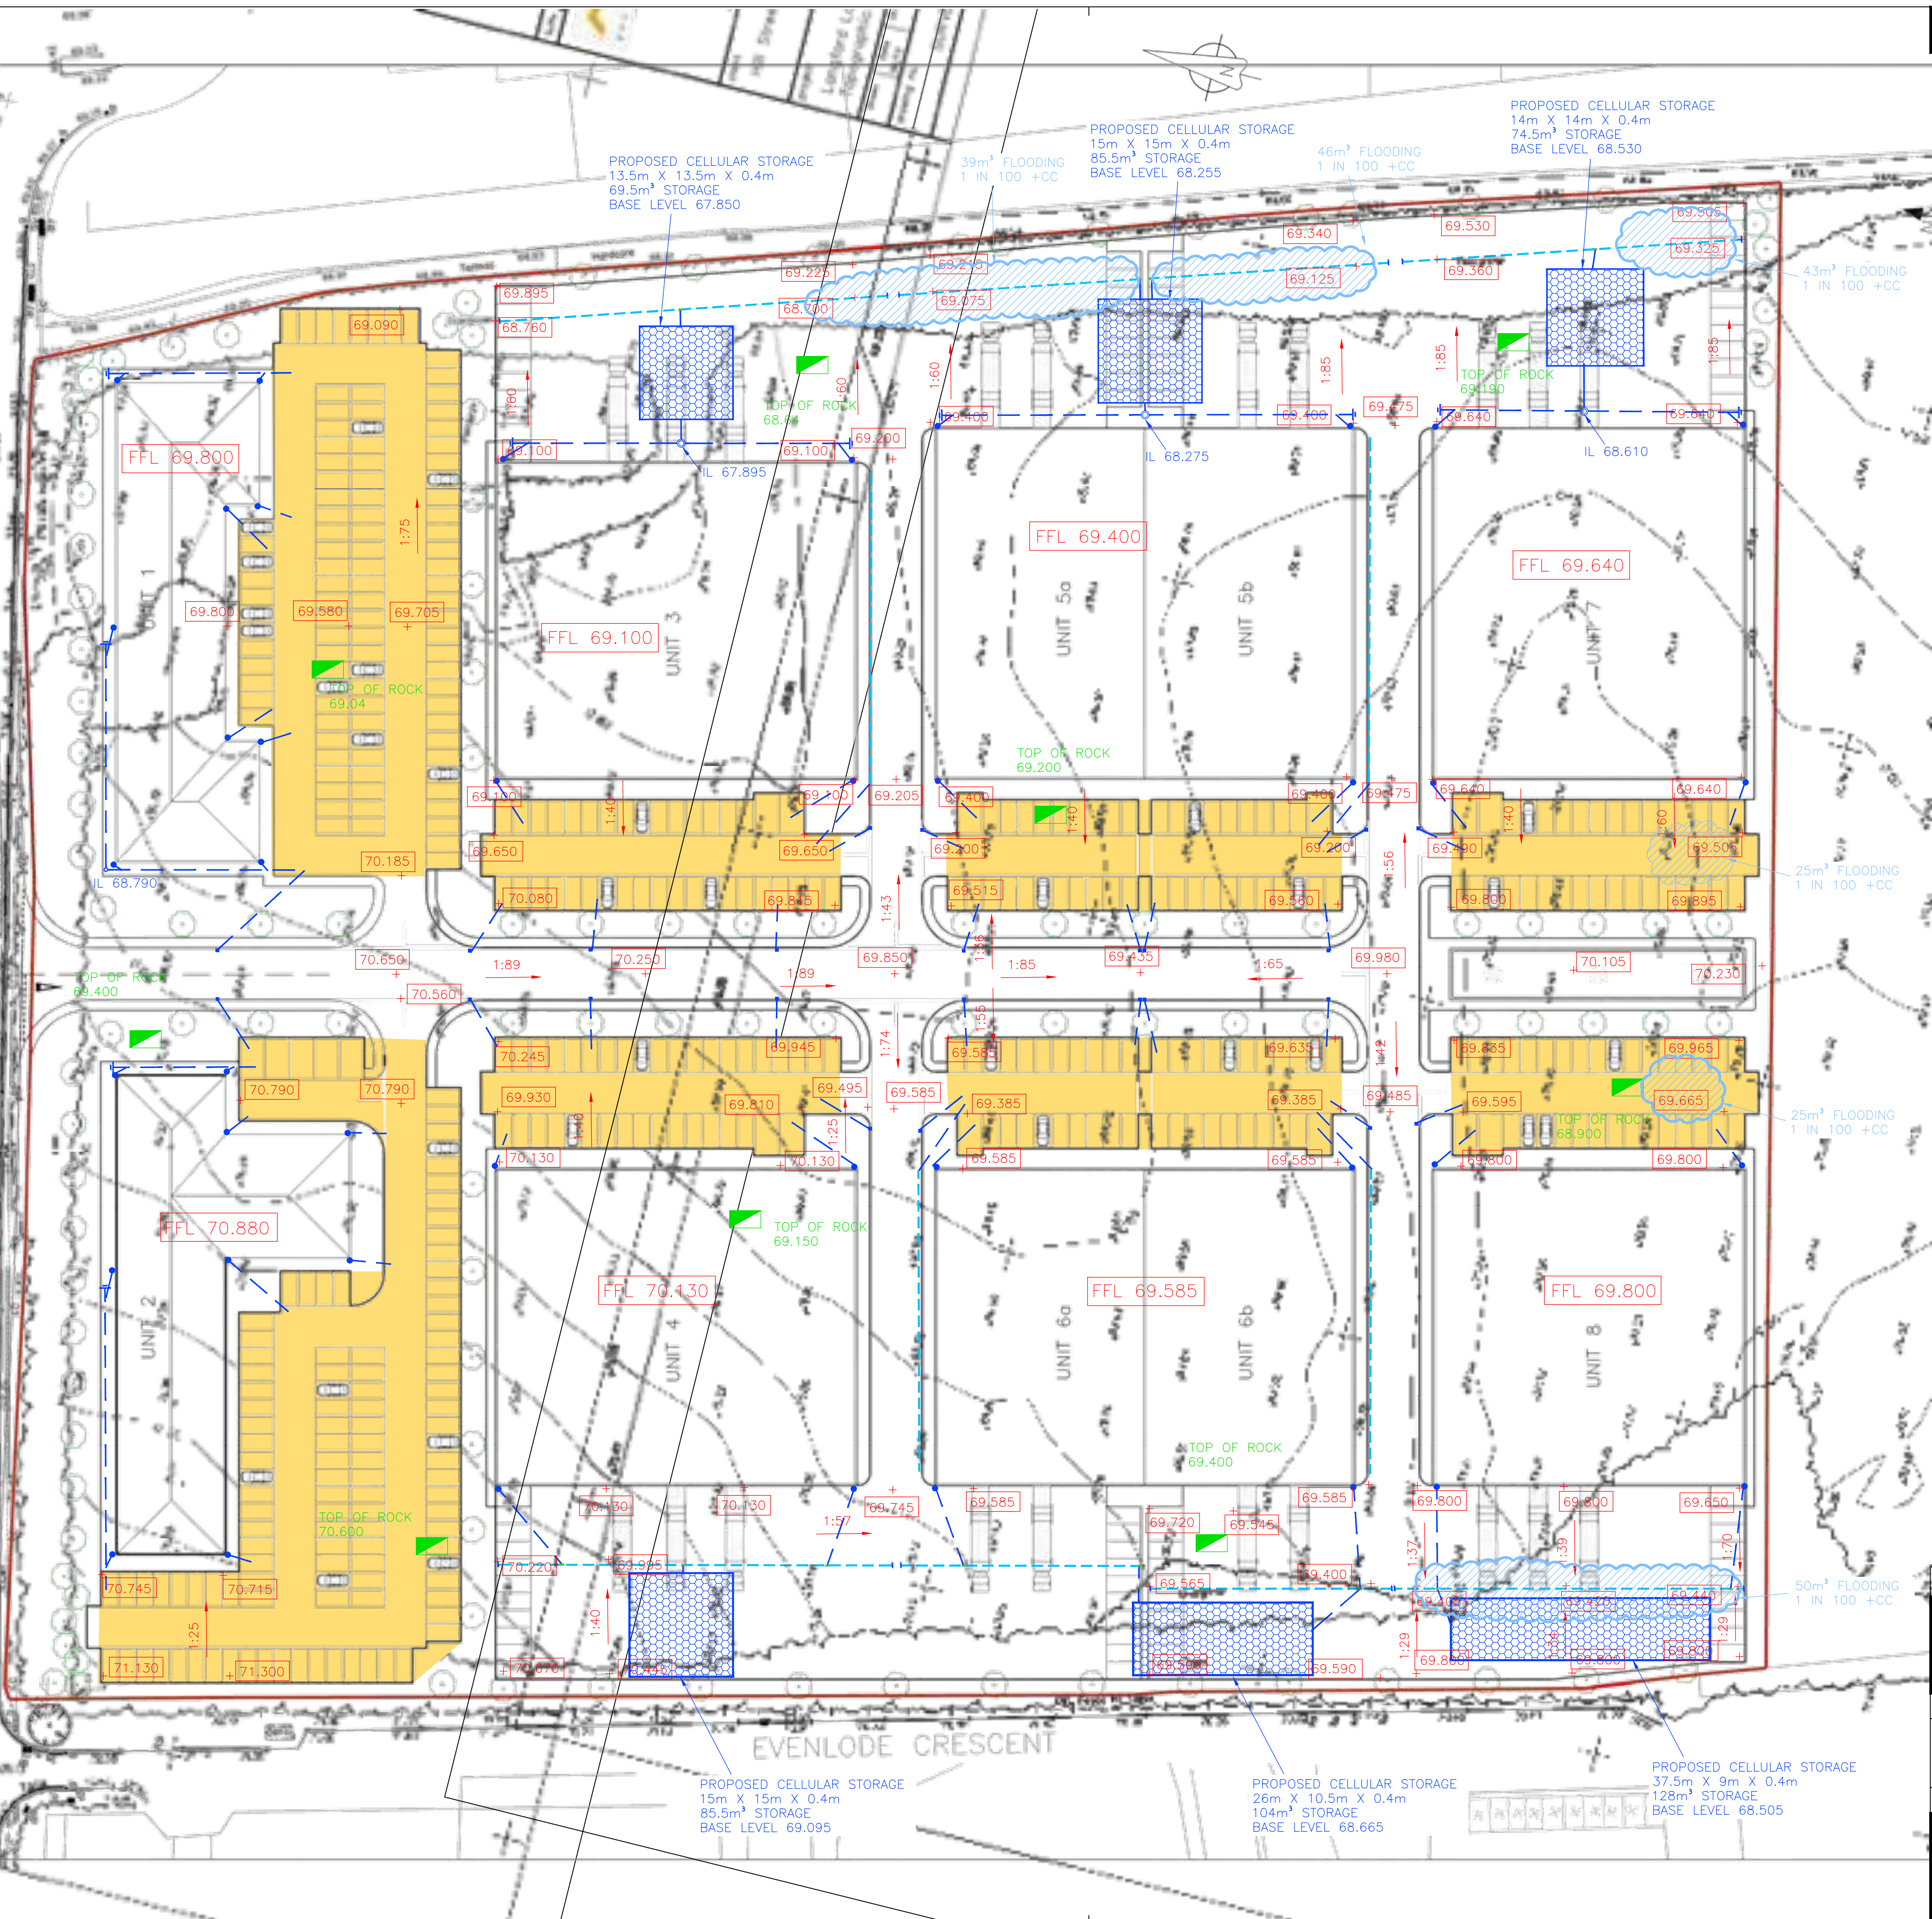

- KEY
- PROPOSED STORM DRAINAGE
 - PROPOSED RAIN WATER PIPE
 - PROPOSED ROAD GULLY
 - PROPOSED RODDING EYE
 - PROPOSED DRAINAGE CHANNEL
 - PROPOSED CELLULAR STORAGE/SOAKAWAY
 - PROPOSED LEVELS
 - PROPOSED PERMEABLE CAR PARK (CONSTRUCTION THICKNESS 650mm)
 - EXISTING TOP OF ROCK LEVEL & LOCATION
 - LOCATION OF PROPOSED FLOOD AREA

Rev	Date	Description	By	Checked By
Project				
OXFORD TECHNOLOGY PARK			Dwg Number	Rev.
			12076/103	-
Scale @ A1 - 1:500				
			Date	FEB 2015
Title				
PROPOSED FLOOD ROUTING PLAN				
Drawn by NMB Checked by NSB Project Engineer NSB				
Baynham Meikle Partnership consulting structural + civil engineers				
8 Meadow Road, Edgbaston, Birmingham B17 8BU				
Telephone: 0121 434 4100 Fax: 0121 434 4073 Email: admin@bm-p.co.uk				

SEE EXTRACT A SEE EXTRACT A

NOTES

- KEY
- PROPOSED FOUL DRAINAGE
 - PROPOSED FOUL RISING MAIN
 - PROPOSED EXISTING FOUL DRAINAGE
 - PROPOSED LEVELS
 - EXISTING TOP OF ROCK LEVEL & LOCATION

EXTRACT A
SCALE 1:500

EXTRACT A SEE EXTRACT A

Rev	Date	Description	By	Checked By
-----	------	-------------	----	------------

Project	Dwg Number	Rev.
OXFORD TECHNOLOGY PARK	12076/104	-

Scale @ A1 - 1:500	Date	FEB 2015
--------------------	------	----------

Title
PROPOSED FOUL DRAINAGE PLAN

Drawn by	NMB	Checked by	NSB	Project Engineer	NSB
----------	-----	------------	-----	------------------	-----

Baynham Meikle Partnership
consulting structural + civil engineers
8 Meadow Road, Edgbaston, Birmingham B17 8BU
Telephone: 0121 434 4100 Fax: 0121 434 4073 Email: admin@bm-p.co.uk

