

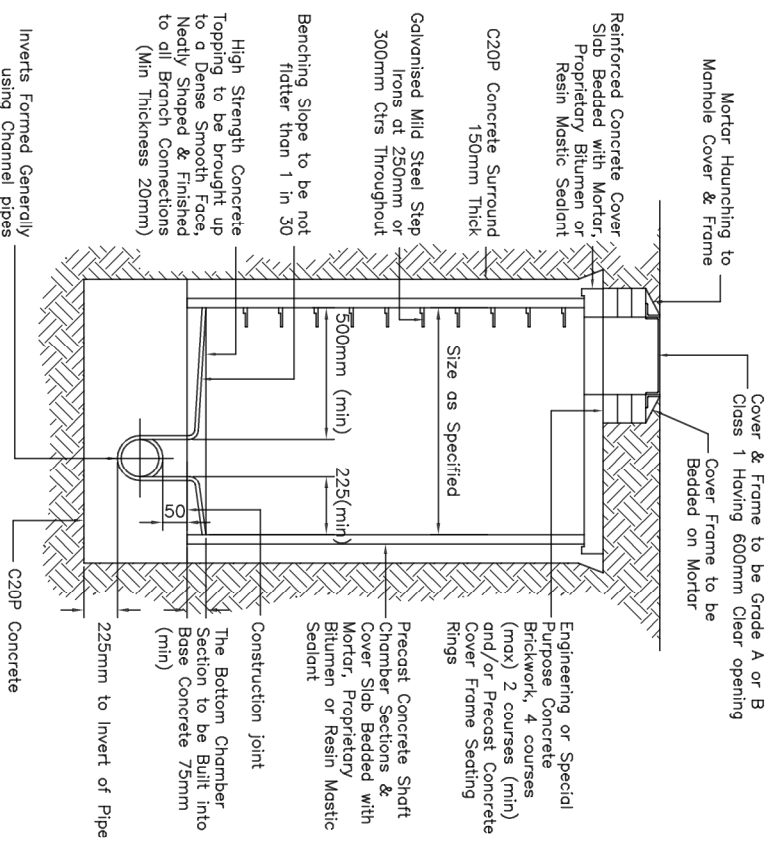


PIPE BEDDING 1:20

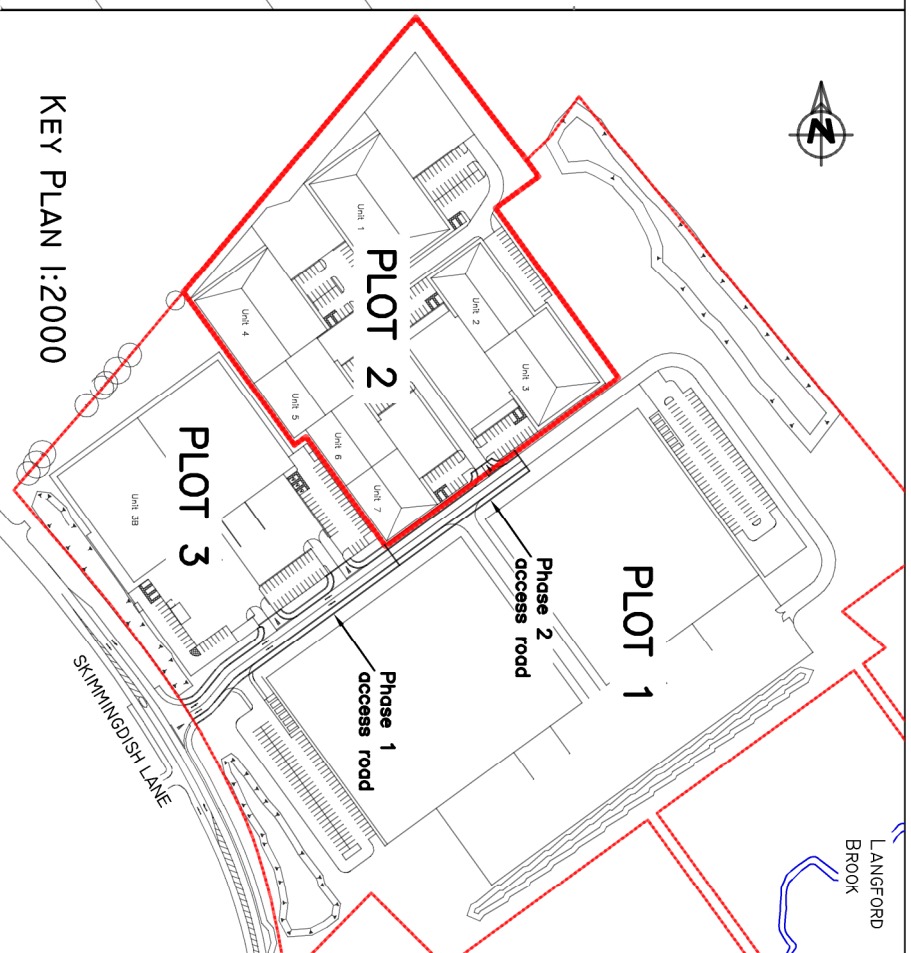

TYPICAL MANHOLE 1:20

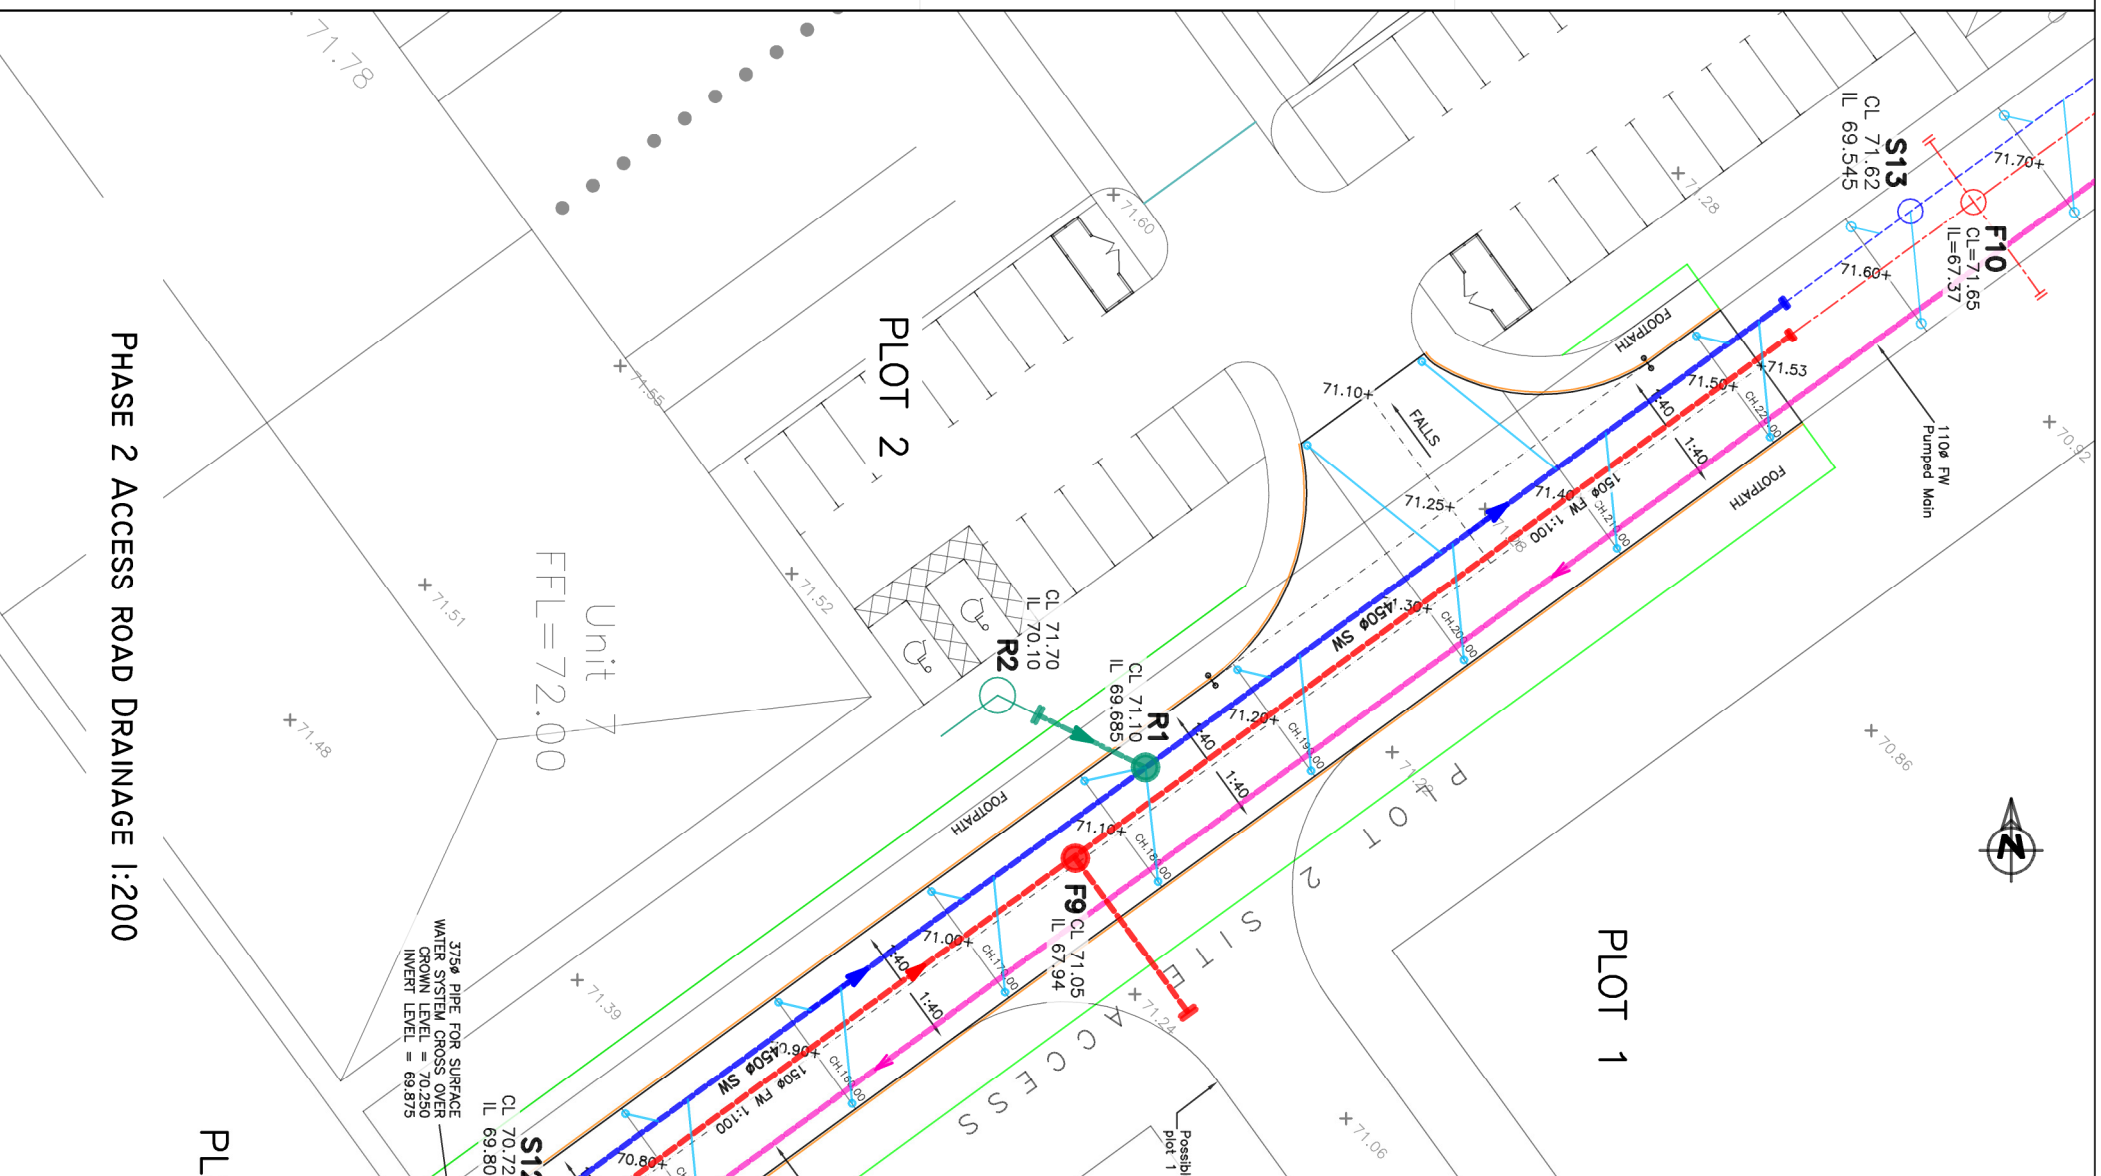

PHASE 2 ACCESS ROAD DRAINAGE 1:200

CONSTRUCTION

PLOT 2
Skimmingdish Lane,
Link 9 – Bicester

CLIENT:
ALBION LAND (2013) LTD

PLOT 2
Site Road – Drainage

BAILEY JOHNSON HAYES
Consulting Engineers

STABRAGE: Site 4, Phoenix House, 63 Campbell Rd, ST ALBANS, Herts AL1 5PL
MANCHESTER: Gange House, John Dalton Street, MANCHESTER, M2 6JW

Scale: AS SHOWN
Date: 03.06.17
Drawn: DJC
S1345-E-08A

A	28.11.17	Drainage layout updated
---	----------	-------------------------