


do not scale

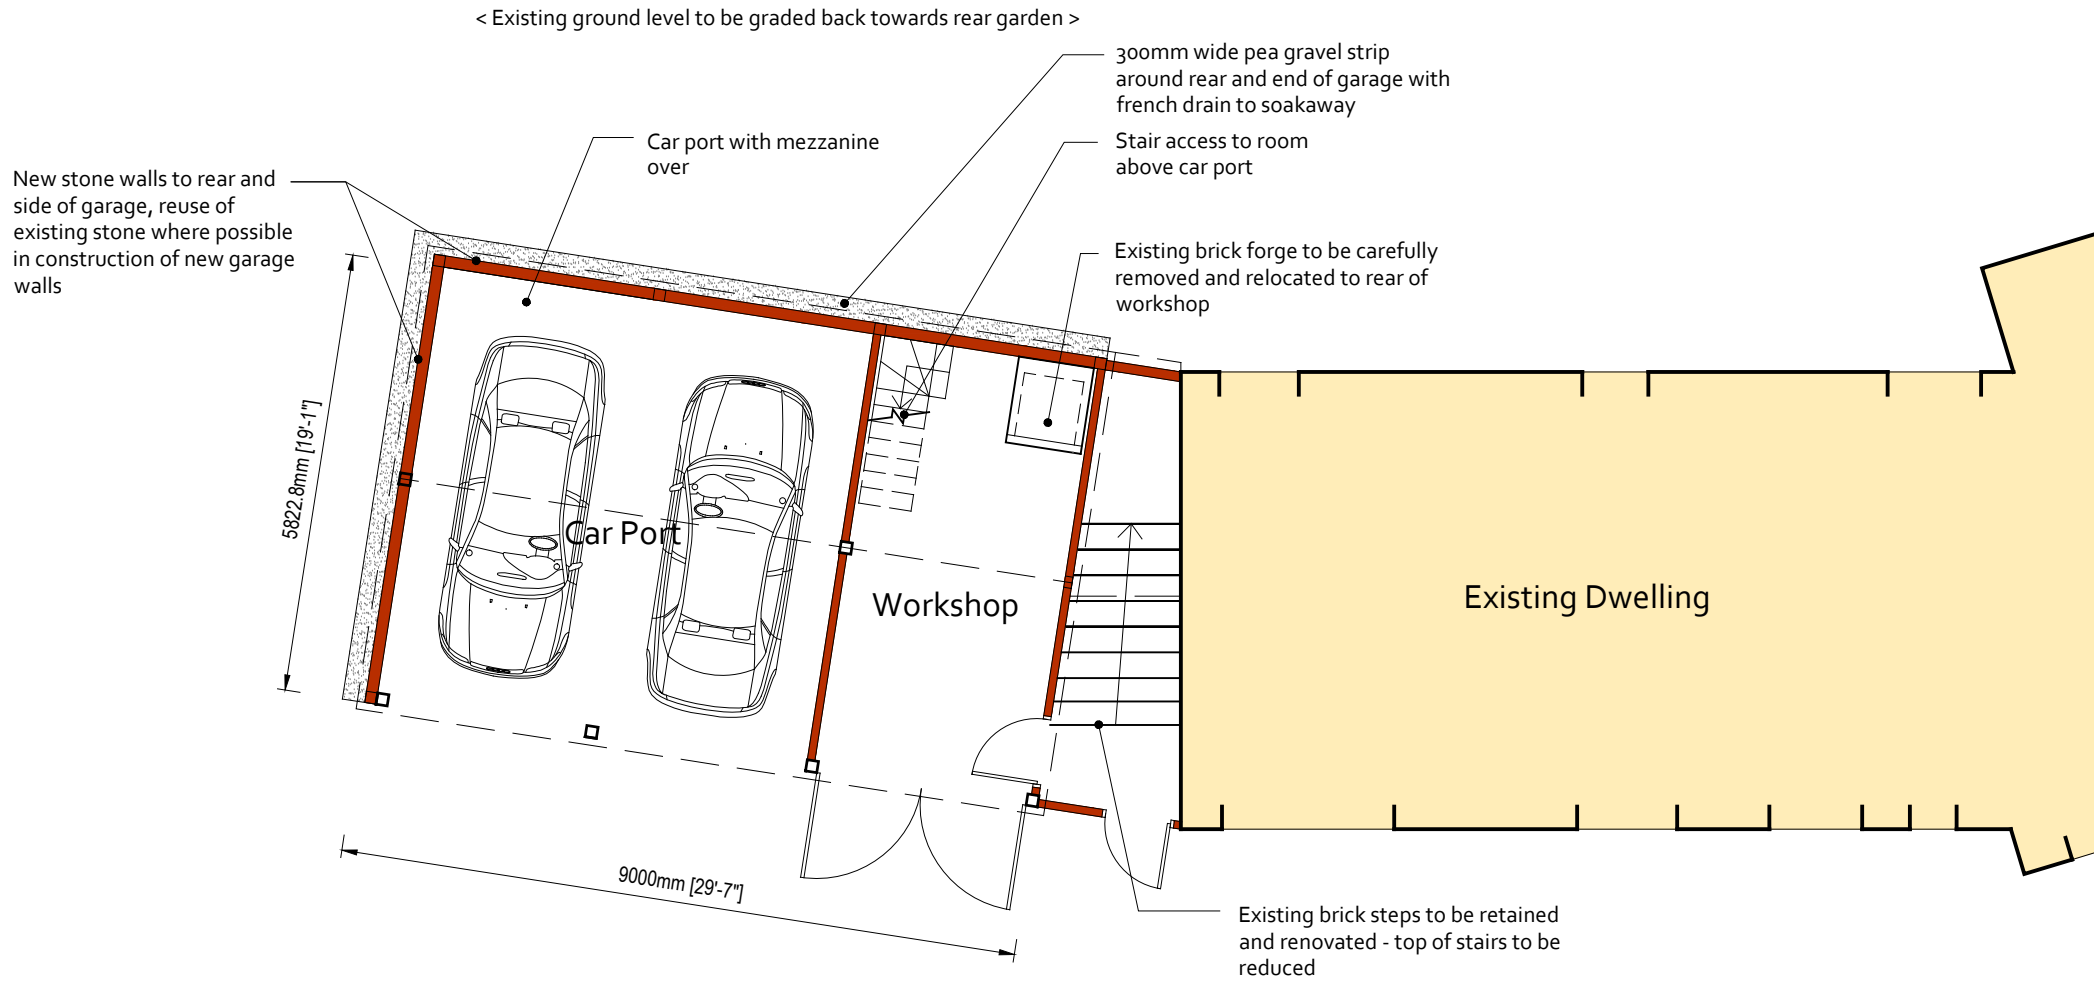


Proposed Plan scale 1:100



- Rev F 05.07.18 Planning
- Rev E 14.05.18 Garage doors added to plan
- Rev D: 01.05.18 Pea gravel strip & French drain added
- Rev C: 26.04.18 Cutout to roof removed
- Rev 'B' 24.04.18 Car Port lowered

Rev A 05.02.18 Outbuilding design altered

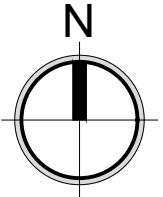

**DIGI-DESIGN-CO**  
Architecture Ltd

Cherwell Business Village F161, Southam Road, Banbury, Oxon. OX16 2SP.  
T: +44 (0)1295 688182 M: +44 (0)7748 402723 <http://www.digidesignco.com>

drawing number  
**002F**

scale  
AS SHOWN @ A4  
date  
January 2018  
job no  
DDC-2018-498

project  
Temple Mill, Sibford Ferris, Banbury, Oxon. OX15 5DA. Mr W Sabin.

drawing  
Proposed Plan.