
 


do not scale

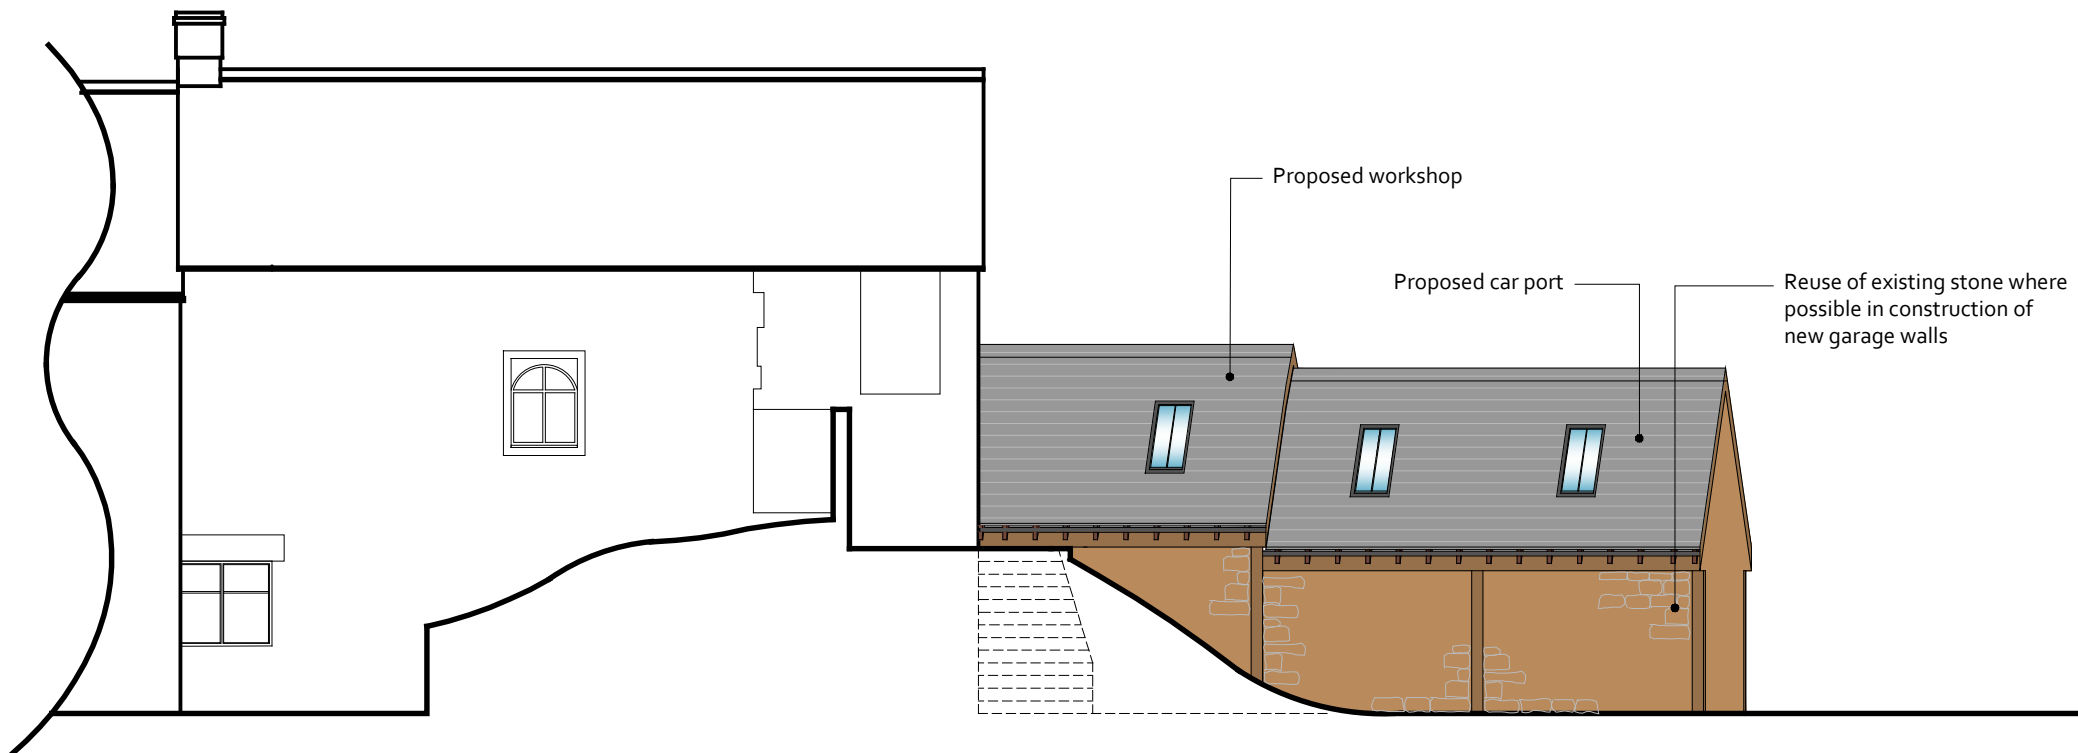

Proposed North Elevation Scale 1:100



**Materials:**

- Walls: Locally sourced stone and oak timber cladding
- Roof: Slate to match existing
- Windows: White timber casements to match existing
- Doors: Oak
- Rainwater goods: Black iron rainwater goods to match existing

Rev C: 26.04.18 Cutout to roof removed  
 Rev 'B' 24.04.18 Car Port lowered  
 Rev A 05.02.18 Outbuilding design altered

revisions



**DIGI-DESIGN-CO**  
 Architecture Ltd

Cherwell Business Village F161, Southam Road, Banbury, Oxon. OX16 2SP.  
 T: +44 (0)1295 688182 M: +44 (0)7748 402723 <http://www.digidesignco.com>

drawing number  
**004C**

scale  
 AS SHOWN @ A4  
 date  
 January 2018  
 job no  
 DDC-2018-498

Temple Mill, Sibford Ferris, Banbury, Oxon. OX15 5DA. Mr W Sabin.

project

drawing

Proposed Elevations (1).