



DRAWING LEGEND

Per Plot
 Installed Power: 5.46 kWp
 21 Modules 260Wp each
 Modules @40 Degrees

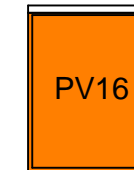


PV Modules 260Wp
 1640x992mm
 21kg

Plot 229 (Opposite Hand)
 Plot 233 (Opposite Hand)

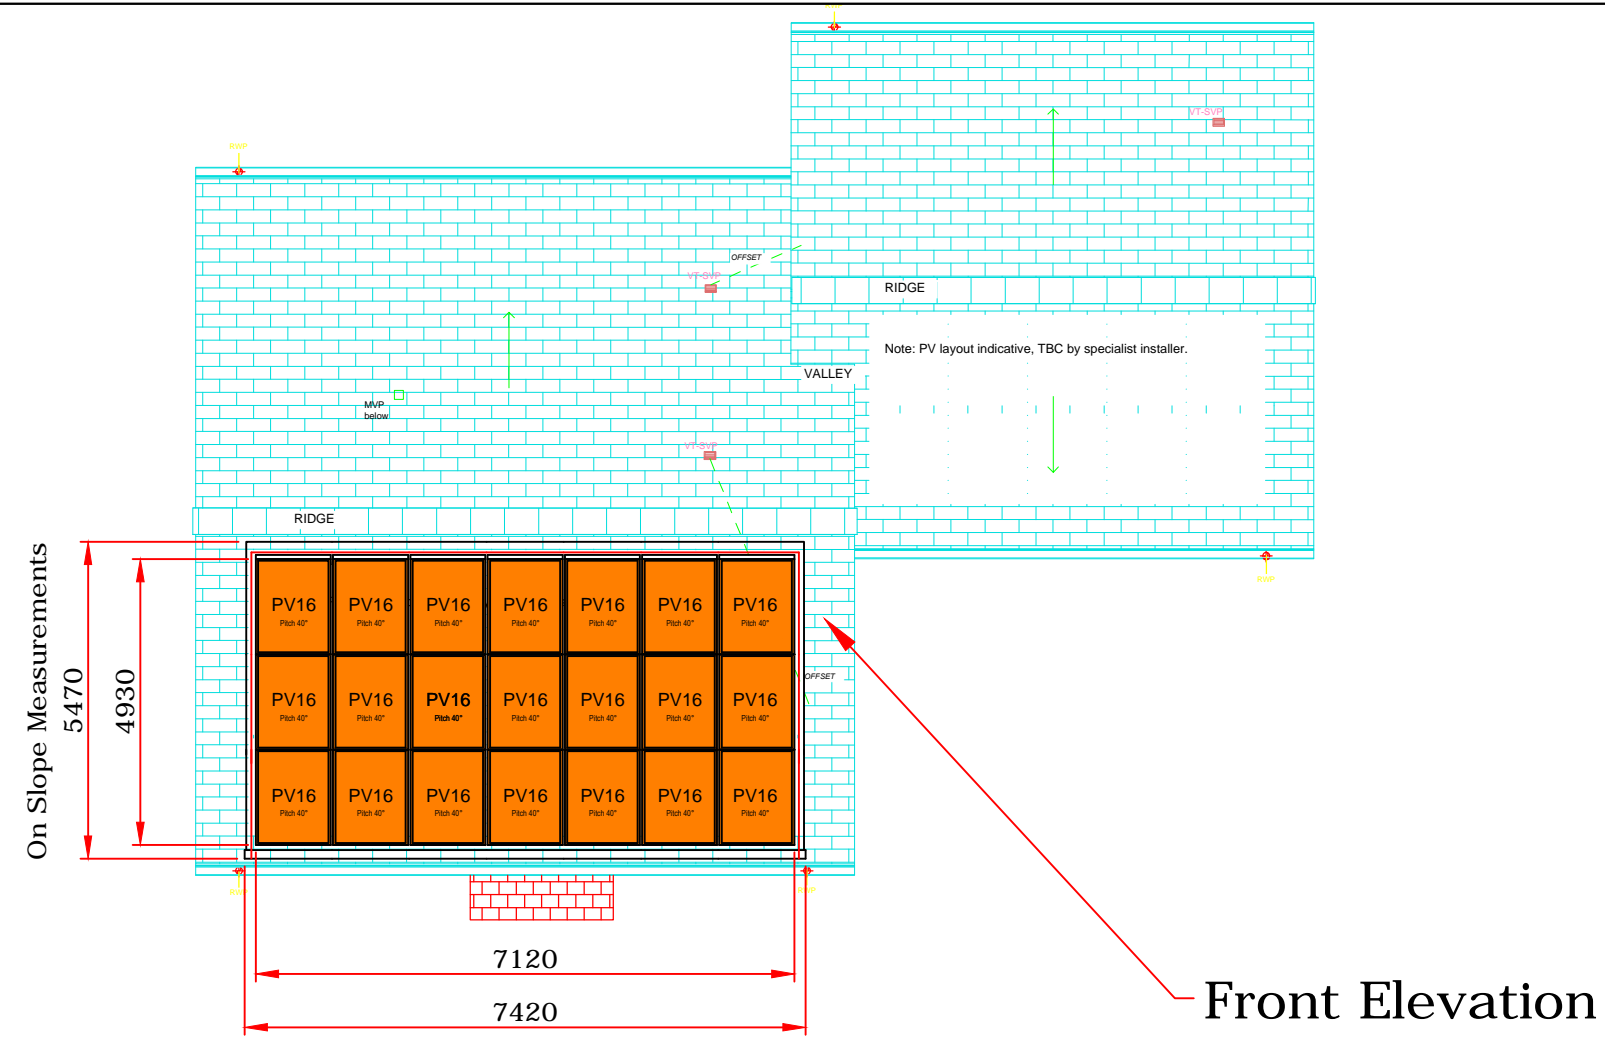

Front Elevation

Plot 230 (As Shown)
 Plot 234 (As Shown)
 Plot 235 (As Shown)

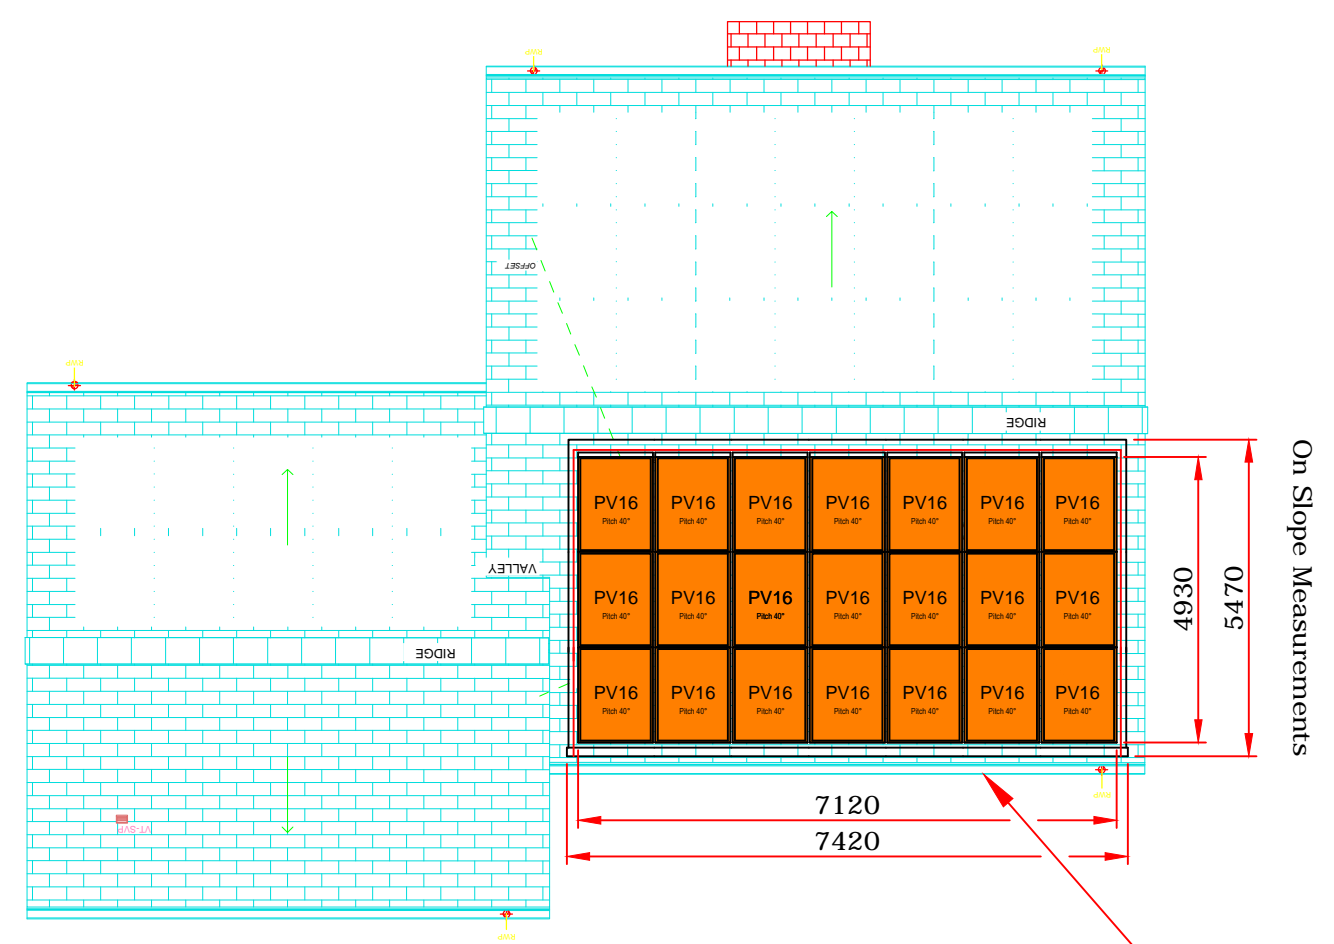

Rear Elevation

Rev	Description	Dwn	Chk	Date



PHOTON ENERGY

© Photon Energy Ltd
 8 Windsor Square
 Silver Street
 Reading, RG1 2TH
 Tel +44 118 997 7470
 info@photonenergy.co.uk
 www.photonenergy.co.uk
 All rights reserved

Project Number: I1546	
Project Name: NW Bicester Phase 2	
Drawing By: Rikki Baker	Scale: 1:100 @ A3
Checked By: Nikolaos Kallitsis	Date: 09/02/2017
Drawing Name: PV Roof Layout - Plan View Plots 229-230 & 233-235	
Drawing No: I1546-109-01	Rev: -