



DRAWING LEGEND

Per Plot  
 Installed Power: 4.16 kWp  
 16 Modules 260Wp each  
 Modules @40 Degrees

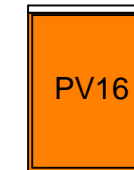

PV Modules 260Wp  
 1640x992mm  
 21kg

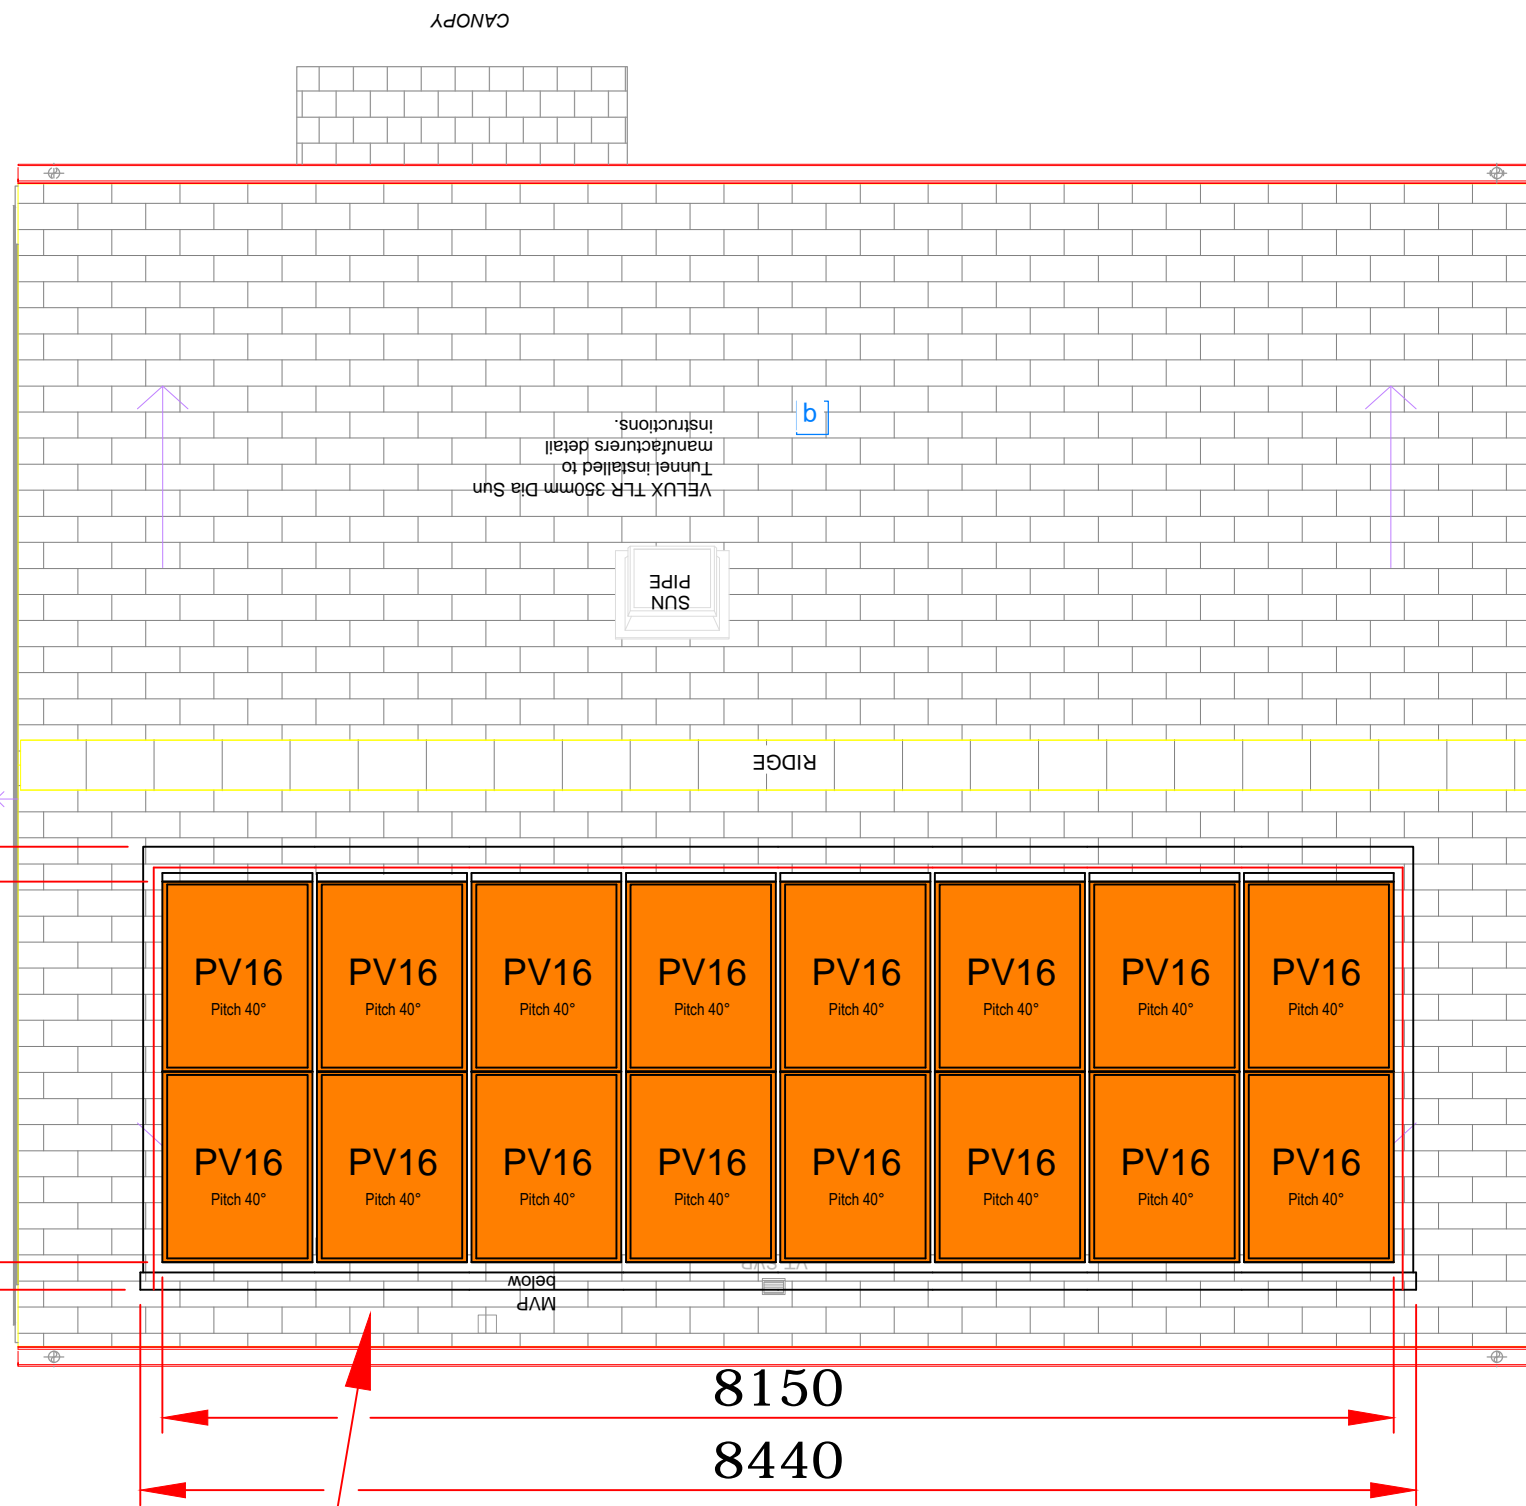

On Slope Measurements

3825  
 3285

8150  
 8440

Plot 300

Rear Elevation

Rev	Description	Dwn	Chck	Date



**PHOTON  
 ENERGY**

© Photon Energy Ltd  
 8 Windsor Square  
 Silver Street  
 Reading, RG1 2TH  
 Tel +44 118 997 7470  
 info@photonenergy.co.uk  
 www.photonenergy.co.uk  
 All rights reserved

Project Number: <b>I1546</b>	
Project Name: <b>NW Bicester Phase 2</b>	
Drawing By: <b>Rikki Baker</b>	Scale: <b>1:50 @ A3</b>
Checked By: <b>Nikolaos Kallitsis</b>	Date: <b>09/02/2017</b>
Drawing Name: <b>PV Roof Layout - Plan View Plot 300</b>	
Drawing No: <b>I1546-107-01</b>	Rev: <b>-</b>