
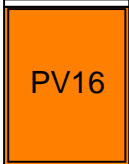


DRAWING LEGEND

Per Plot
 Installed Power: 5.46 kWp
 21 Modules 260Wp each
 Modules @40 Degrees

 **PV16** PV Modules 260Wp
 1640x992mm
 21kg

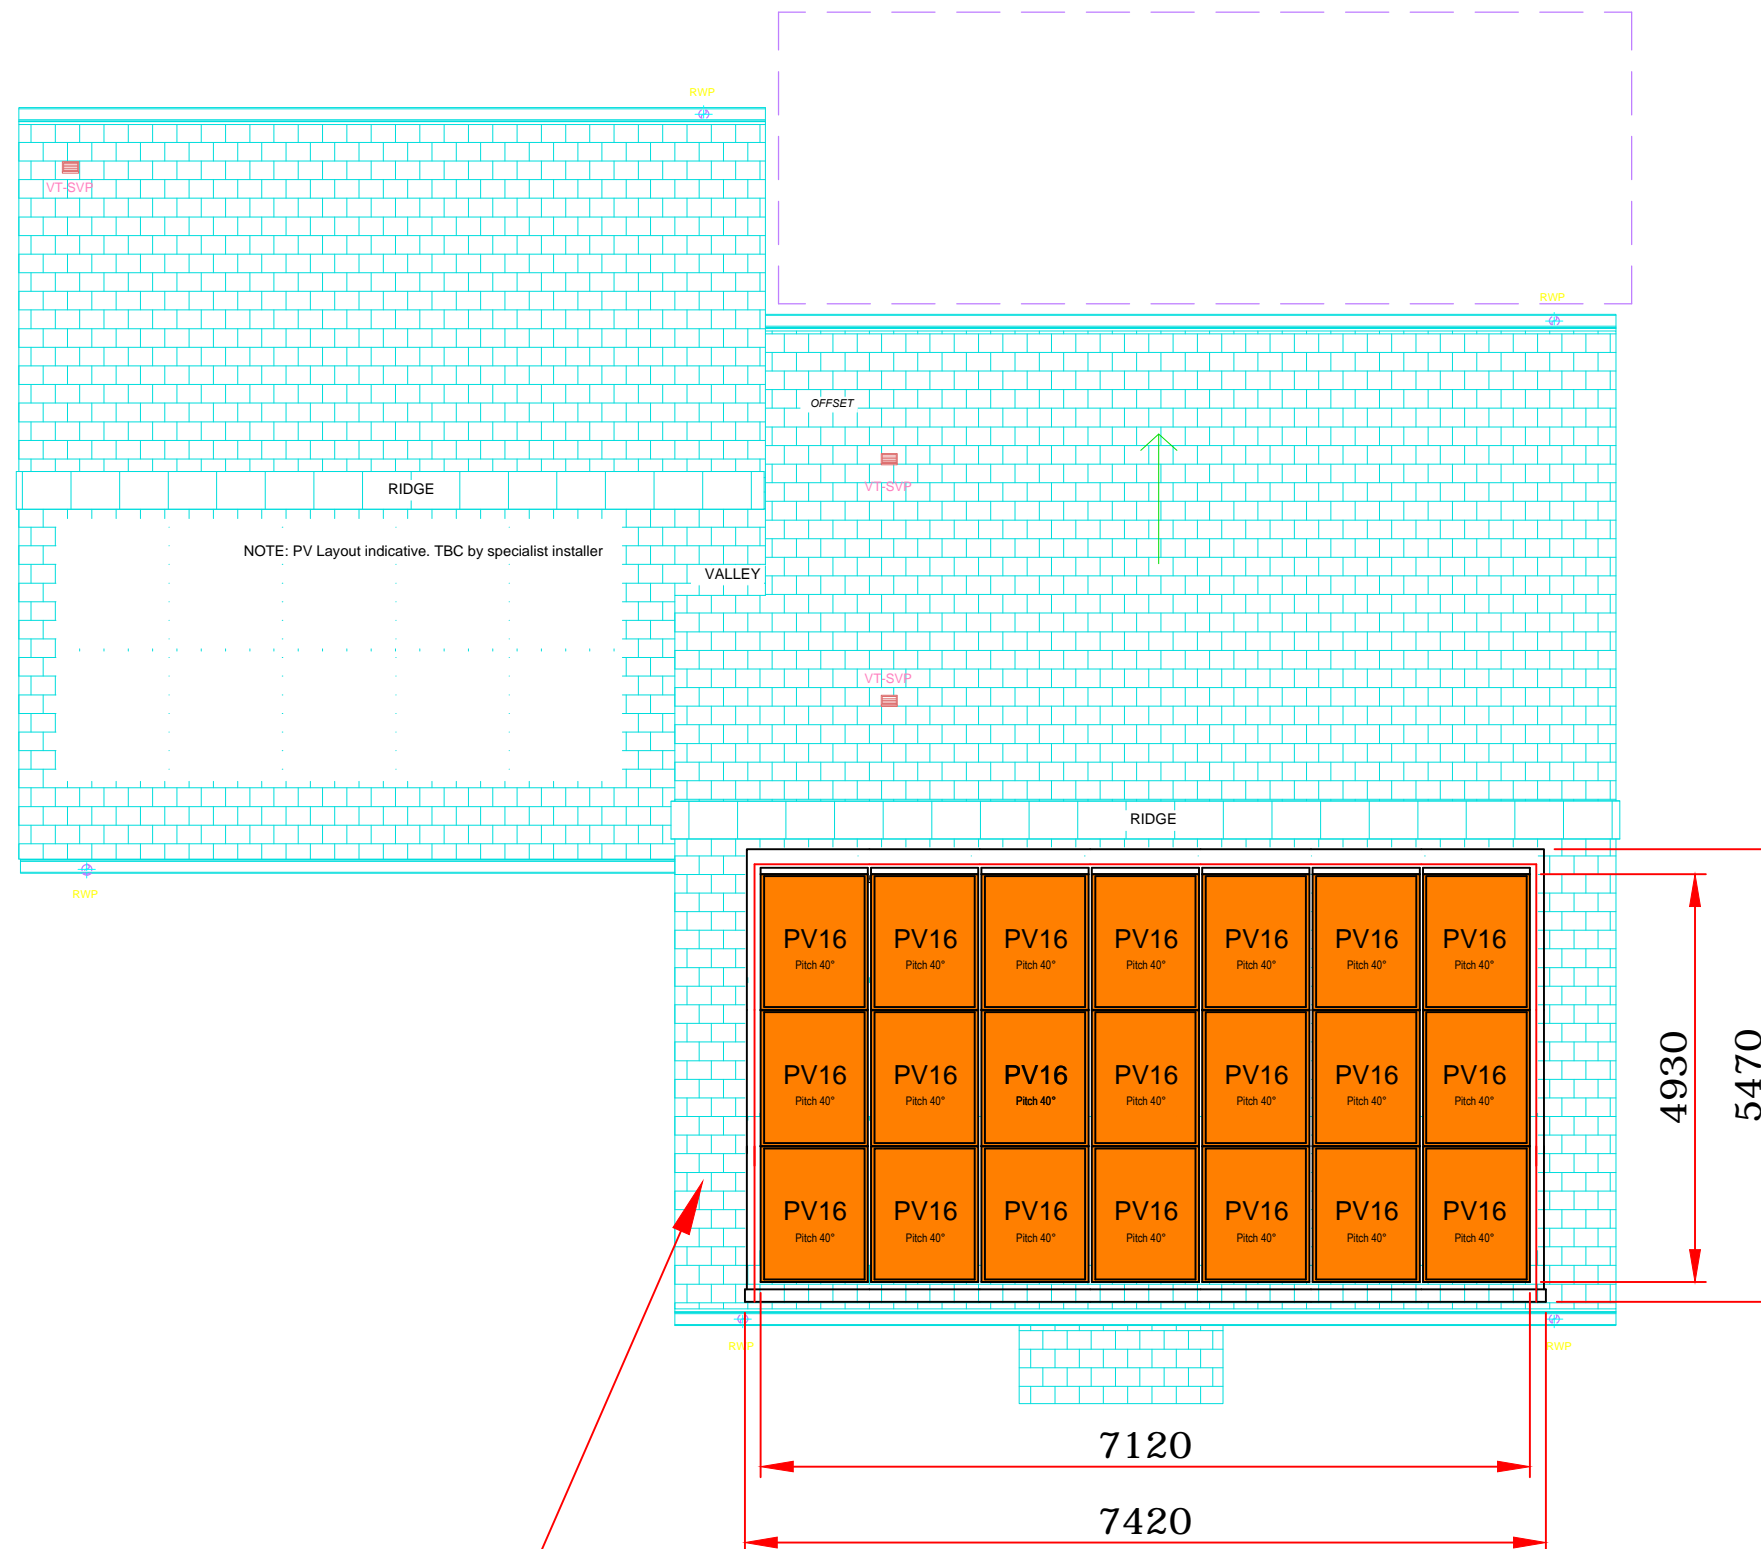

Front Elevation

Plot 269 (As Shown)
 Plot 271 (Opposite Hand)
 Plot 272 (As Shown)

On Slope Measurements

Rev	Description	Dwn	Chck	Date



**PHOTON
ENERGY**

© Photon Energy Ltd
 8 Windsor Square
 Silver Street
 Reading, RG1 2TH
 Tel +44 118 997 7470
 info@photonenergy.co.uk
 www.photonenergy.co.uk
 All rights reserved

Project Number: I1546	
Project Name: NW Bicester Phase 2	
Drawing By: Rikki Baker	Scale: 1:70 @ A3
Checked By: Nikolaos Kallitsis	Date: 09/02/2017
Drawing Name: PV Roof Layout - Plan View Plots 269 & 271-272	
Drawing No: I1546-106-01	Rev: -