
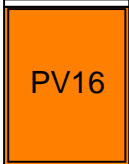


DRAWING LEGEND

Per Plot
 Installed Power: 2.6 kWp
 10 Modules 260Wp each
 Modules @40 Degrees

 PV16
 1640x992mm
 21kg

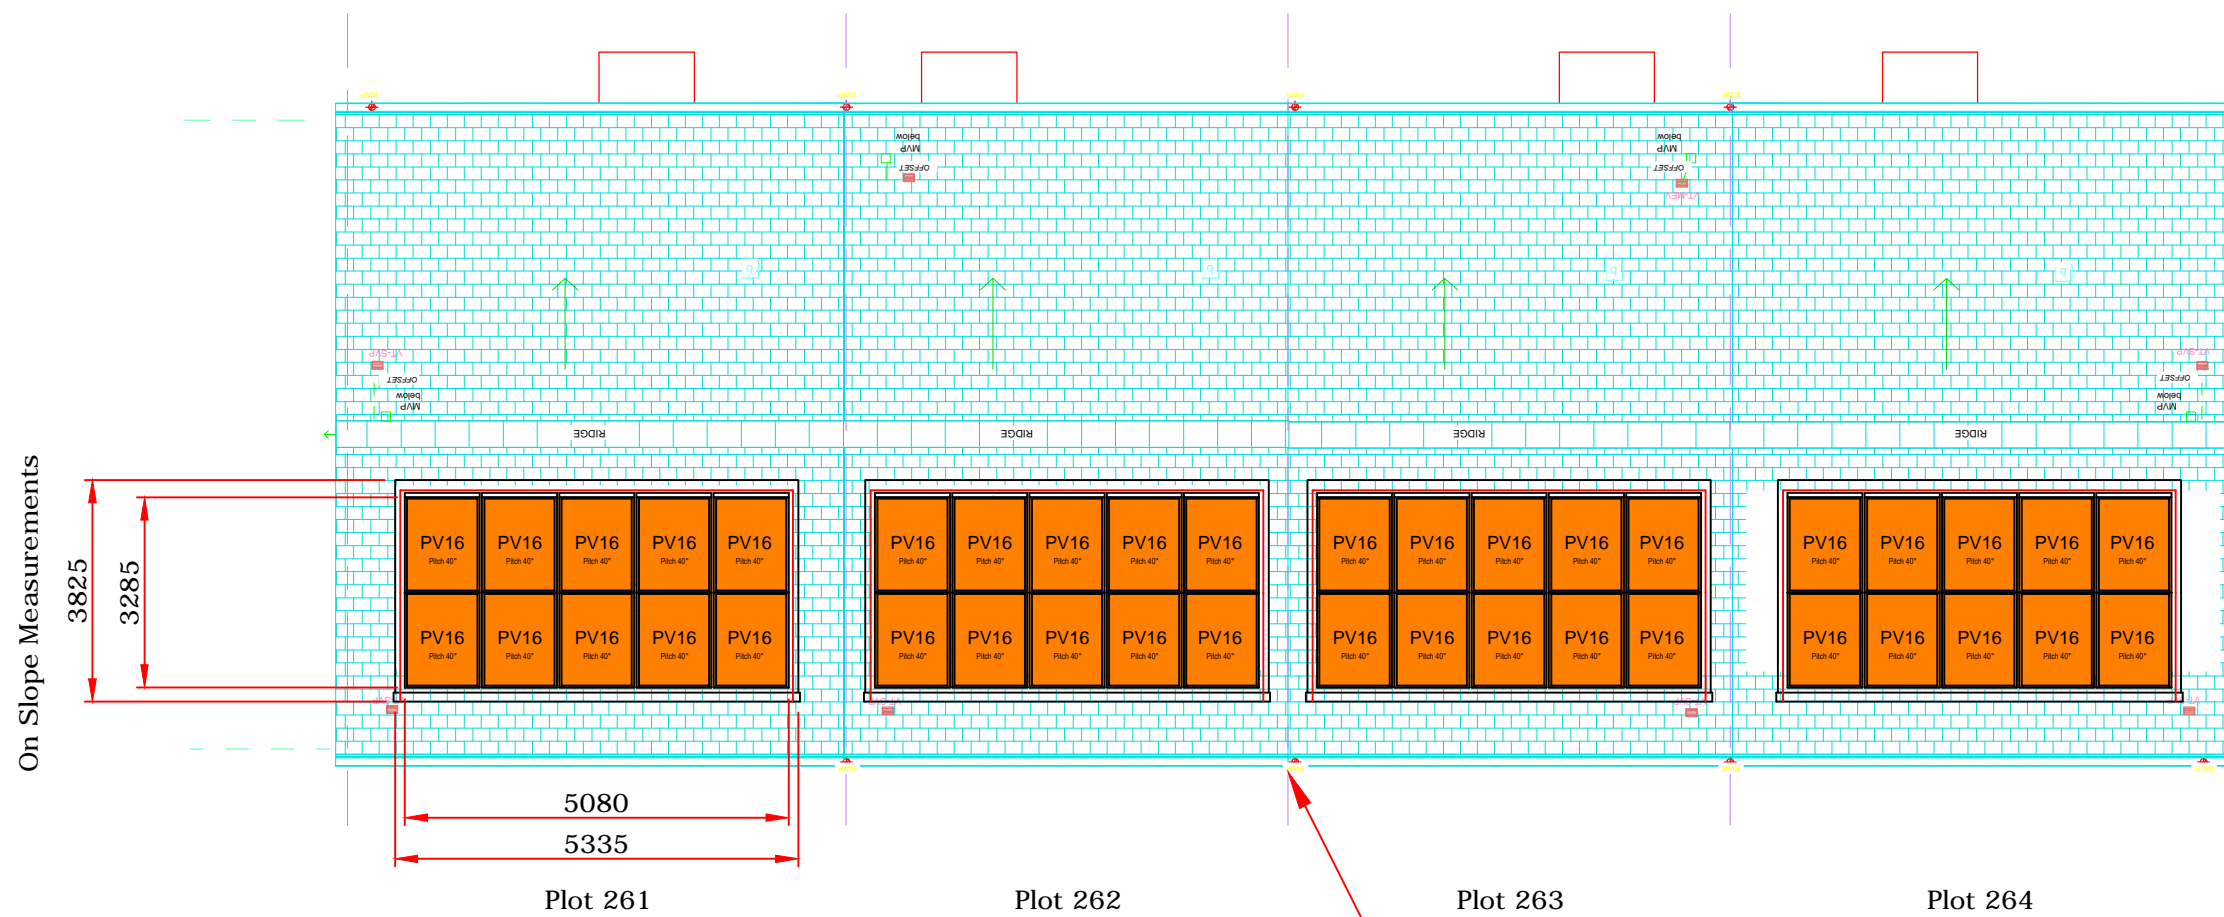

On Slope Measurements

Rev	Description	Dwn	Chk	Date



**PHOTON
 ENERGY**

© Photon Energy Ltd
 8 Windsor Square
 Silver Street
 Reading, RG1 2TH
 Tel +44 118 997 7470
 info@photonenergy.co.uk
 www.photonenergy.co.uk
 All rights reserved

Project Number: I1546	
Project Name: NW Bicester Phase 2	
Drawing By: Rikki Baker	Scale: 1:100 @ A3
Checked By: Nikolaos Kallitsis	Date: 08/02/2017
Drawing Name: PV Roof Layout - Plan View Plots 261-264	
Drawing No: I1546-104-01	Rev: -

Rear Elevation