

STATISTICS				
Description	Symbol	Avg	Min	Min/Avg
Access Road 2	+	10 lux	2 lux	0.20


LUMINAIRE SCHEDULE				
Symbol	Label	Catalog Number	Description	Watts
	A	1x FTS.2.LA084.NR on 8m Column	FACTOR SMALL STREETLIGHT	70
	B	1x FTS.2.LA084.AY on 8m Column	FACTOR SMALL STREETLIGHT	70



© Engineering Services Consultancy Limited.
 This drawing is copyright and must not be reproduced in part or whole without prior written consent.
 Contractors must verify all dimensions on site before commencing works.
 All works shall be coordinated with all other trades.



RESIDUAL RISK REGISTER			
NO.	DESCRIPTION OF HAZARD	CONTROL MEASURES	ACTION BY
1.	THERE ARE NO RESIDUAL RISKS THAT A COMPETENT PERSON WOULD NOT EXPECT	RISK ASSESSMENT + METHOD STATEMENTS	CONTRACTOR

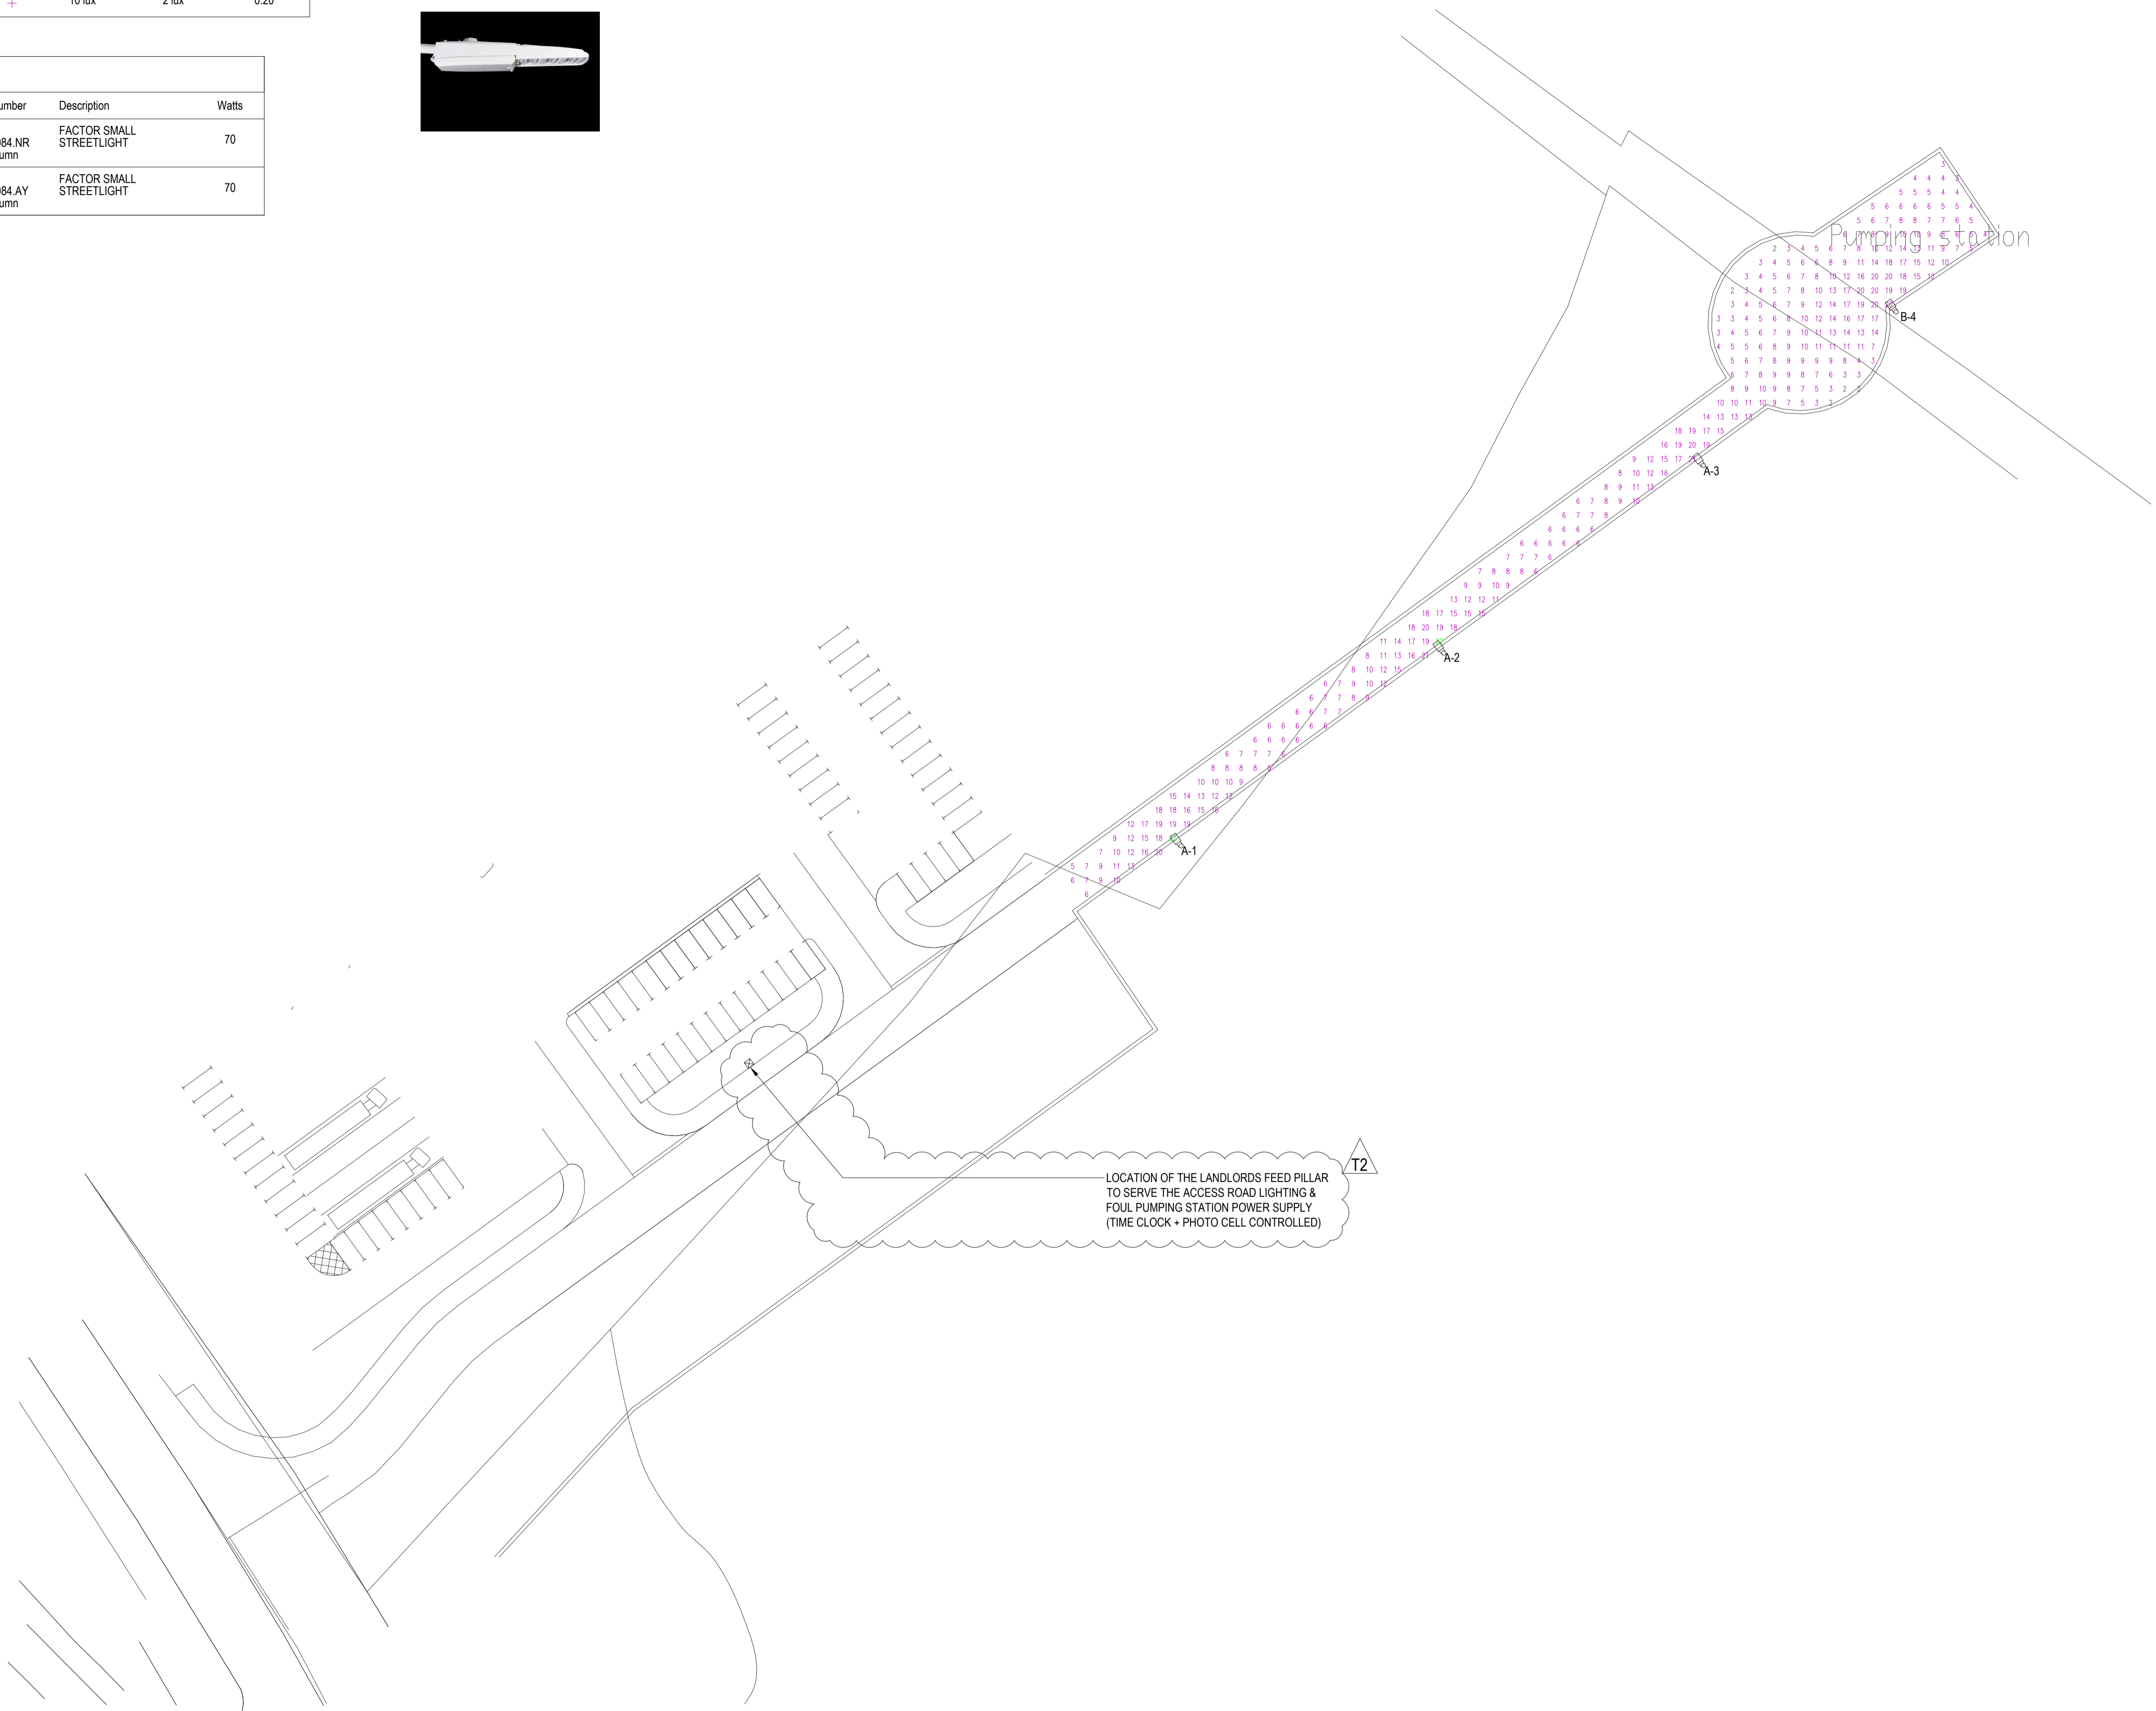


THIS DRAWING IS FOR INFORMATION ONLY AND DEMONSTRATES DESIGN INTENT. IT HAS NOT BEEN PRODUCED FROM DEFINITIVE DESIGN CALCULATIONS AND SHALL NOT BE USED FOR INSTALLATION PURPOSES. IT IS THE CONTRACTORS RESPONSIBILITY TO DESIGN, PROVIDE AND INSTALL ALL PLANT AND EQUIPMENT DETAILED WITHIN THE ENGINEERING SERVICES CONSULTANCY SPECIFICATION(S), AS THIS DRAWING DOES NOT DETAIL EACH AND EVERY ITEM OF PLANT AND EQUIPMENT THAT MAY BE NECESSARY

T2	12.06.16	Tender Issue	CP
T1	09.06.16	Tender Issue	AW
Rev.	Date	Details	Initials

Engineering Services Consultancy Ltd
 Griffin House
 19 Ludgate Hill
 Birmingham
 B5 1DW

T: 0121 214 8998
 F: 0121 214 8999
 W: www.esccuk.com

Client

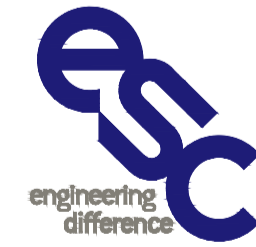

Albion Land



Project
 Link 9 - Bakel Units 3A & 3B

Drawing Title
 Access Road A2
 External Lighting Layout

Purpose
TENDER ISSUE

Scale @ A1
 1:500

Date
 May 2017

Drawn
 AW

Checked
 AW

Drawing No.
 ESC1298/E/004

Revision
 T2