




RESIDUAL RISK REGISTER			
NO.	DESCRIPTION OF HAZARD	CONTROL MEASURES	ACTION BY
1.	THERE ARE NO RESIDUAL RISKS THAT A COMPETENT PERSON WOULD NOT EXPECT	RISK ASSESSMENT + METHOD STATEMENTS	CONTRACTOR

STATISTICS				
Description	Symbol	Avg	Min	Mini/Avg
Access Road 1	+	10 lux	2 lux	0.20

LUMINAIRE SCHEDULE				
Symbol	Label	Catalog Number	Description	Watts
	A	1 x FTS.2.LA084.NR on 8m Column	FACTOR SMALL STREETLIGHT	70

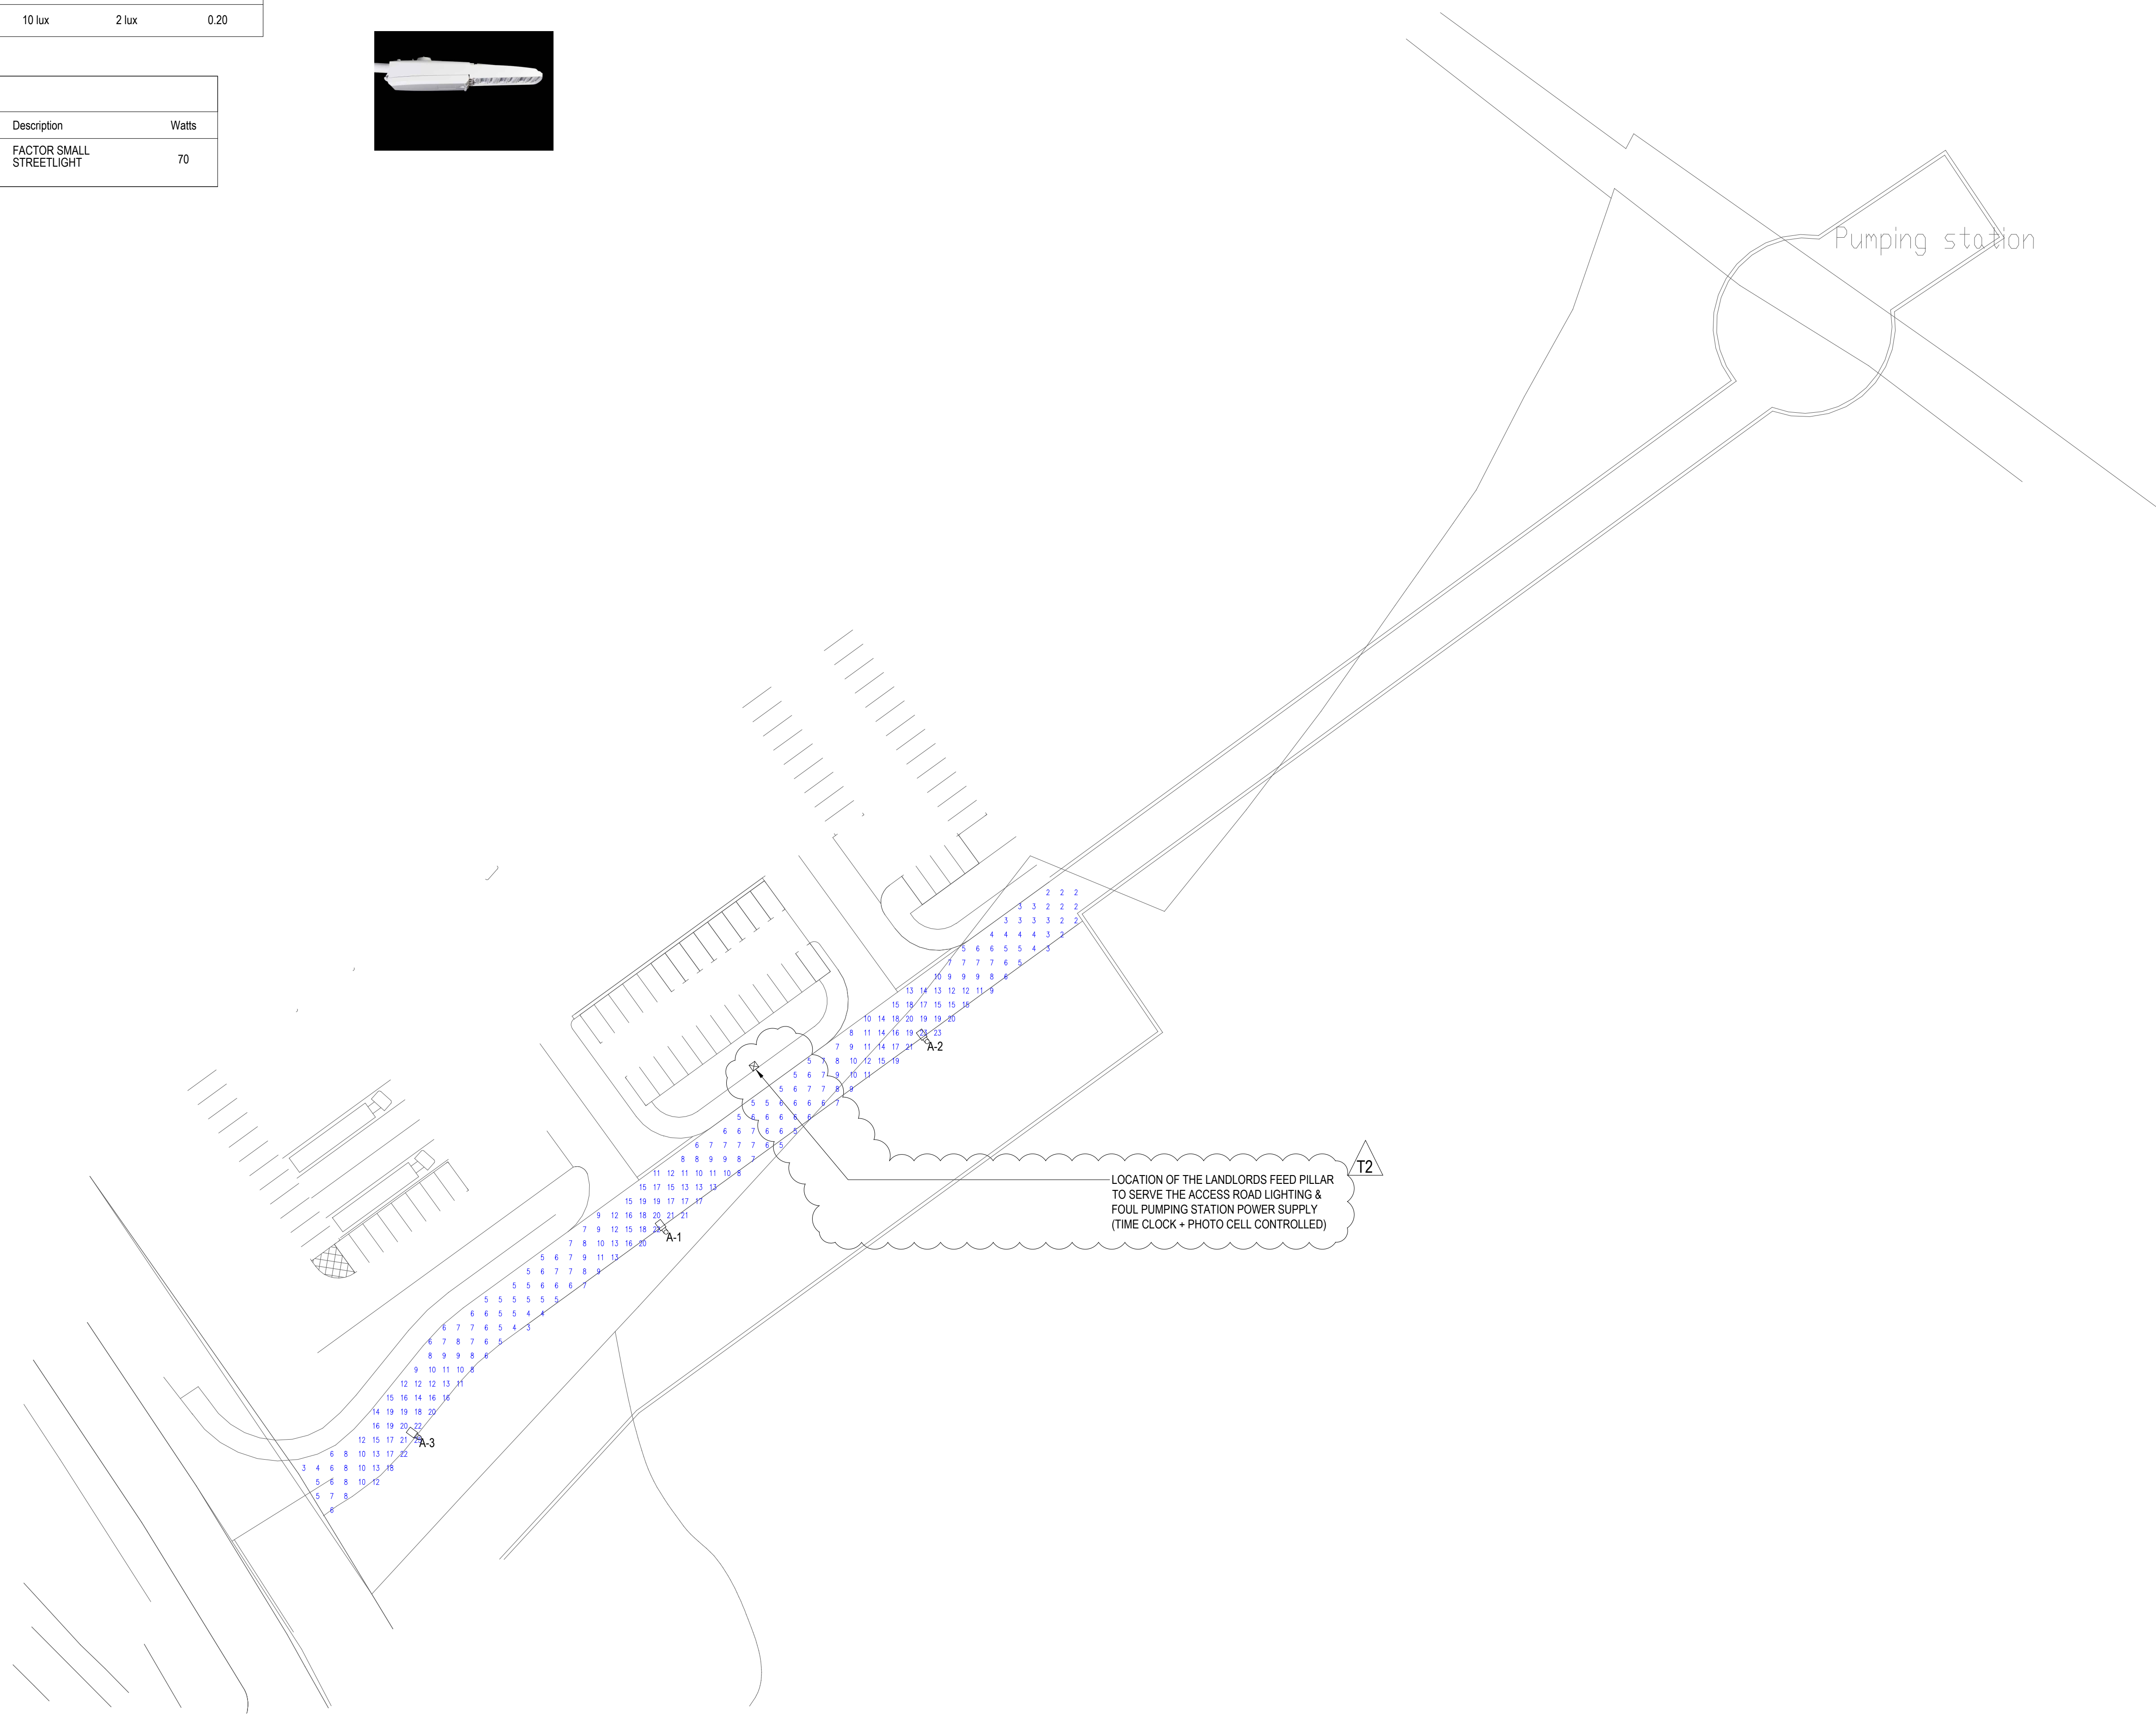

THIS DRAWING IS FOR INFORMATION ONLY AND DEMONSTRATES DESIGN INTENT. IT HAS NOT BEEN PRODUCED FROM DEFINITIVE DESIGN CALCULATIONS AND SHALL NOT BE USED FOR INSTALLATION PURPOSES. IT IS THE CONTRACTORS RESPONSIBILITY TO DESIGN, PROVIDE AND INSTALL ALL PLANT AND EQUIPMENT DETAILED WITHIN THE ENGINEERING SERVICES CONSULTANCY SPECIFICATION(S), AS THIS DRAWING DOES NOT DETAIL EACH AND EVERY ITEM OF PLANT AND EQUIPMENT THAT MAY BE NECESSARY

Rev.	Date	Details	Initials
T2	12.06.16	Tender Issue	CP
T1	09.06.17	Tender Issue	AW

Engineering Services Consultancy Ltd  
 Griffin House  
 19 Ludgate Hill  
 Birmingham  
 B5 1DW

T: 0121 214 8998  
 F: 0121 214 8999  
 W: www.esccuk.com

Client



Albion Land

Project  
 Link 9 - Bakel Units 3A & 3B

Drawing Title  
 Access Road A1  
 External Lighting Layout

Purpose  
**TENDER ISSUE**

Scale @ A1  
 1:500

Date  
 May 2017

Drawn  
 AW

Checked  
 AW

Drawing No.  
 ESC1298/E/003

Revision  
 T2