


- NOTES**
- CONTRACTORS MUST CHECK ALL DIMENSIONS ON SITE. ONLY FIGURED DIMENSIONS ARE TO BE WORKED FROM. DISCREPANCIES MUST BE REPORTED TO THE ARCHITECT OR ENGINEER BEFORE PROCEEDING. © THIS DRAWING IS COPYRIGHT.
  - REPRODUCED FROM OS SITEMAP © BY PERMISSION OF ORDNANCE SURVEY © ON BEHALF OF THE CONTROLLER OF HER MAJESTY'S STATIONERY OFFICE. © CROWN COPYRIGHT 2008. ALL RIGHTS RESERVED. LICENCE NUMBER 100007126.
  - UNTIL TECHNICAL APPROVAL HAS BEEN OBTAINED FROM THE RELEVANT AUTHORITIES, ALL DRAWINGS ARE ISSUED AS PRELIMINARY AND NOT FOR CONSTRUCTION. SHOULD THE CONTRACTOR COMMENCE SITE WORK PRIOR TO APPROVAL BEING GIVEN IT IS ENTIRELY AT HIS OWN RISK.
  - LEVELS TO BE +/- 450mm.
  - NOTE ALL PRIVATE HARD STANDING AREAS TO BE SERVED BY PRIVATE GULLIES/ DRAINAGE CHANNELS AND NOT DESIGNED TO FLOW ONTO ADOPTABLE ROADS/ FOOTPATHS.

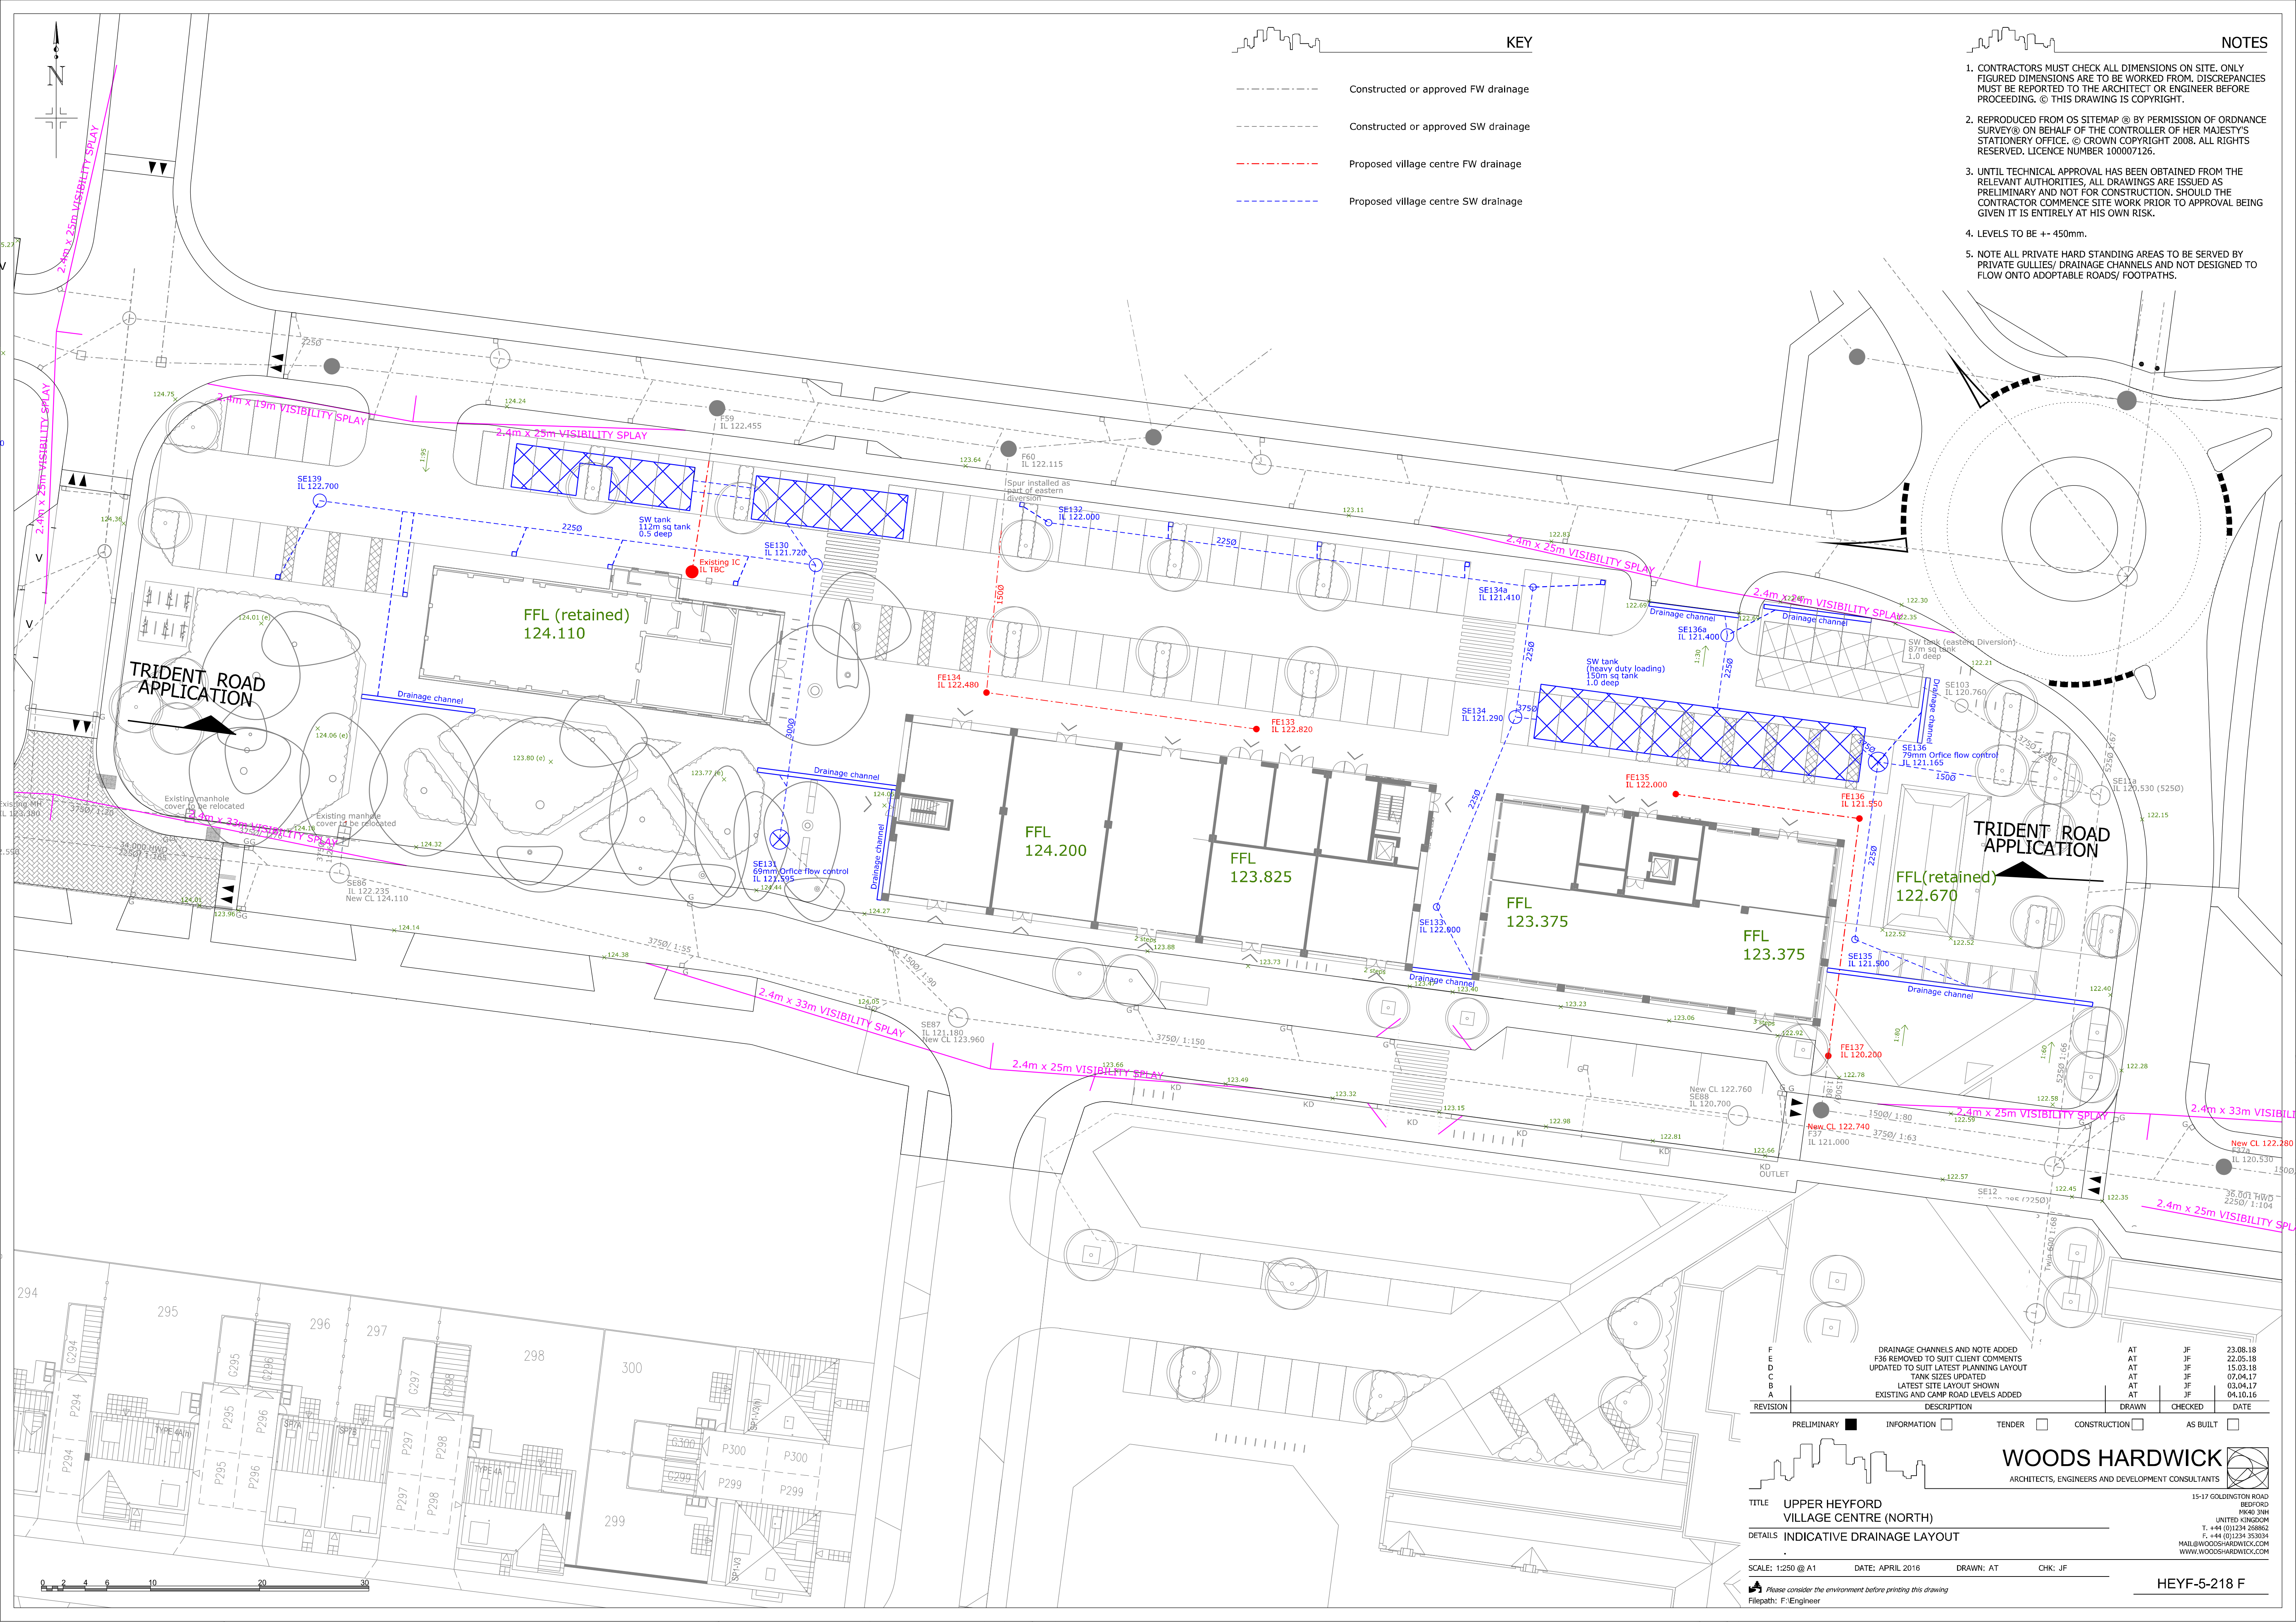

TRIDENT ROAD APPLICATION

TRIDENT ROAD APPLICATION

REVISION	DESCRIPTION	DRAWN	CHECKED	DATE
F	DRAINAGE CHANNELS AND NOTE ADDED	AT	JF	23.08.18
E	F36 REMOVED TO SUIT CLIENT COMMENTS	AT	JF	22.05.18
D	UPDATED TO SUIT LATEST PLANNING LAYOUT	AT	JF	15.03.18
C	TANK SIZES UPDATED	AT	JF	07.04.17
B	LATEST SITE LAYOUT SHOWN	AT	JF	03.04.17
A	EXISTING AND CAMP ROAD LEVELS ADDED	AT	JF	04.10.16

STATUS	DESCRIPTION	DATE
<input checked="" type="checkbox"/>	PRELIMINARY	
<input type="checkbox"/>	INFORMATION	
<input type="checkbox"/>	TENDER	
<input type="checkbox"/>	CONSTRUCTION	
<input type="checkbox"/>	AS BUILT	

**WOODS HARDWICK**  
ARCHITECTS, ENGINEERS AND DEVELOPMENT CONSULTANTS

TITLE: UPPER HEYFORD VILLAGE CENTRE (NORTH)  
DETAILS: INDICATIVE DRAINAGE LAYOUT

SCALE: 1:250 @ A1    DATE: APRIL 2016    DRAWN: AT    CHK: JF

FILEPATH: F:\ENGINEER

HEYF-5-218 F