

NOTES

DETAIL A

CHERWELL
CONSTRUCTION SERVICES

ARCHITECTURAL CONSULTANCY
 BUILDING CONTROL CONSULTANCY
 CIVIL AND MUNICIPAL ENGINEERING CONSULTANCY

Mr Ing Ron Barnett CEng FICE MRgt
 Construction Services Manager
 Bodicote House Bodicote Banbury Oxon OX15 4AA
 Tel: 0295 252535 Fax: 0295 270028


CLIENT
Thames Water Utilities

PROJECT:
BODICOTE OUTFALL SEWER INFILTRATION EXCLUSION

DRAWING TITLE
AS LAID PLAN, BODICOTE

FILE: 76-16-12	PROCESS CODE: T8106
DATE: MAY 1995	DRAWN: S.J.W.
SCALE: 1 : 1250	CHECKED: G.G.W.C.
	AUTHORISED: G.G.W.C.

DRAWING No: CD 2492/7

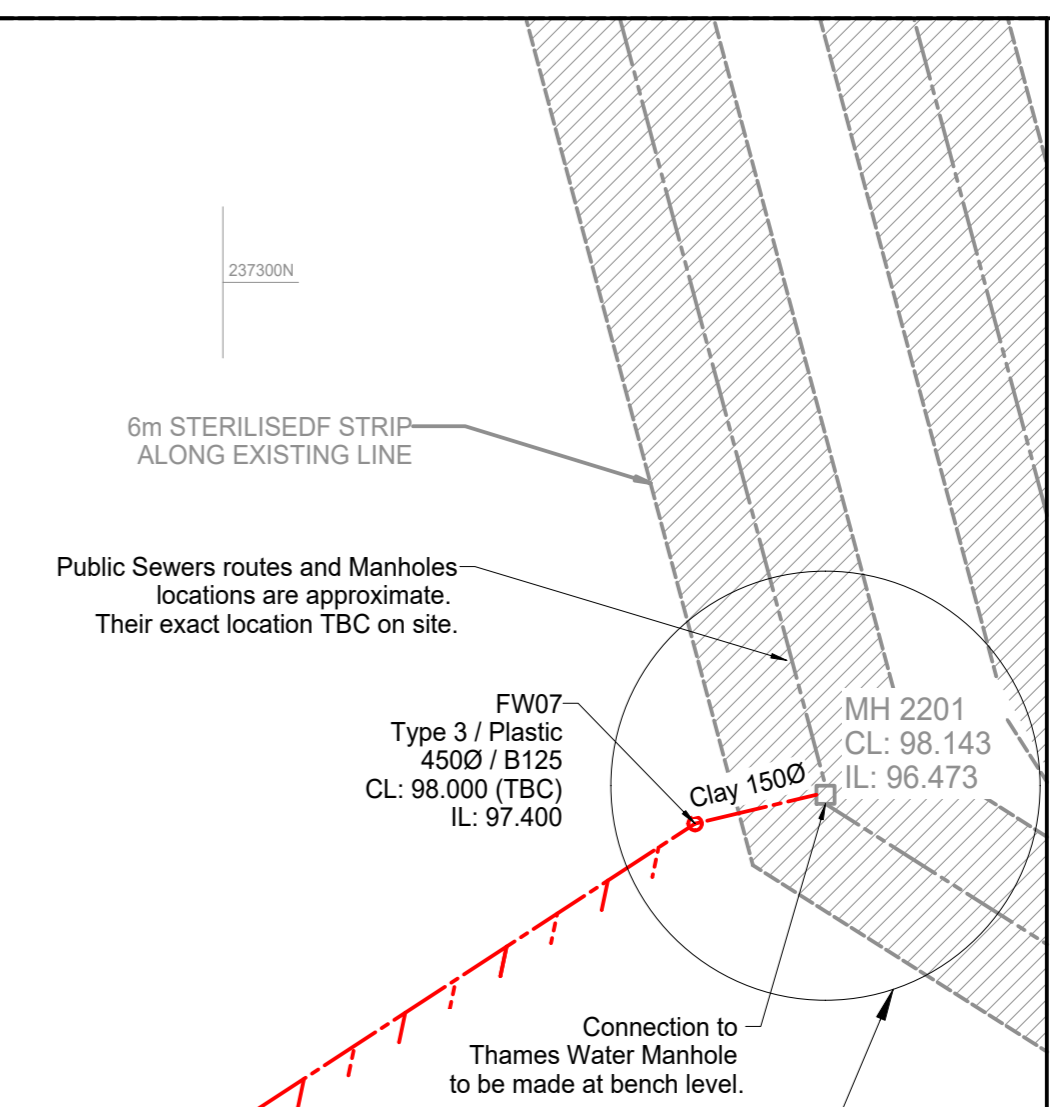

Refer to Detail A

90mm / PE100 / SDR17
 Installed within bedding
 Type S at 900mm cover
 minimum.

FW Washout valve
 Location TBC by Contractor

MH 2151
 CL: 92.869
 IL: 91.419

Rising Main

Xylem SPS 1500 Series Pump Station
 Diameter: 1500mm Duty/Assist
 Electricity: 3 Phase Connection
 Shaft: 2210mm
 Effective volume: 720 litres
 Pump rate: 4 l/s
 CL: 94.685 (TBC)
 IL: 93.07

NOTES
 1. Notes and assumptions as per drawing 1377S 100P1.

Rev	Description	Date
T2	Existing Sewer Routes added. Intermediate IC added, to enable discharge by gravity into public sewer.	12.06.18
T1	Preliminary	01.05.18



Solid Studio Tel: 01608 690 858
 12 Albion Street info@solid-structures.com
 Chipping Norton OX7 5BJ www.solid-structures.com

Project
**Brooklands Barn,
 Bodicote**

Drawing Title
**Drainage Layout
 Sheet 2 of 2**

By: TE	Date: 12.06.18	Checked: ARD	Date: 12.06.18
Scale: 1:500 @ A1	Job Number: 1377S		
Drawing Status: Tender	Drawing Number: 101T2		